
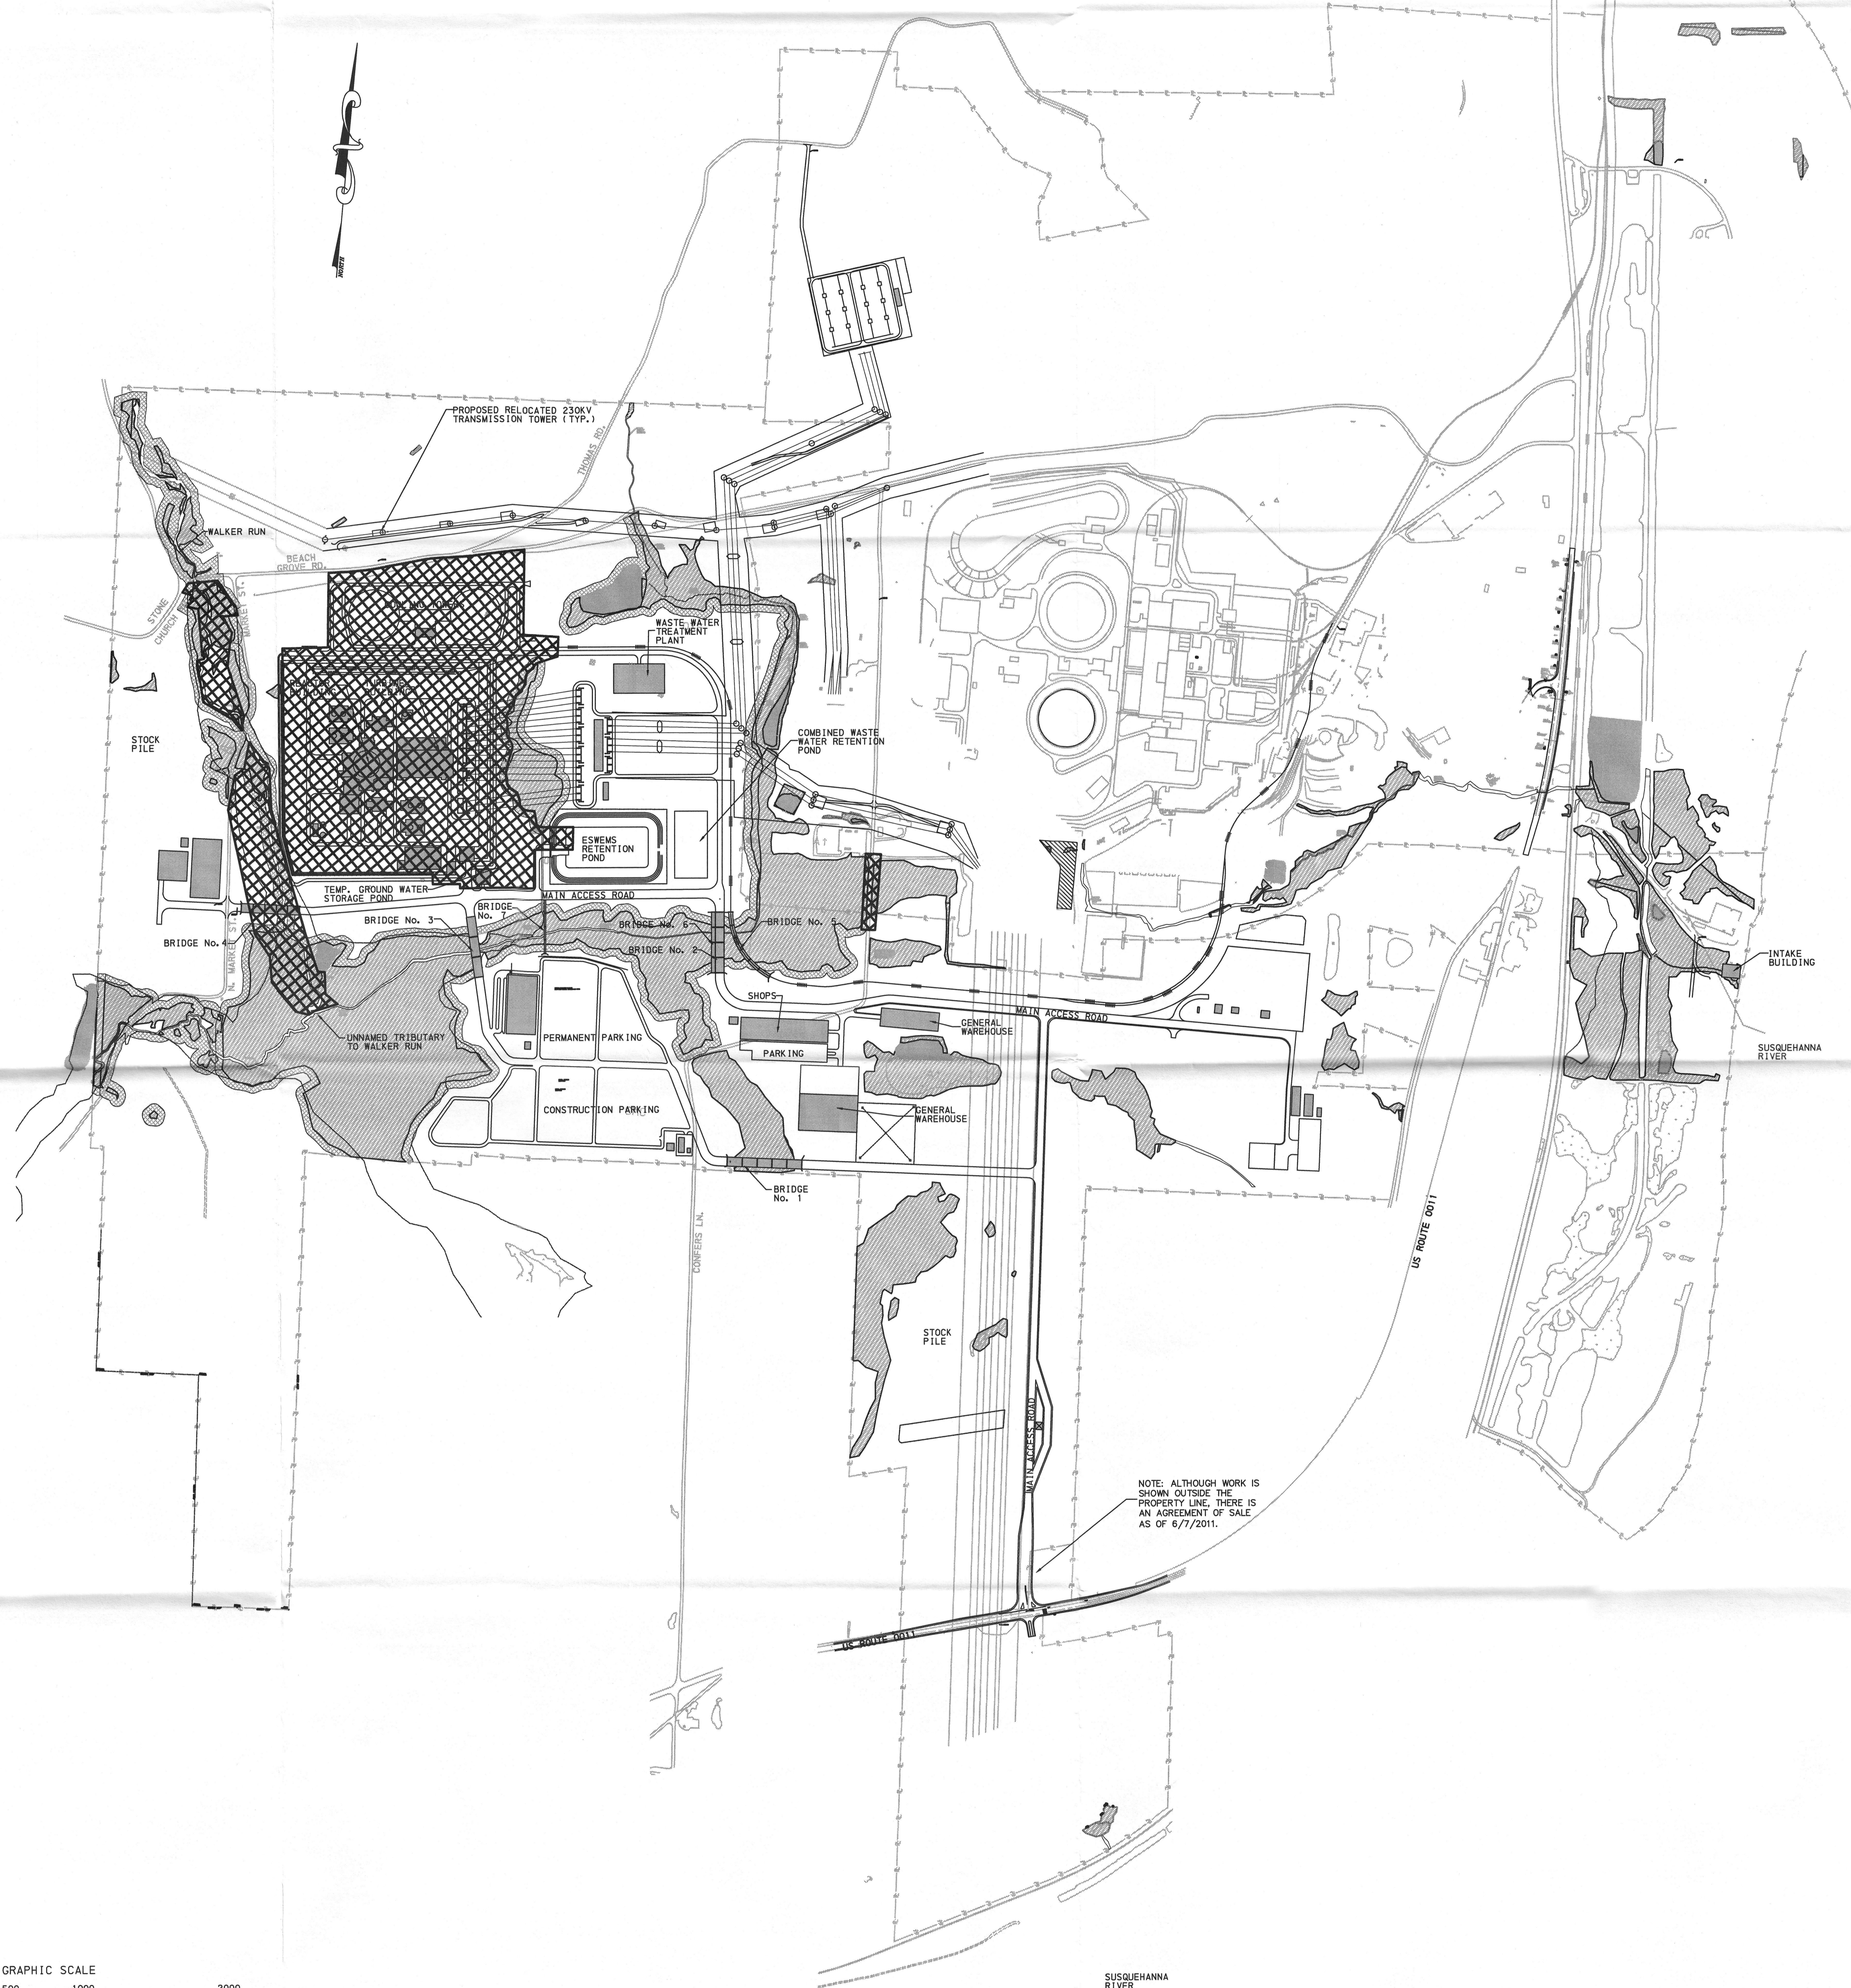



DATE PLOTTED: 9/15/2011 10:58 AM  
DRAWN BY: JFM  
CHECKED BY: LGB

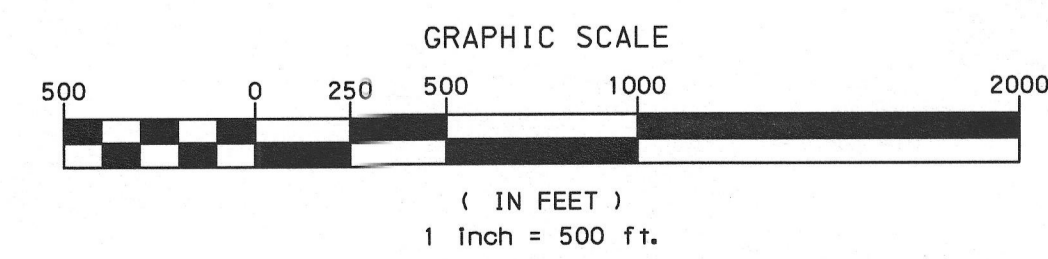

NOTE: ALTHOUGH WORK IS SHOWN OUTSIDE THE PROPERTY LINE, THERE IS AN AGREEMENT OF SALE AS OF 6/7/2011.

 ACTIVE CONSTRUCTION ZONE

Pennoni Associates Inc.

100 N. Wilson-Barre Boulevard  
Wilson-Barre, PA 17268 (717) 864-8800

Engineers • Surveyors • Planners • Landscape Architects

JOB NO.	PPLS0902
SHEET	11 OF 11
SCALE	1"=500'
DRAWN BY	LGB
DATE	9/15/2011
APPROVED	JFM
DRAWING NO.	CS9010

**BELL BEND NUCLEAR POWER PLANT**  
 PHASE 10 MAP  
**PPL BELL BEND, LLC**  
 38 BOMBAY LANE, SUITE 2  
 BERWICK, PA 18603

ALL DIMENSIONS MUST BE VERIFIED BY CONTRACTOR AND OWNER MUST BE NOTIFIED OF ANY DISCREPANCIES BEFORE PROCEEDING WITH THE WORK.

DATE	NO.	REVISIONS	BY
9/15/11	1	EXCESS PROPERTY REMOVAL AND LID COMMENTS	LGB
11/27/08	0	INITIAL SUBMISSION	LGB



D11