
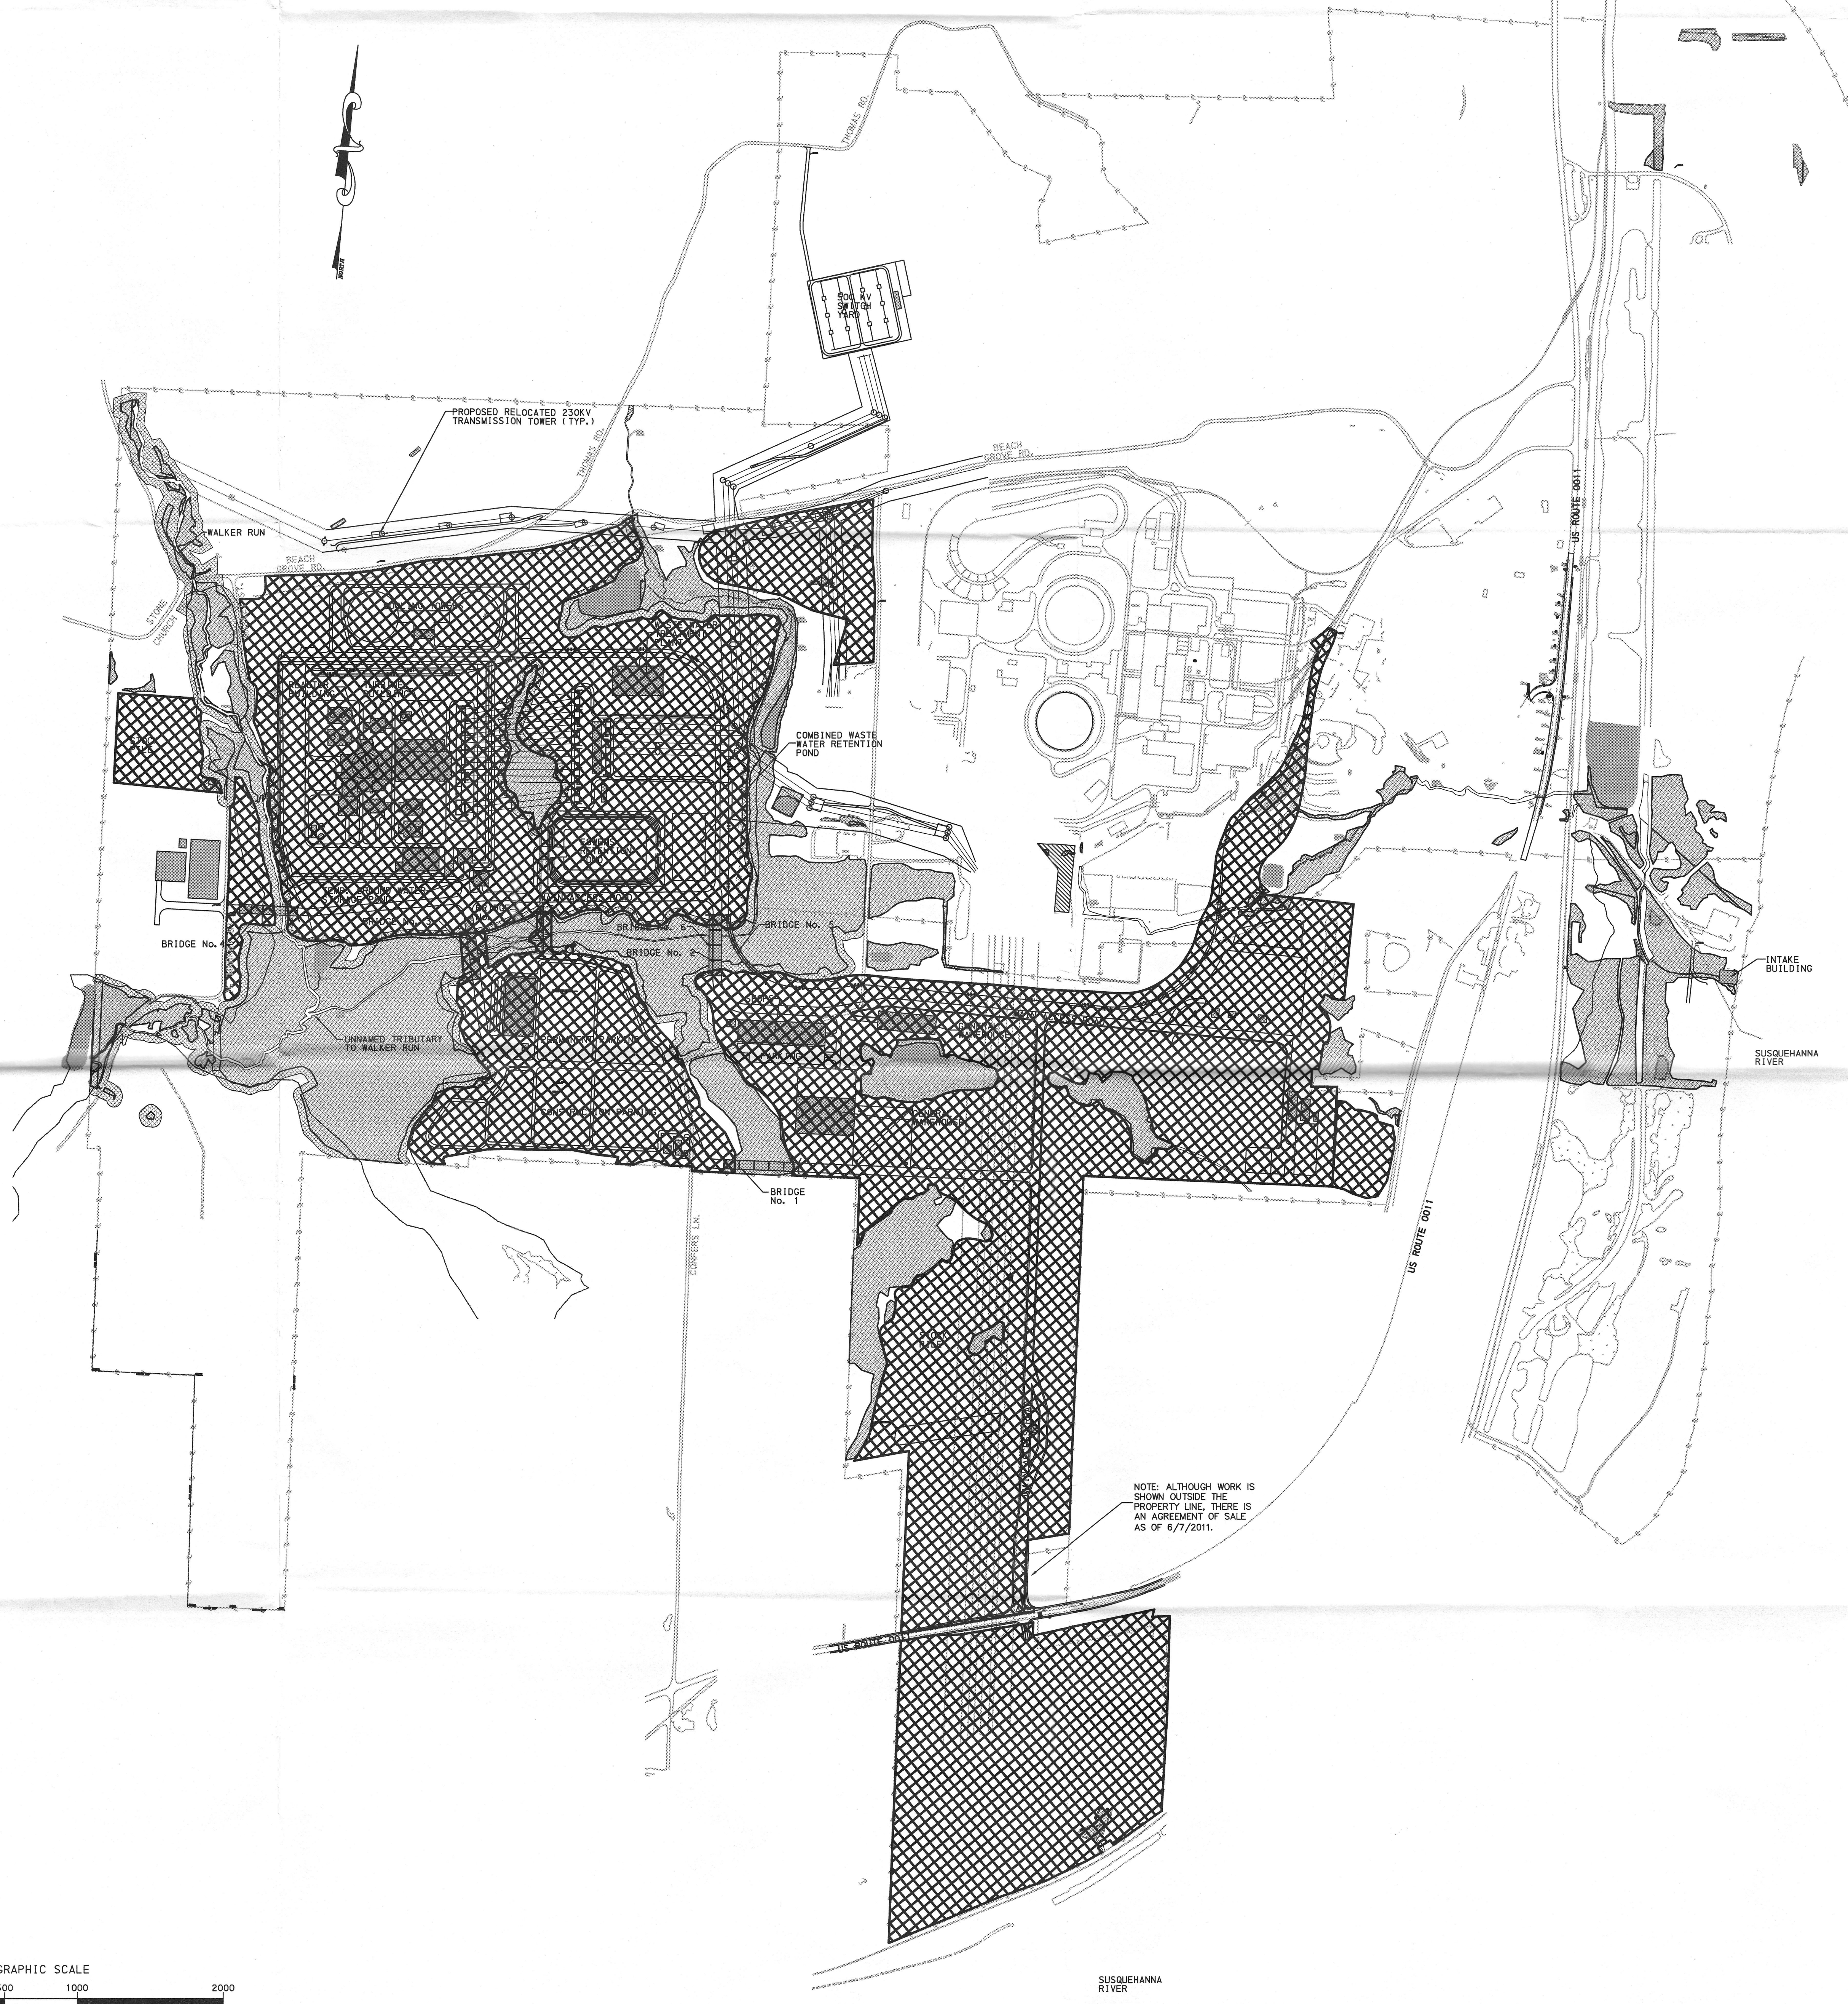


P:\PROJECTS\11111\11111.dwg (11/15/2011) - Bell Bend Land Development\11111.dwg (11/15/2011)

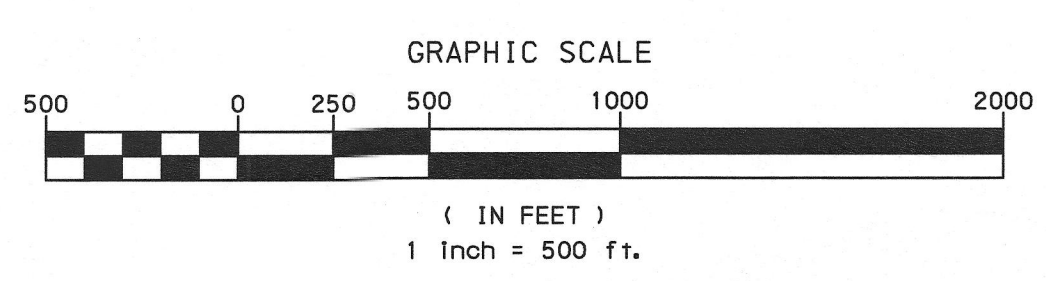

ACTIVE CONSTRUCTION ZONE

**Pennoni Associates Inc.**

100 N. Willow-Barre Boulevard  
 Willow-Barre, PA 18702 (717) 284-2800


**Engineers • Surveyors • Planners • Landscape Architects**

	JOB NO. PPLS0902
SCALE 1"=500' DRAWN BY LGB	SHEET 4 OF 11
DATE 9/15/2011 APPROVED JFM	DRAWING NO. <b>CS9003</b>

**BELL BEND NUCLEAR POWER PLANT**  
 SALEM TOWNSHIP, PENNSYLVANIA  
**PHASE 3 MAP**  
**PPL BELL BEND, LLC**  
 38 BAMBURY LANE, SUITE 2  
 ESTIMONK, PA 18033

ALL DIMENSIONS MUST BE VERIFIED BY CONTRACTORS AND OWNER MUST BE NOTIFIED OF ANY DISCREPANCIES BEFORE PROCEEDING WITH THE WORK.

DATE	NO.	REVISIONS	BY
9/15/11	1	EXCESS DIMENSION REDUCTION	LGB
11/12/10	0	INITIAL SUBMISSION	LGB

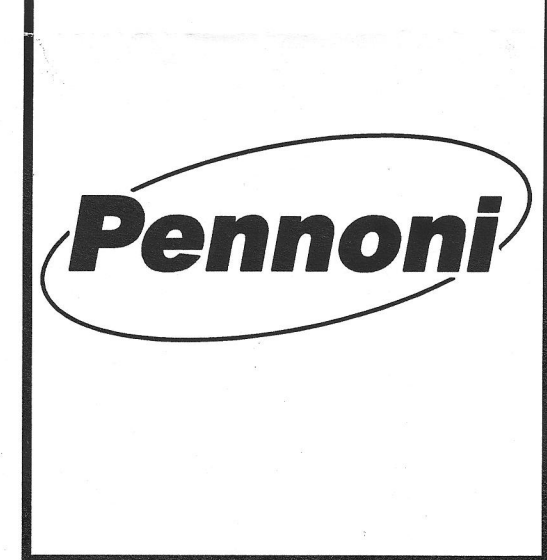

D04