
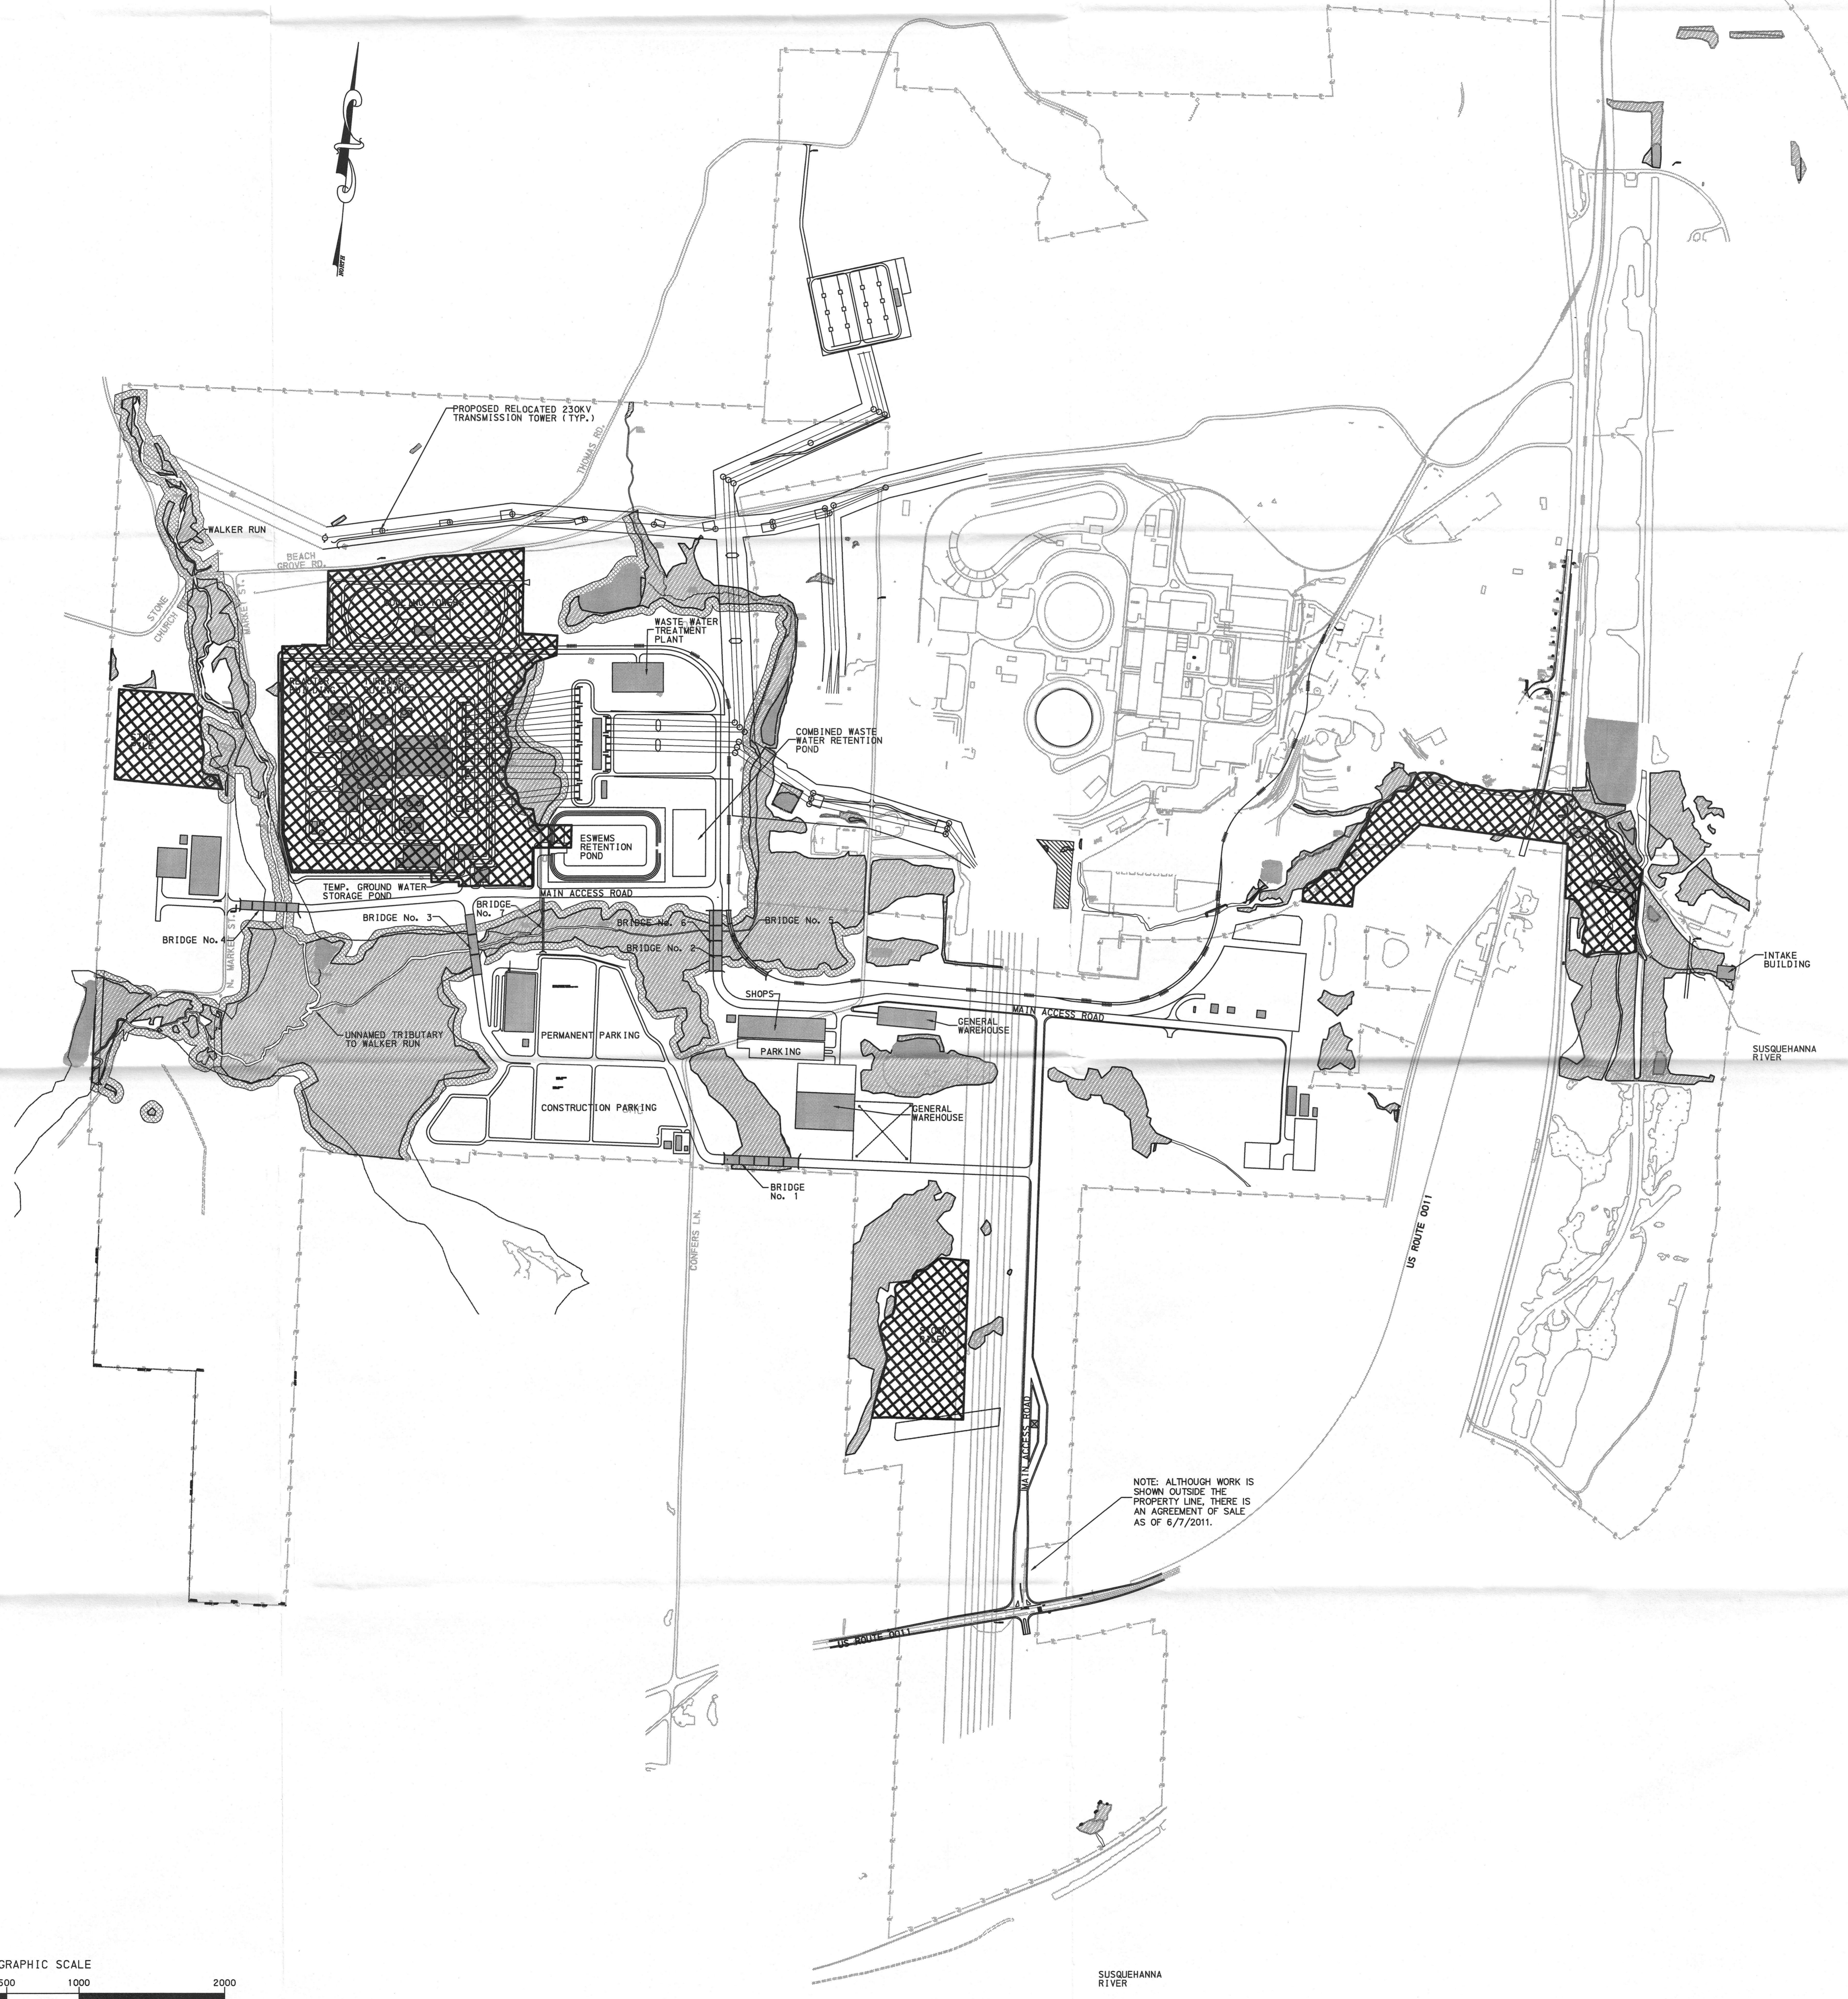


P:\Projects\2011\20110902-Bell Bend Land Development\020801\01\000000.dwg
 9/15/2011 10:58 AM
 JFM

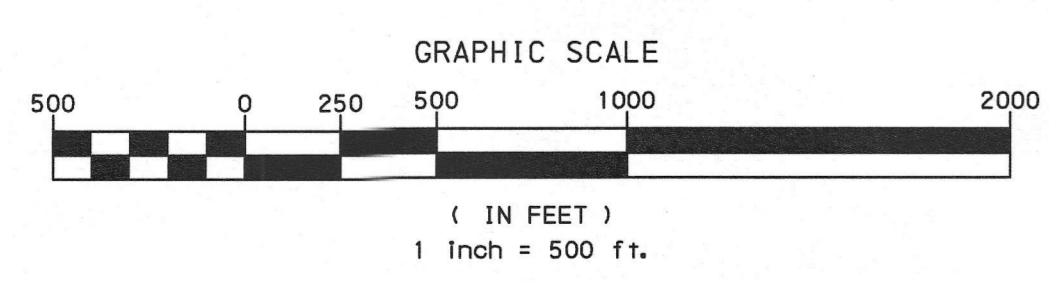

ACTIVE CONSTRUCTION ZONE

Pennoni Associates Inc.

Engineers • Surveyors • Planners • Landscape Architects


| | |
|--------------------------------------|------------------------------|
| | JOB NO. PPL50902 |
| SCALE 1"=500' DRAWN BY LGB | SHEET 9 OF 11 |
| DATE 9/15/2011 APPROVED JFM | DRAWING NO. CS9008 |

103 N. Walnut Street, Suite 201
 Wilkes-Barre, PA 18702 (717) 684-2200

BELL BEND NUCLEAR POWER PLANT
 PHASE 8 MAP
PPL BELL BEND, LLC
 38 BOMBAY LANE, SUITE 2
 BERWICK, PA 18803

ALL DIMENSIONS MUST BE VERIFIED BY CONTRACTOR AND OWNER MUST BE NOTIFIED OF ANY DISCREPANCIES BEFORE PROCEEDING WITH THE WORK

| DATE | NO. | REVISIONS | BY |
|----------|-----|--------------------------------------|-----|
| 9/15/11 | 1 | EXIST. CONSTRUCTION AND LID COMMENTS | LGB |
| 11/12/10 | 0 | INITIAL SUBMISSION | LGB |

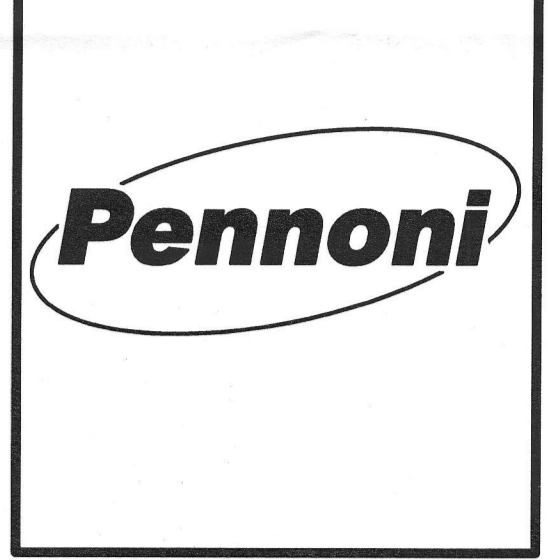

D09