

Job No. B8-692  
 Drawn: JHC  
 Checked: DDF  
 Date: 3-6-89

**ESTIMATED SUBSURFACE  
 PROFILE A-A'**

CALVERT CLIFFS NUCLEAR POWER PLANT  
 ISFSF  
 CALVERT COUNTY, MARYLAND

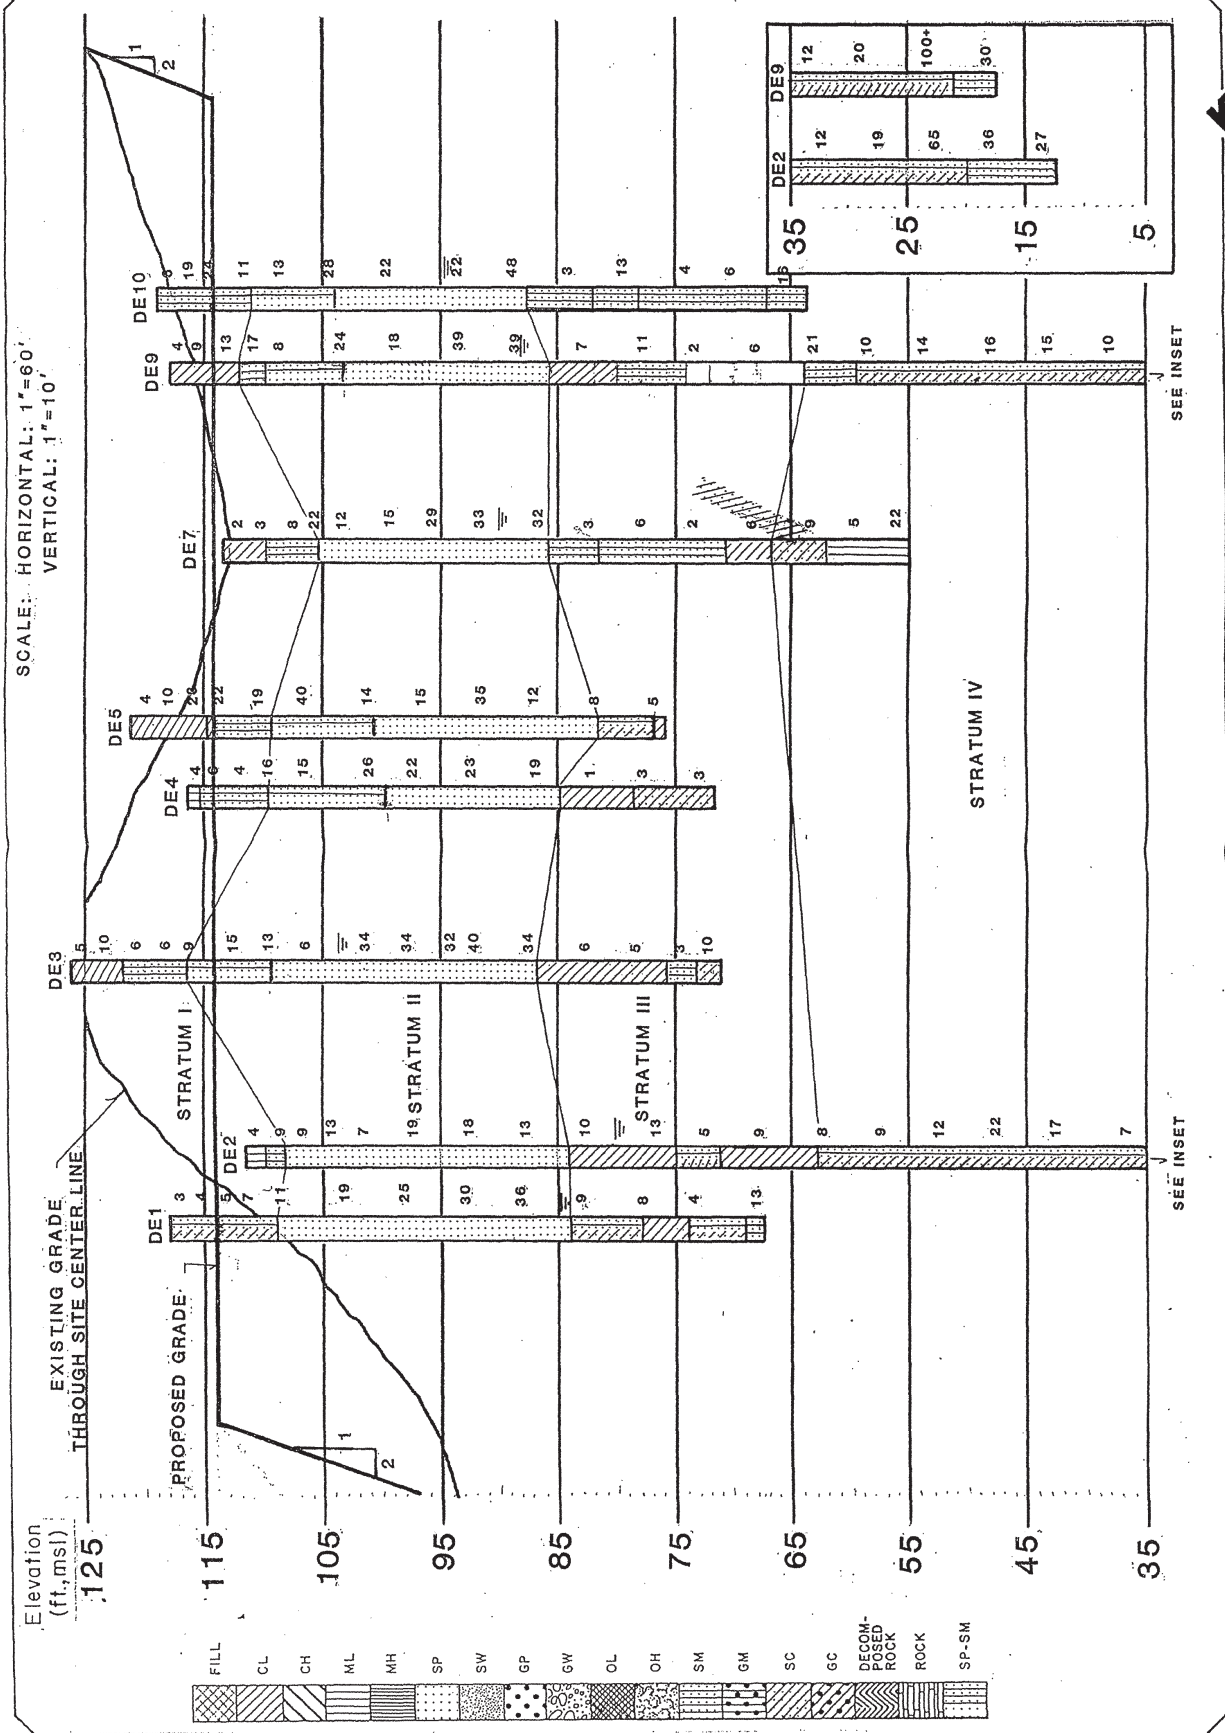


Figure 2.6-7A