



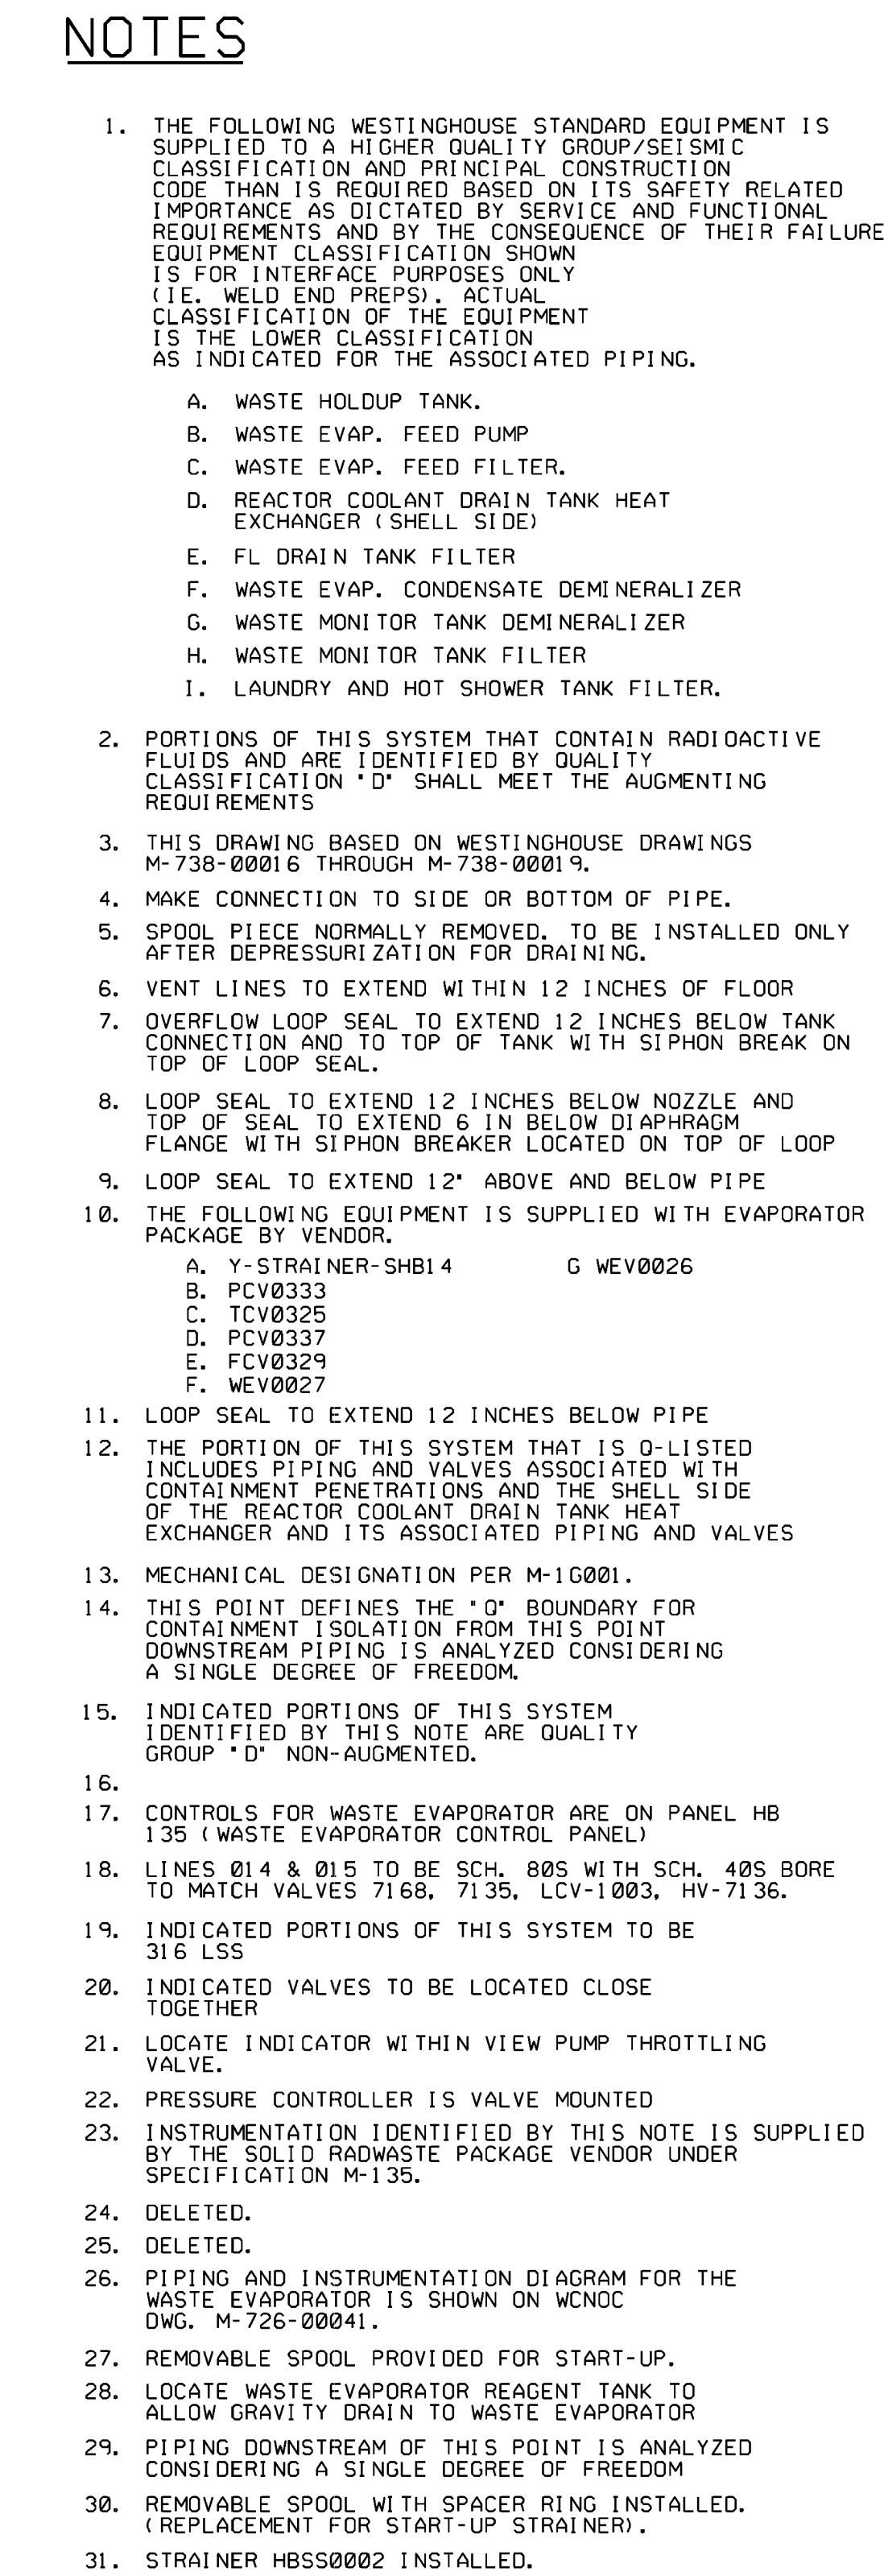

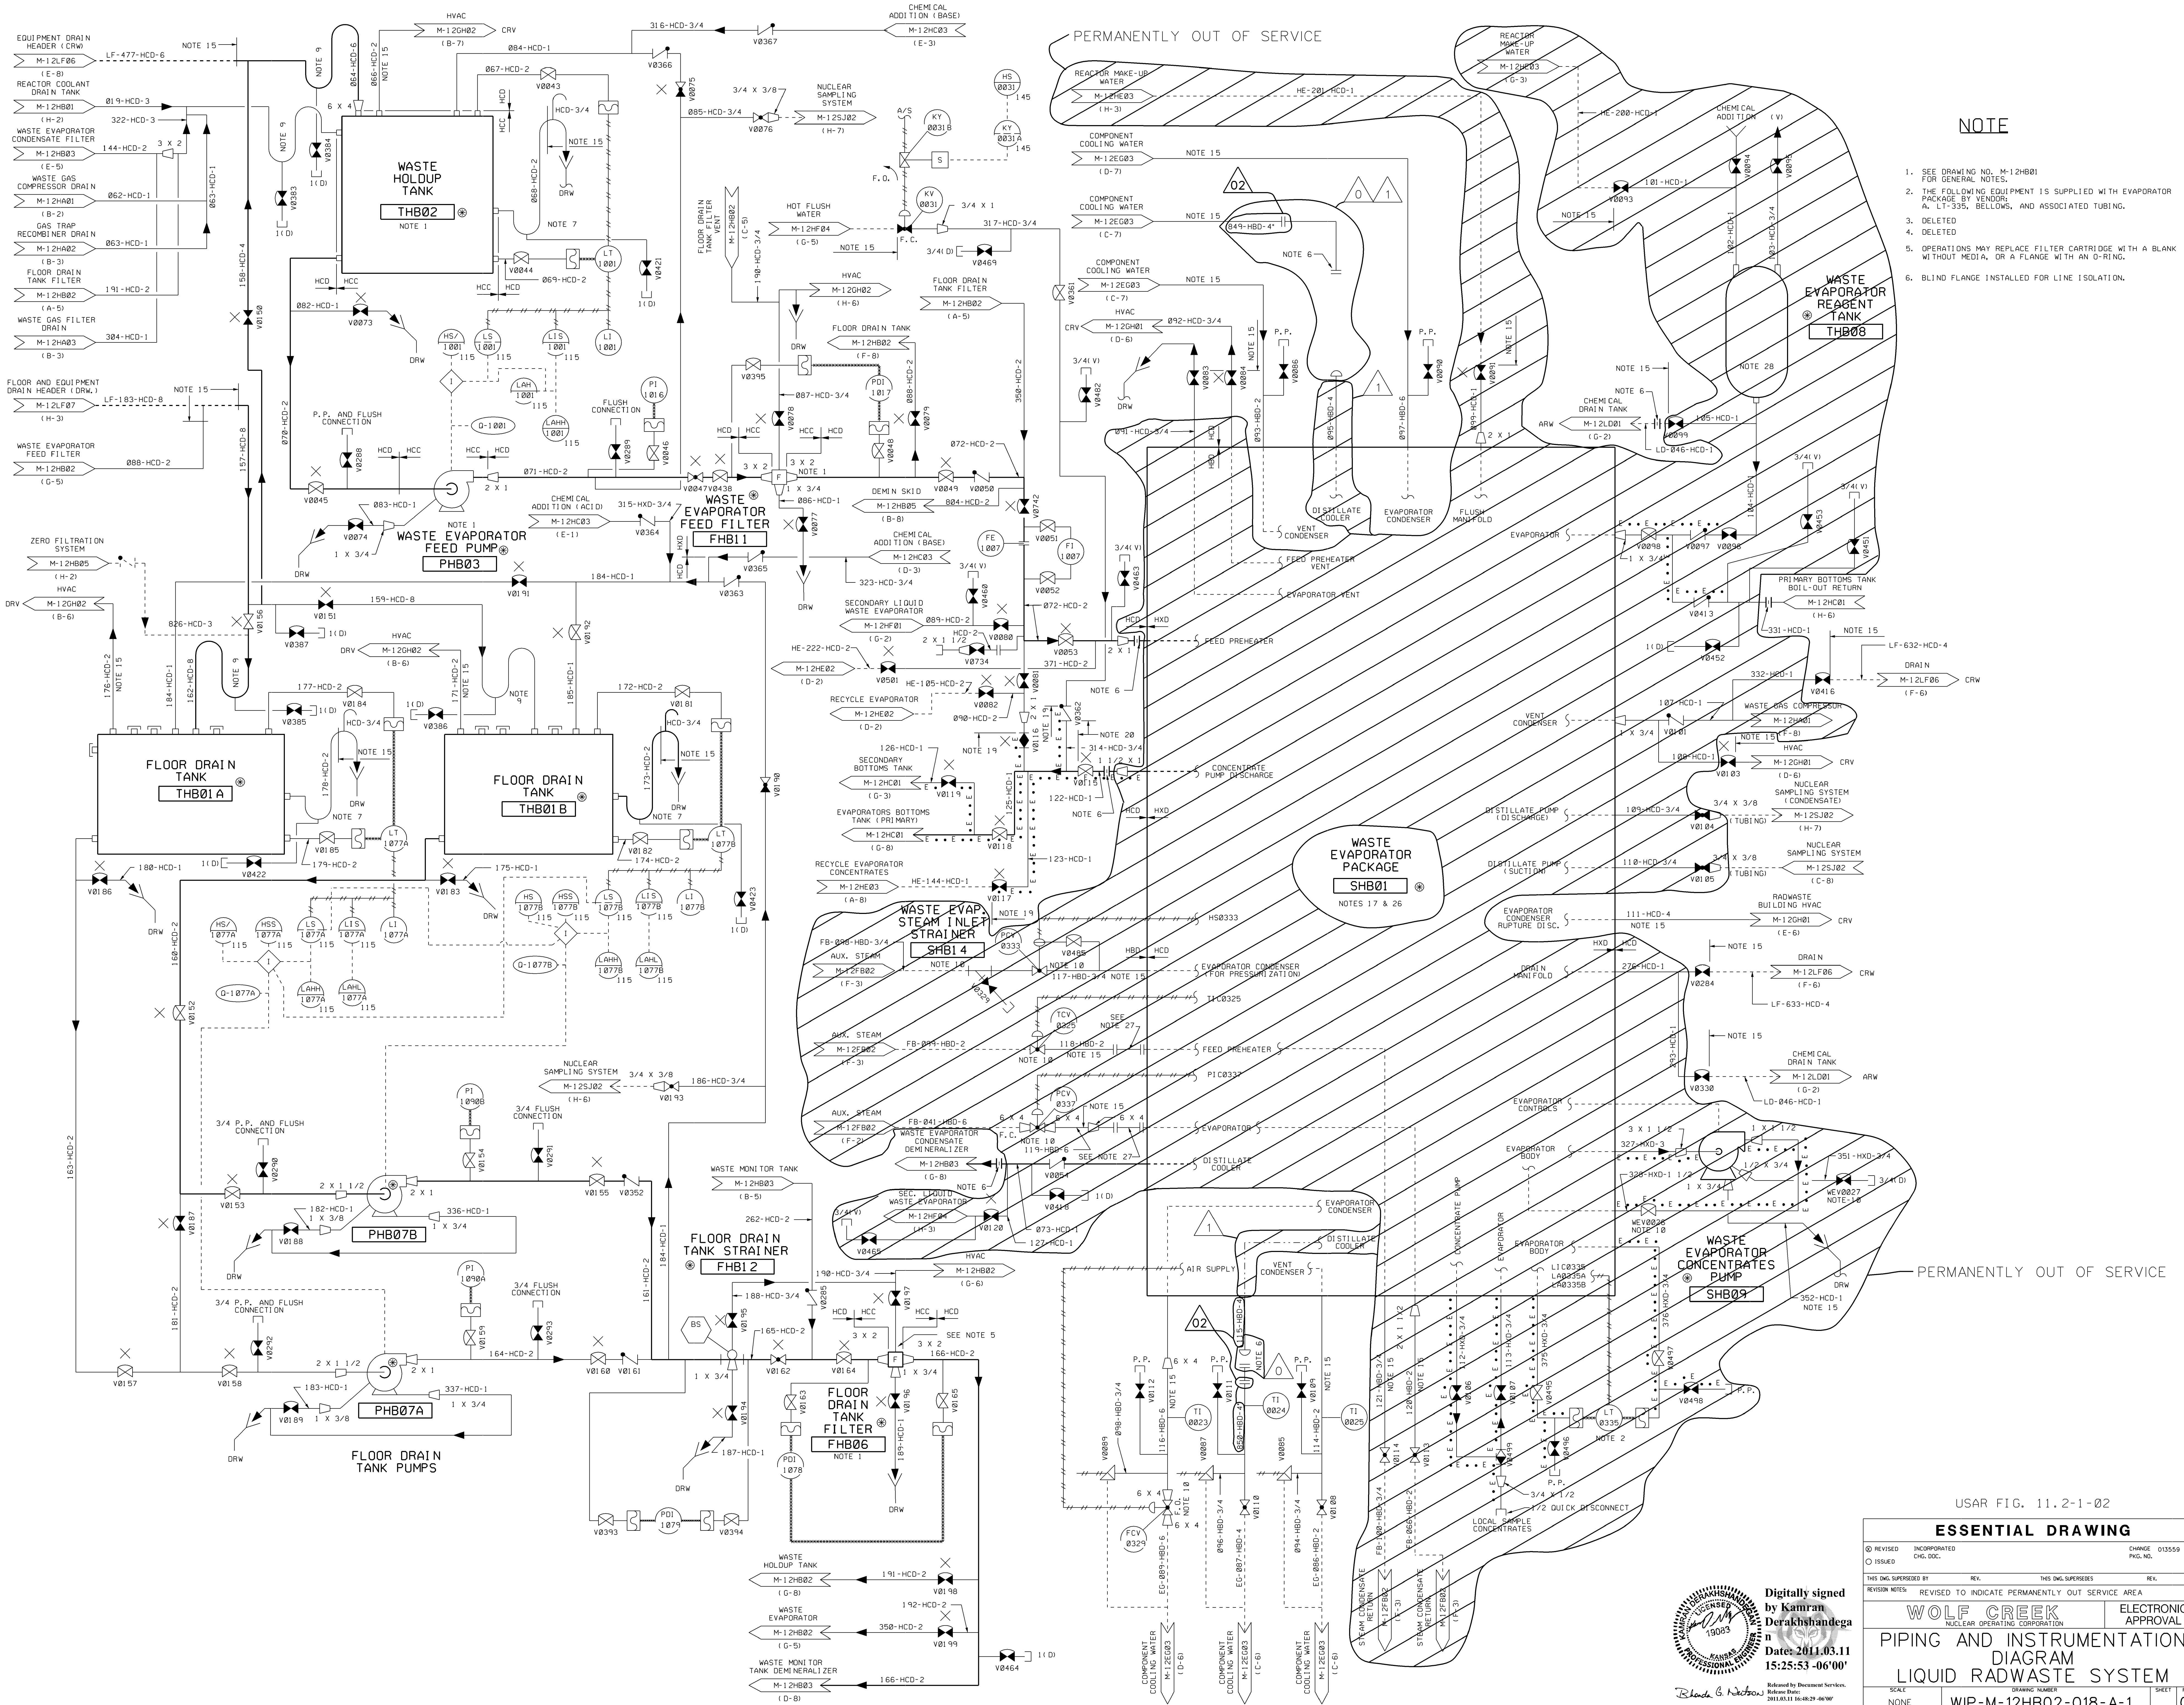

NOTE


1. SEE DRAWING NO. M-12HB01 FOR GENERAL NOTES.
2. THE FOLLOWING EQUIPMENT IS SUPPLIED WITH EVAPORATOR PACKAGE BY VENDOR:
A. LT-335, BELLOWS, AND ASSOCIATED TUBING.
3. DELETED
4. DELETED
5. OPERATIONS MAY REPLACE FILTER CARTRIDGE WITH A BLANK WITHOUT MEDIA, OR A FLANGE WITH AN O-RING.
6. BLIND FLANGE INSTALLED FOR LINE ISOLATION.

USAR FIG. 11.2-1-02


ESSENTIAL DRAWING

REVISION	INCORPORATED	CHANGE	013559
ISSUED	CHG. DOC.	PAGE NO.	
THIS Dwg. SUPERSEDES	REV.	THIS Dwg. SUPERSEDES	REV.
REVISION NOTES	REVISED TO INDICATE PERMANENTLY OUT SERVICE AREA		
WOLF CREEK		ELECTRONIC APPROVAL	
NUCLEAR OPERATING CORPORATION			
PIPING AND INSTRUMENTATION		DIAGRAM	
LIQUID RADWASTE SYSTEM			
SCALE	DRAWING NUMBER	SHEET	REV
NONE	WIP-M-12HB02-018-A-1	02	

Digitally signed by Kamran Derakhshandegani
Date: 2011.03.11 15:25:53 -06'00'

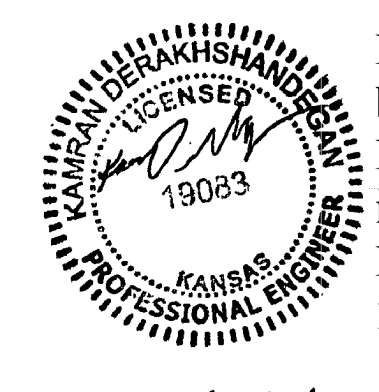

Released by Document Services
2011.03.11 16:48:29 -06'00'

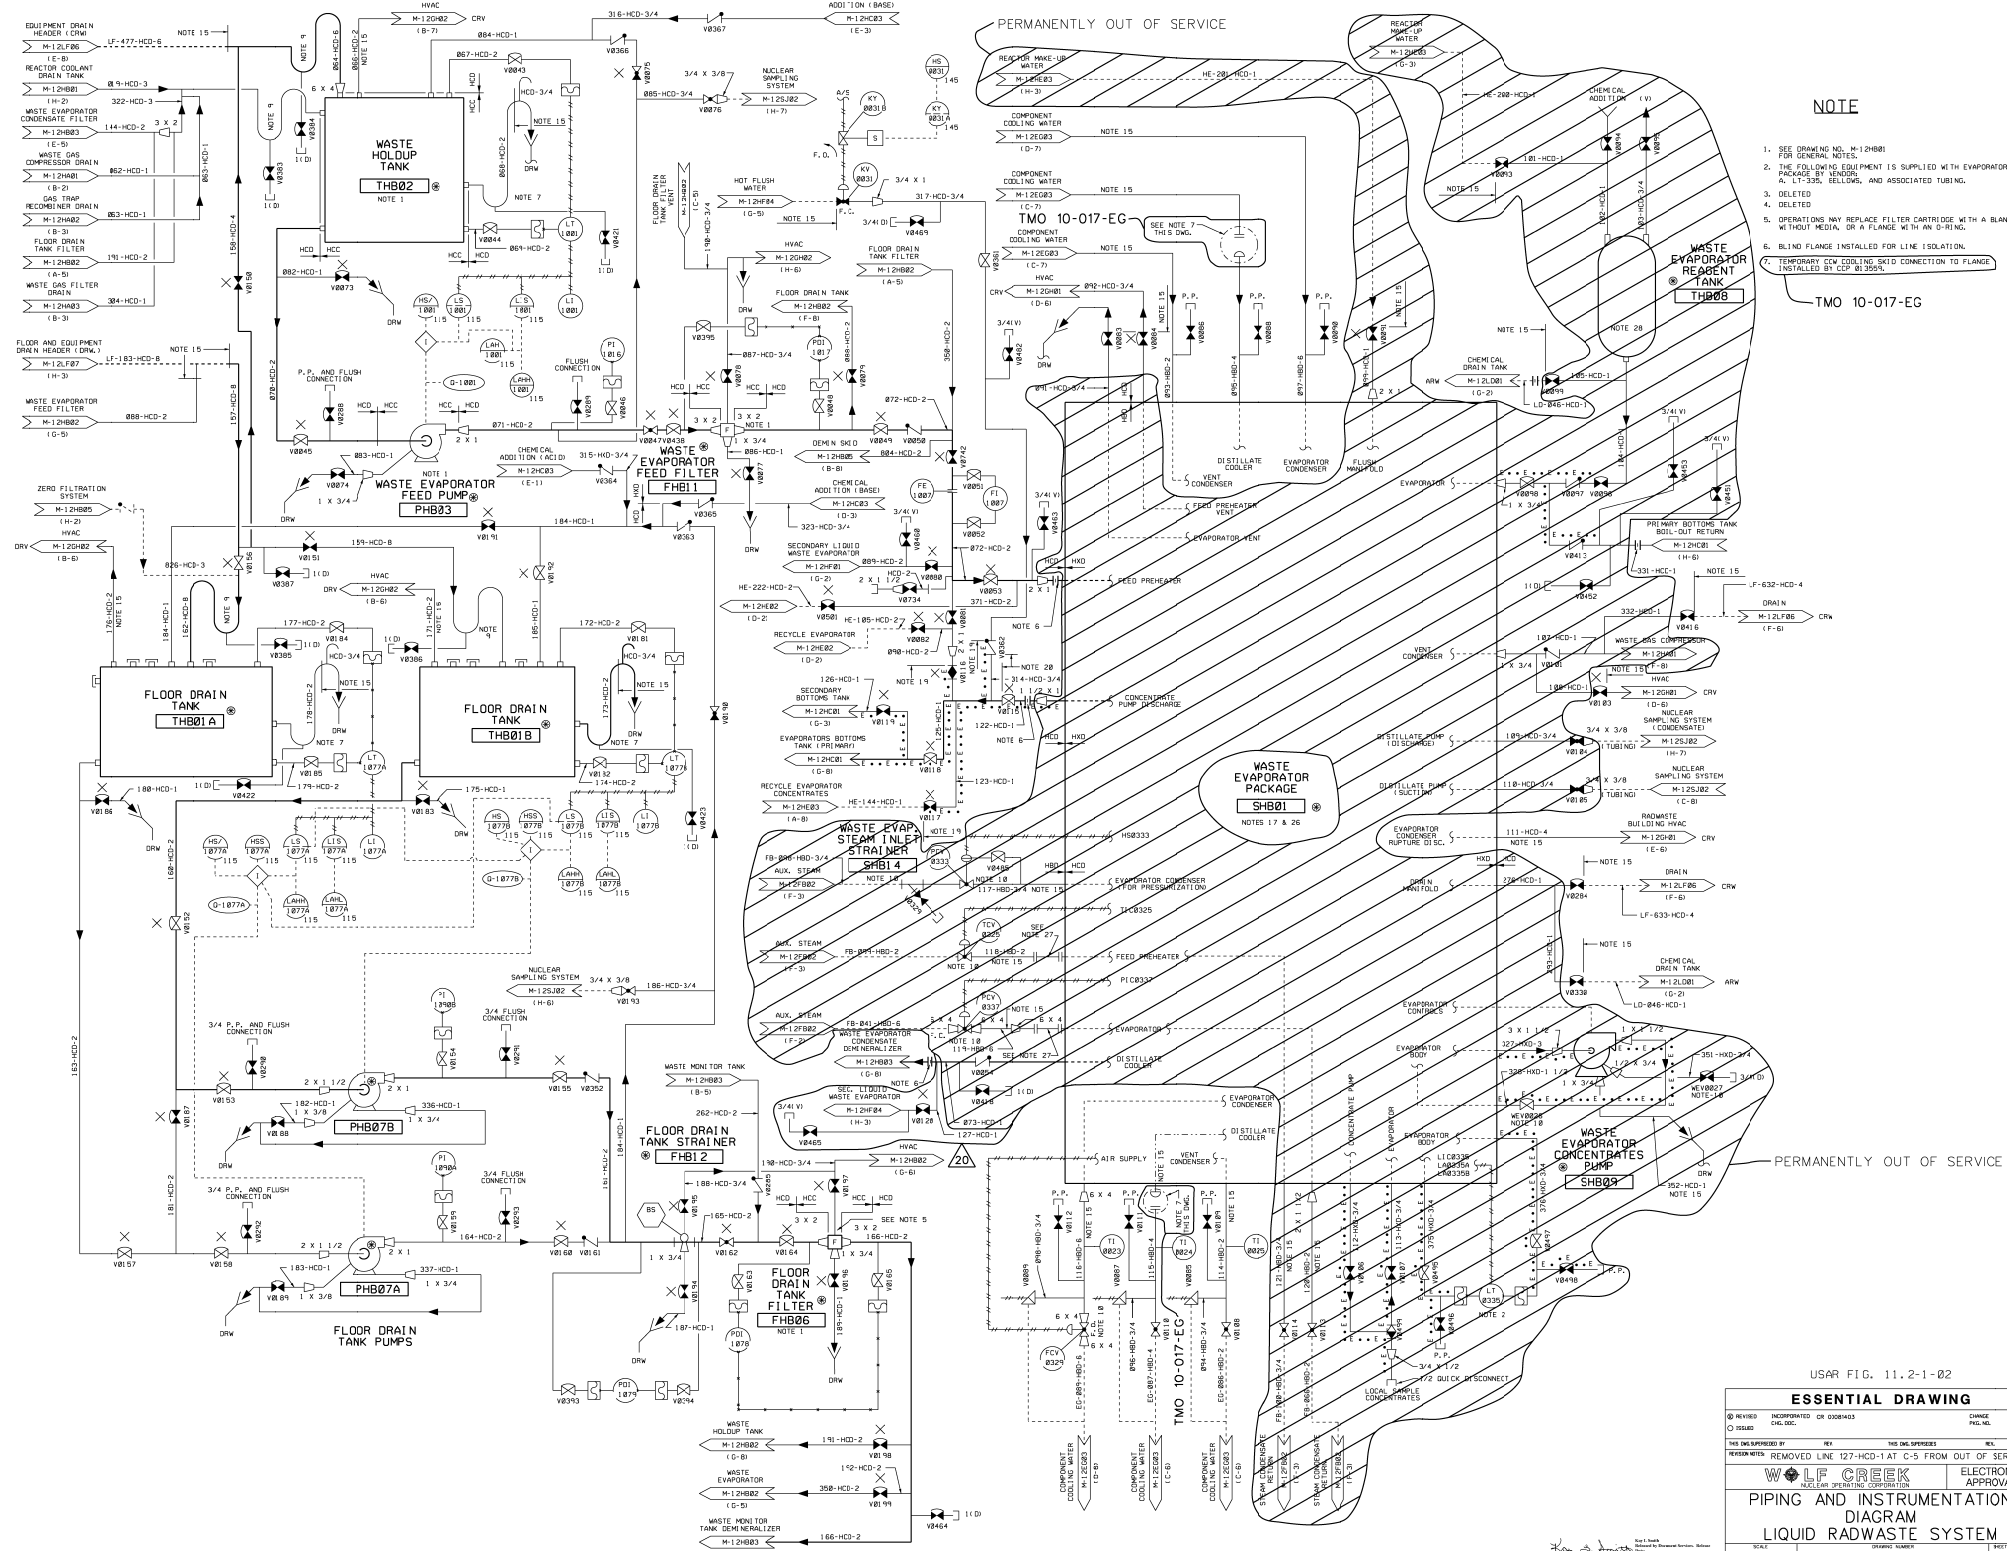

NOTE

1. SEE DRAWING NO. M-12H81 FOR GENERAL NOTES.
2. THE FOLLOWING EQUIPMENT IS SUPPLIED WITH EVAPORATOR PACKAGE BY VENDORS:
A. L-1-335, BELLING, AND ASSOCIATED TUBING.
3. DELETED
4. DELETED
5. OPERATIONS MAY REPLACE FILTER CARTRIDGE WITH A BLANK M-12H01 MEDIA OR A FLANGE WITH AN O-RING.
6. BLIND FLANGE INSTALLED FOR LINE ISOLATION.
7. TEMPORARY COOLING SKID CONNECTION TO FLANGE INSTALLED BY CCP #1359.

TMO 10-017-EG

USAR FIG. 11.2-1-02

ESSENTIAL DRAWING


REVISIONS: 1. REVISED: 11/11/83 BY: 11/11/83
2. REVISED: 11/11/83 BY: 11/11/83
3. REVISED: 11/11/83 BY: 11/11/83
4. REVISED: 11/11/83 BY: 11/11/83
100. REVISED: 11/11/83 BY: 11/11/83

WOLF CREEK
NUCLEAR SPRING CORPORATION

ELECTRONIC APPROVAL


PIPING AND INSTRUMENTATION
DIAGRAM
LIQUID RADWASTE SYSTEM

M-12H802
SHEET 20

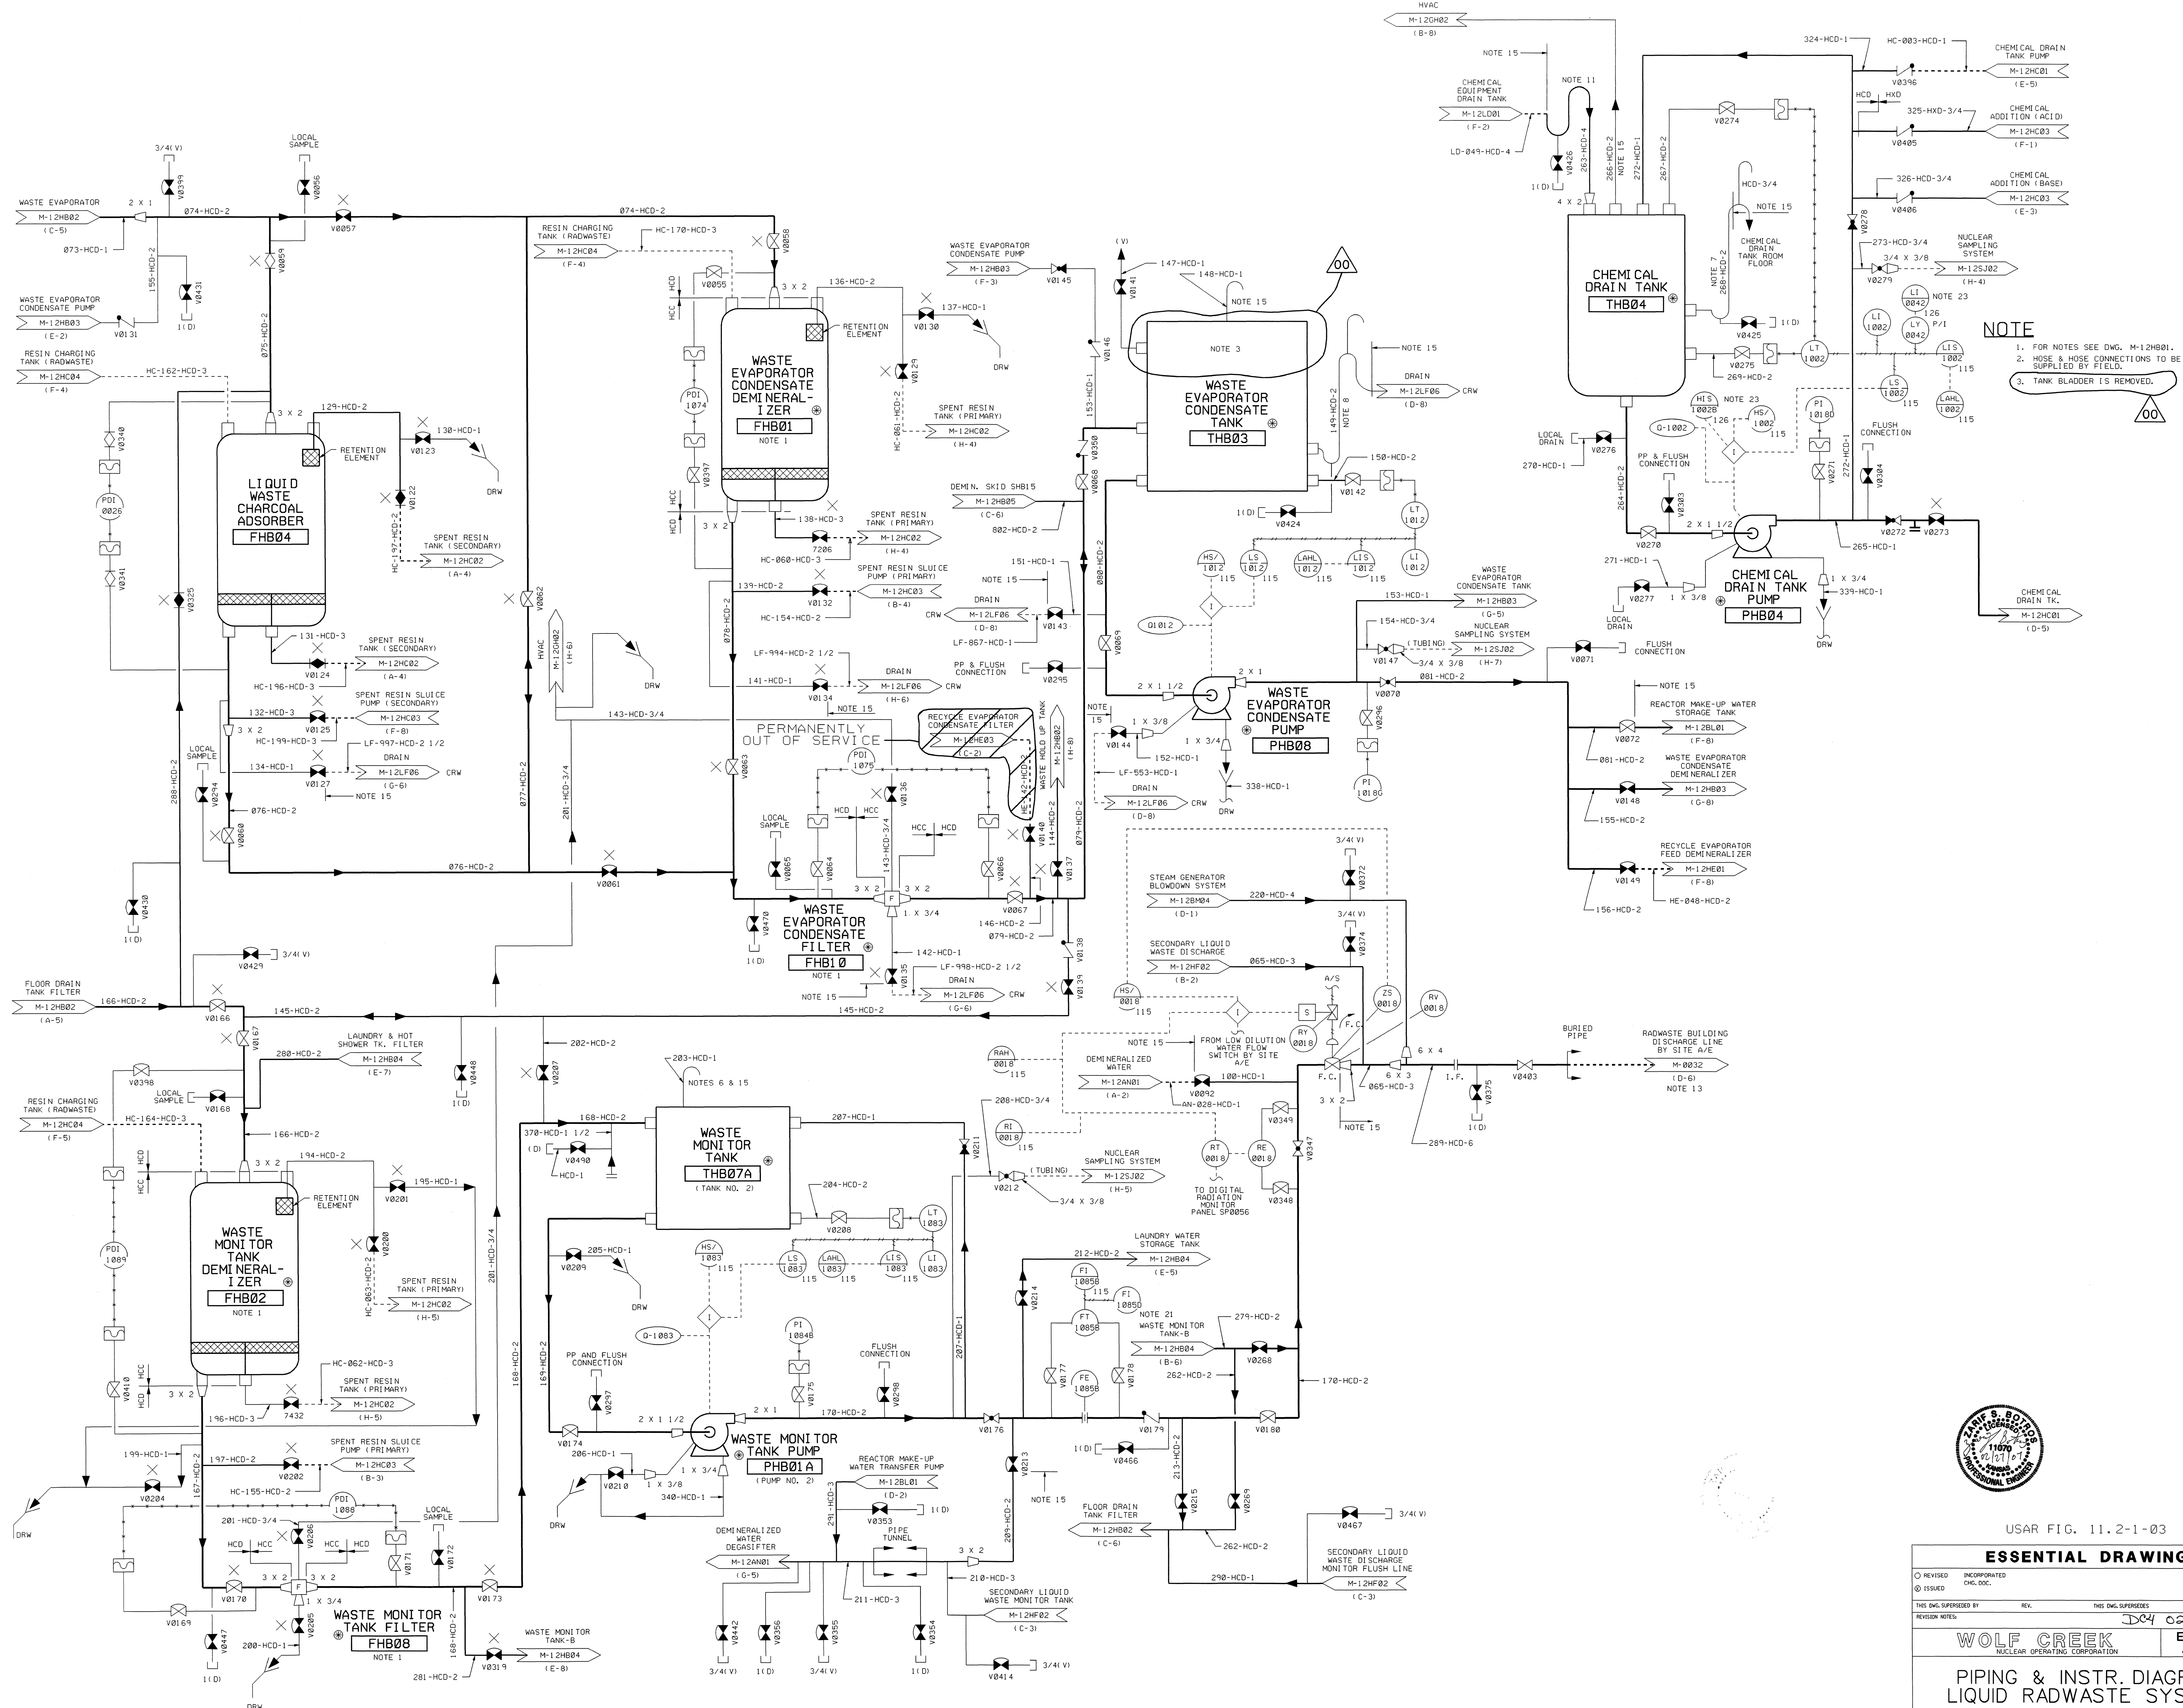

NOTES

- SEE DRAWING NUMBER M-721-00015.
- QUALITY GROUP "D" PORTIONS OF THIS SYSTEM (NOT IDENTIFIED BY NOTE 8) SHALL MEET THE AUGMENTING REQUIREMENTS.
- THIS DRAWING BASED ON WESTINGHOUSE DRAWINGS M-730-00025 THROUGH M-730-00027.
- THE FOLLOWING WESTINGHOUSE STANDARD EQUIPMENT IS SUPPLIED TO A HIGHER QUALITY GROUP/SEISMIC CLASSIFICATION AND PRINCIPLE CONSTRUCTION CODE THAN IS REQUIRED BASED ON IT'S SAFETY RELATED IMPORTANCE AS DICTATED BY SERVICE AND FUNCTIONAL REQUIREMENTS AND BY THE CONSEQUENCE OF THEIR FAILURE. EQUIPMENT CLASSIFICATION SHOWN IS FOR INTERFACE PURPOSES ONLY (I.E. WELD END PRESS). ACTUAL CLASSIFICATION OF THE EQUIPMENT IS THE LOWER CLASSIFICATION AS INDICATED FOR THE ASSOCIATED PIPING.
- A. GAS DECAY TANKS
B. WASTE GAS DRAIN FILTER
- SEE DRAWING NUMBER M-725-00013.
- OXYGEN PRESSURE REGULATOR, PRESSURE INDICATORS, AND PRESSURE SWITCH, ARE PROVIDED UNDER M.R. 10486-M-139. PRESSURE SWITCH ISOLATION VALVE, RELIEF VALVE, AND ORIFICE UNION ARE PROVIDED AS PART OF THE WESTINGHOUSE RECOMBINER PACKAGE (M-725-00013).
- IDENTIFIED PORTIONS OF THE GASEOUS RADWASTE SYSTEM ARE ANALYZED CONSIDERING A SINGLE DEGREE OF FREEDOM.
- INDICATED PORTIONS OF THIS SYSTEM, IDENTIFIED BY THIS NOTE ARE QUALITY GROUP "D" NON-AUGMENTED.
- SEE INSTRUMENTATION DRAWING J-970100-01 INSTRUMENT PIPING CLASS SPECIFICATION.
- USING JOINTS FOR INSTRUMENTS OFF PIPING COVERED BY NOTE 7 SHALL BE SEAL WELDED.
- THIS INDICATING SWITCH IS REQUIRED FOR INDICATION ONLY.
- VALVE TO BE SET TO RELIEVE AT 80 PSIG $\pm$ 10 PSIG.
- FLANGES HAVE BEEN INSTALLED UPSTREAM AND DOWNSTREAM OF DRAIN TRAPS (FHA02 AND FHA03) TO FACILITATE REMOVAL FOR MAINTENANCE.
- DELETED.
- ABANDONED IN PLACE.
- IF BOTH INLET AND OUTLET HEAT EXCHANGER VALVES ARE CLOSED THEN OPEN AT LEAST ONE OF THE PP OR VENT VALVES IN-BETWEEN THEM TO RELIEVE ANY POSSIBLE THERMAL EXPANSION.

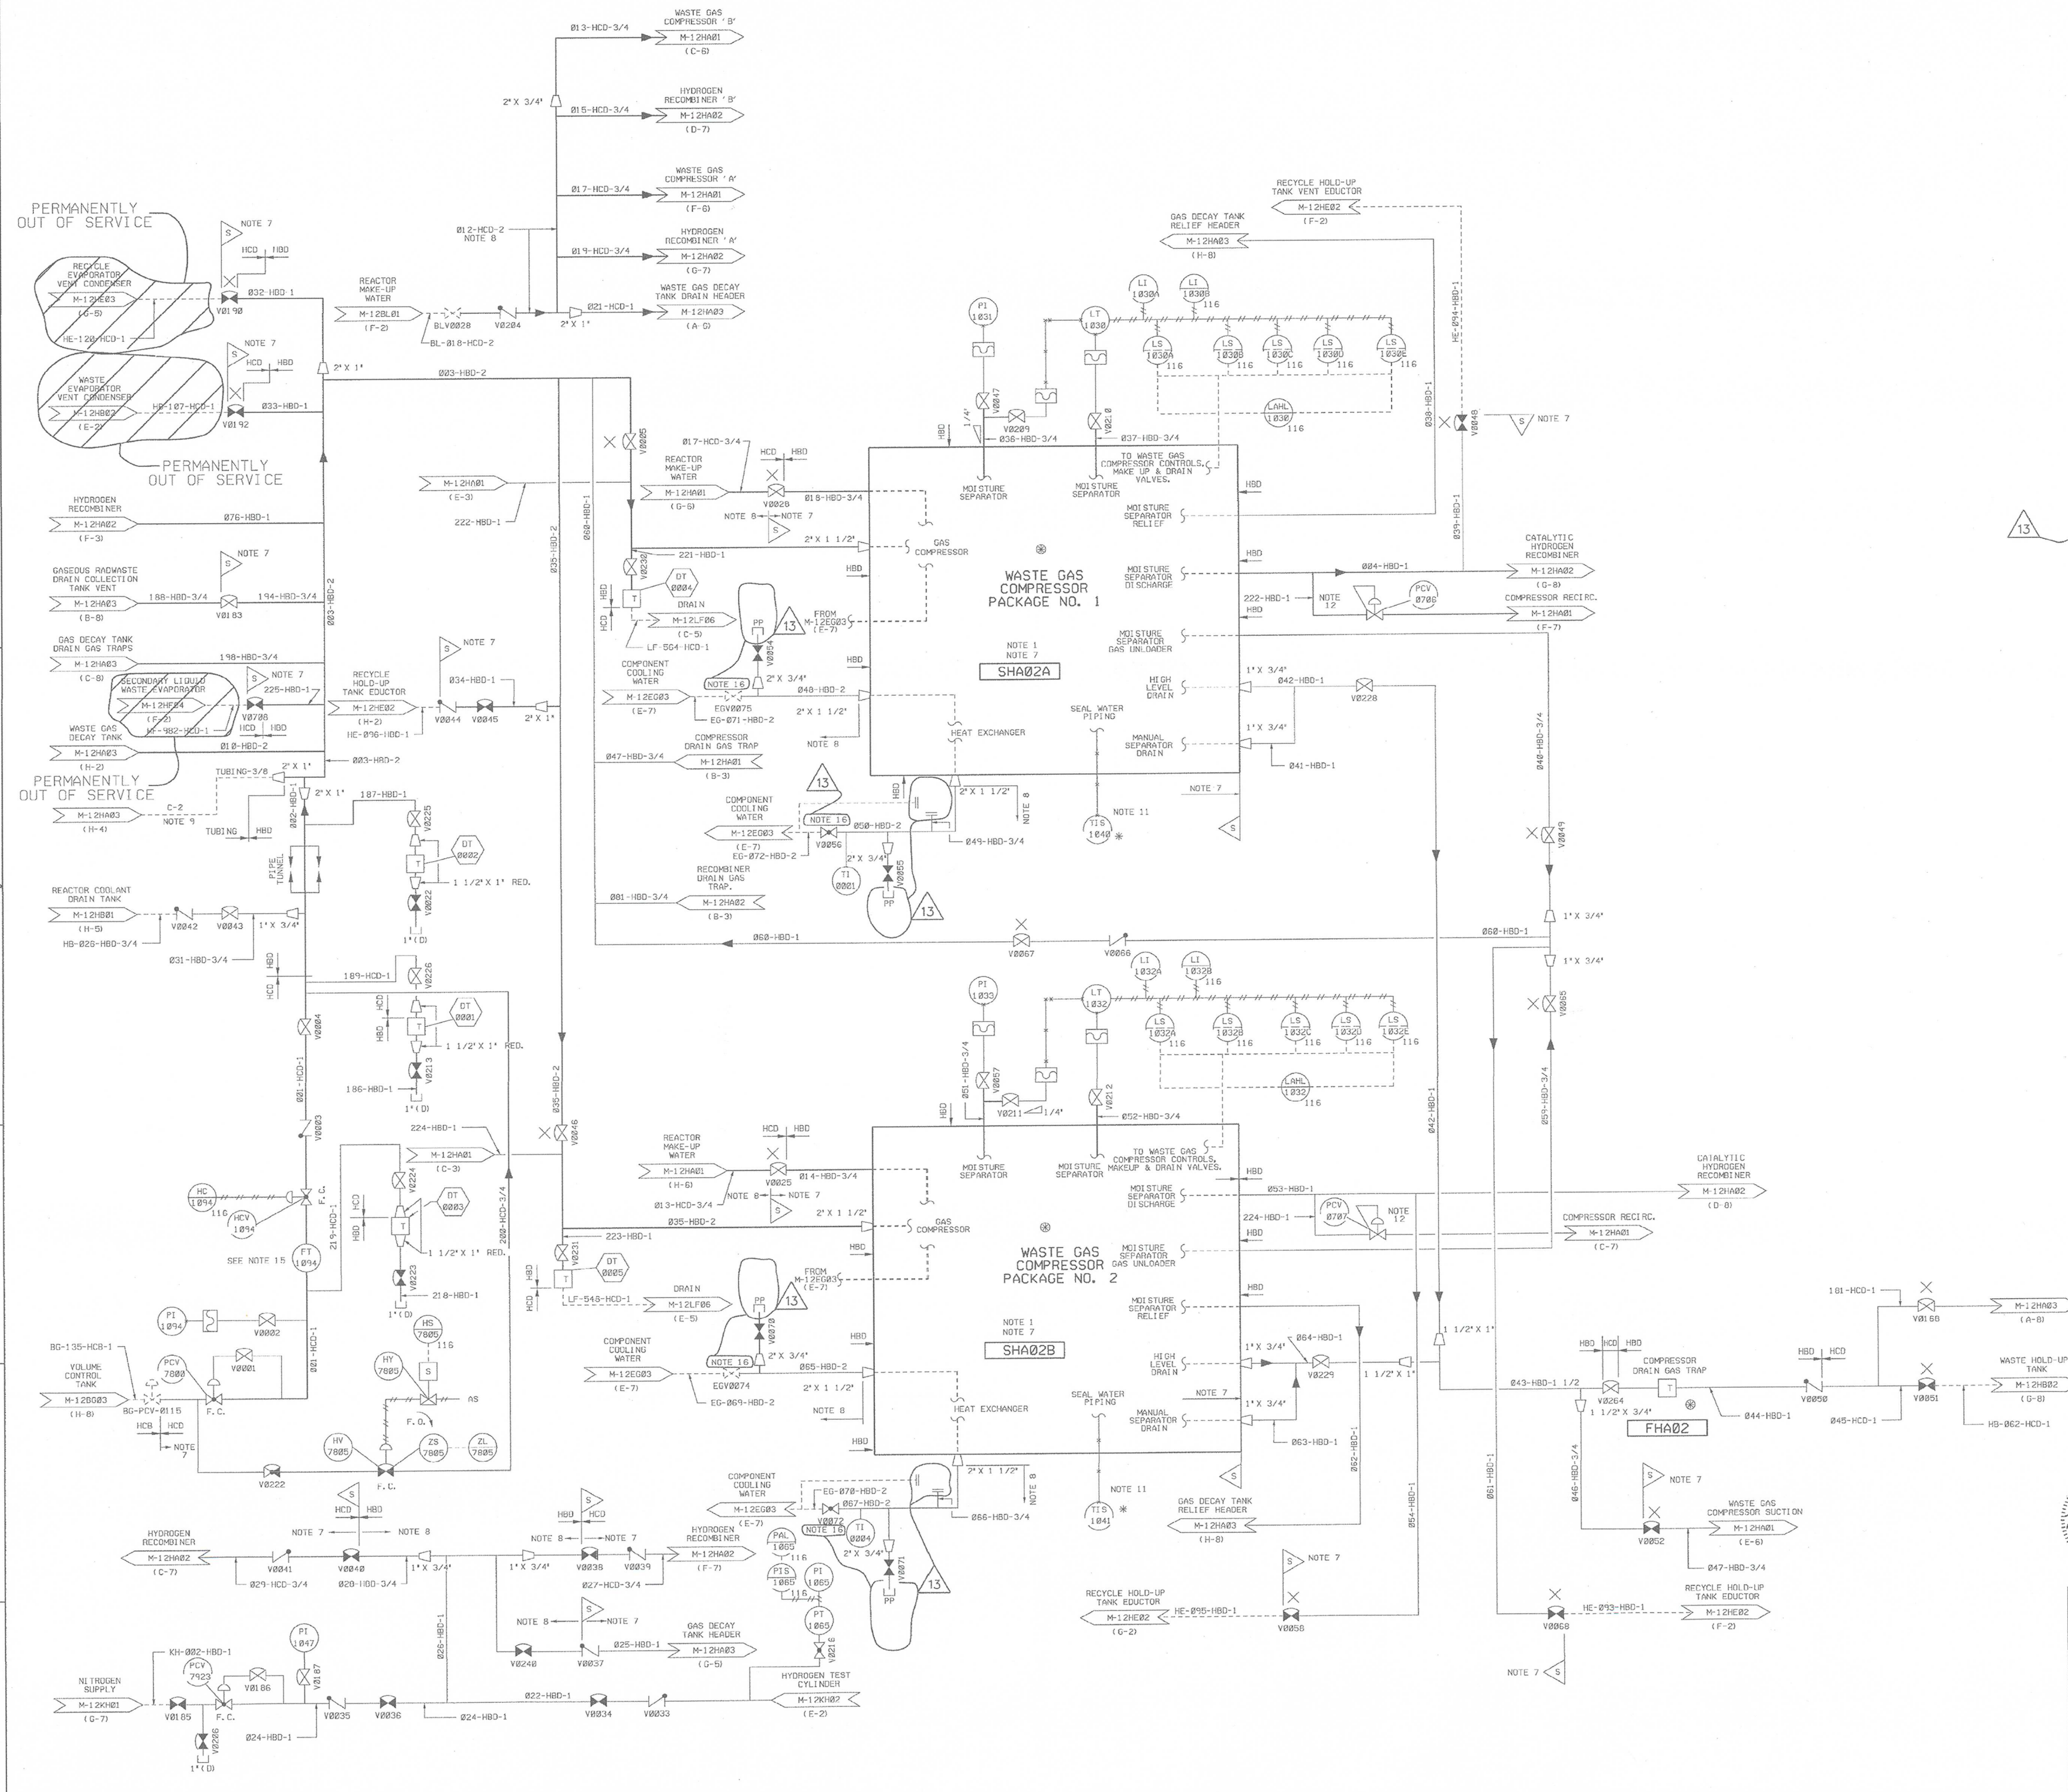


USAR FIG. 11.3-1-01

ESSENTIAL DRAWING

④ REVISION	INCORPORATED CHG. DOC.	CHANGE PCLG. NO.	01/15/15
THIS Dwg. SUPERSEDES	REV.	THIS Dwg. SUPERSEDES	REV.
REVISION NOTES	REMOVED TMO 10-17-EG-5	104 01-27-15	
WOLF CREEK NUCLEAR OPERATING CORPORATION			ELECTRONIC APPROVAL
PIPING & INSTRUMENTATION DIAGRAM GASEOUS RADWASTE SYSTEM			
SCALE NONE	DRAWING NUMBER M-12HA01		SHEET 1

NOTES

- FOR GENERAL NOTES, SEE DWG. M-12HA01.
- GAS SUPPLY SHALL BE ESTABLISHED IN THE FOLLOWING LINES 027-HCD-3/4, 029-HCD-3/4, AND 087-HCD-3/4 PRIOR TO THE OPENING OF VALVES V0235, V0237, AND V0238.
- DELETED
- VALVES PCV-62, PCV-63, AND PCV-64 TO REGULATE PRESSURE TO THE GAS ANALYZER RACK AT 25 PSIG.
- LOCATE CHECK VALVES AS CLOSE AS POSSIBLE TO GAS ANALYZER RACKS (HA0161 & HA0162).
- IF BOTH INLET AND OUTLET HEAT EXCHANGER VALVES ARE CLOSED THEN OPEN AT LEAST ONE OF THE PP OR VENT VALVES IN-BETWEEN THEM TO RELIEVE ANY POSSIBLE THERMAL EXPANSION.

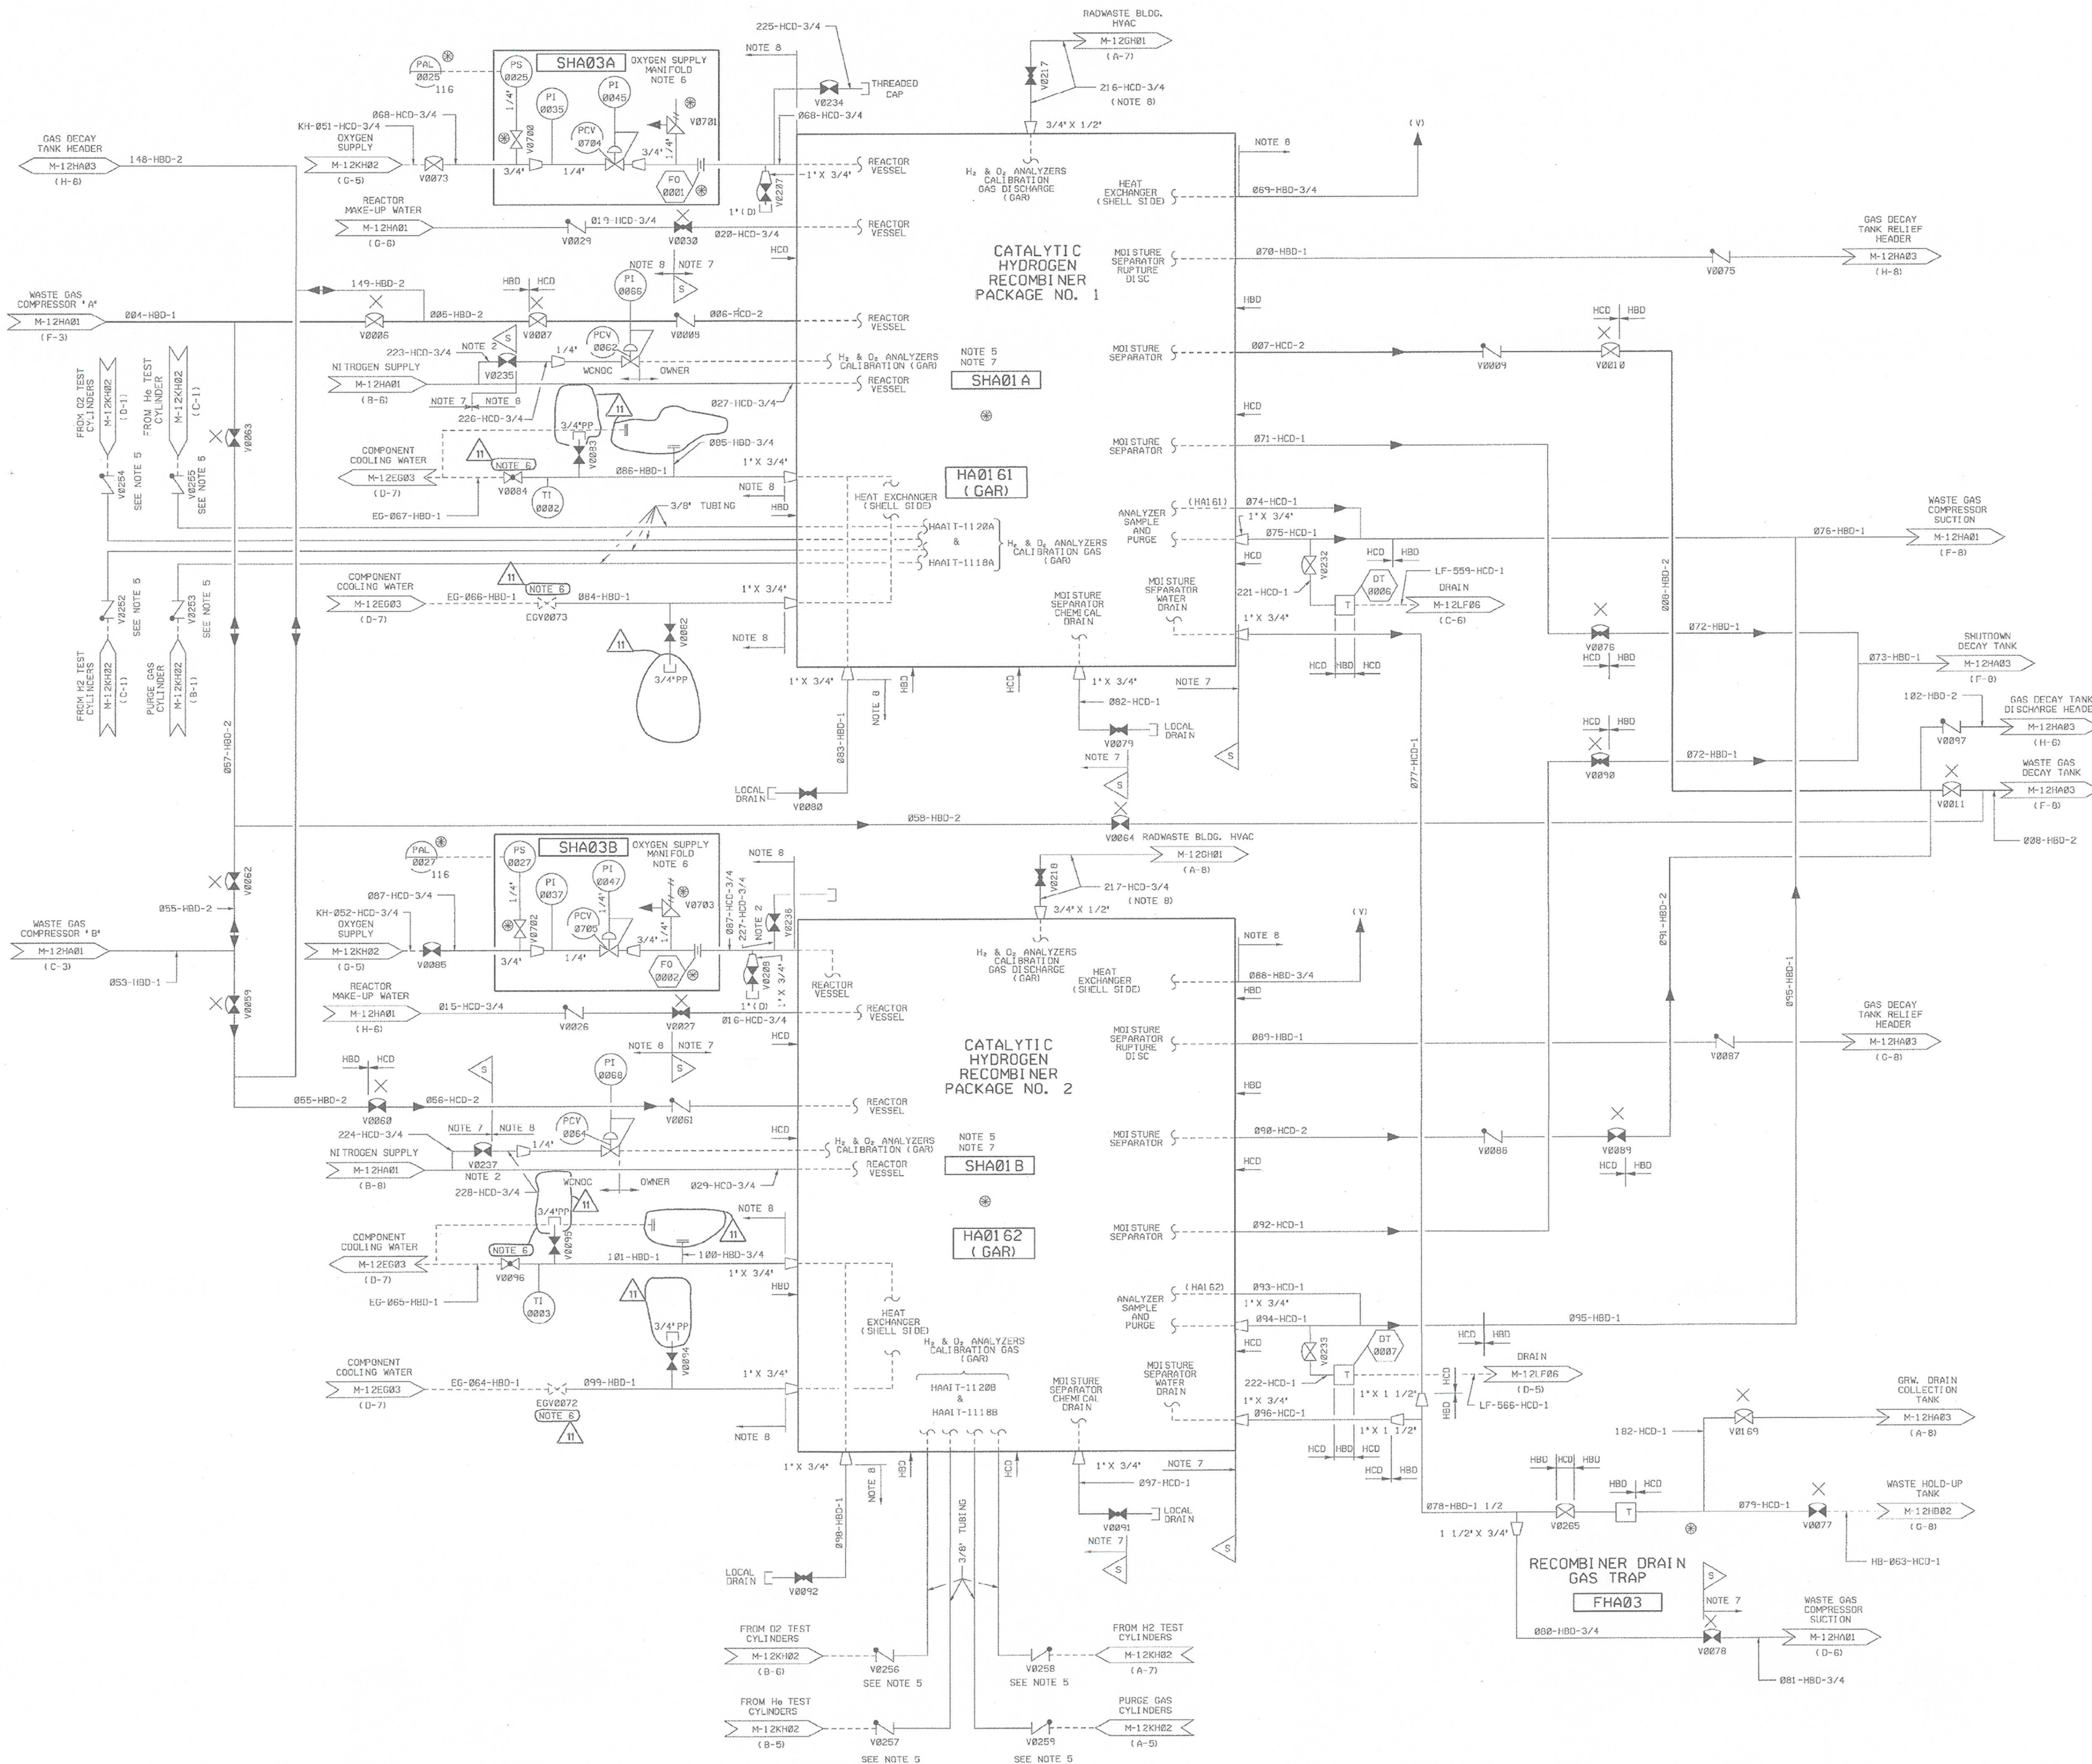


USAR FIG. 11.3-1-02

ESSENTIAL DRAWING

REVISION	INCORPORATED CIV. DOC.	CHANGE PKG. NO.	014803			
ISSUED						
THIS DWG. SUPERSEDED BY		REV.	THIS DWG. SUPERSEDES	REV.		
REVISION NOTES		REMOVED TWO 10-17-EG-5		DC4 01-27-15		
WOLF CREEK NUCLEAR OPERATING CORPORATION			ELECTRONIC APPROVAL			
PIPING & INSTRUMENTATION DIAGRAM						
GASEOUS RADWASTE SYSTEM						
SCALE	DRAWING NUMBER				SHEET	REV
N.T.S.	M-12HA02					11



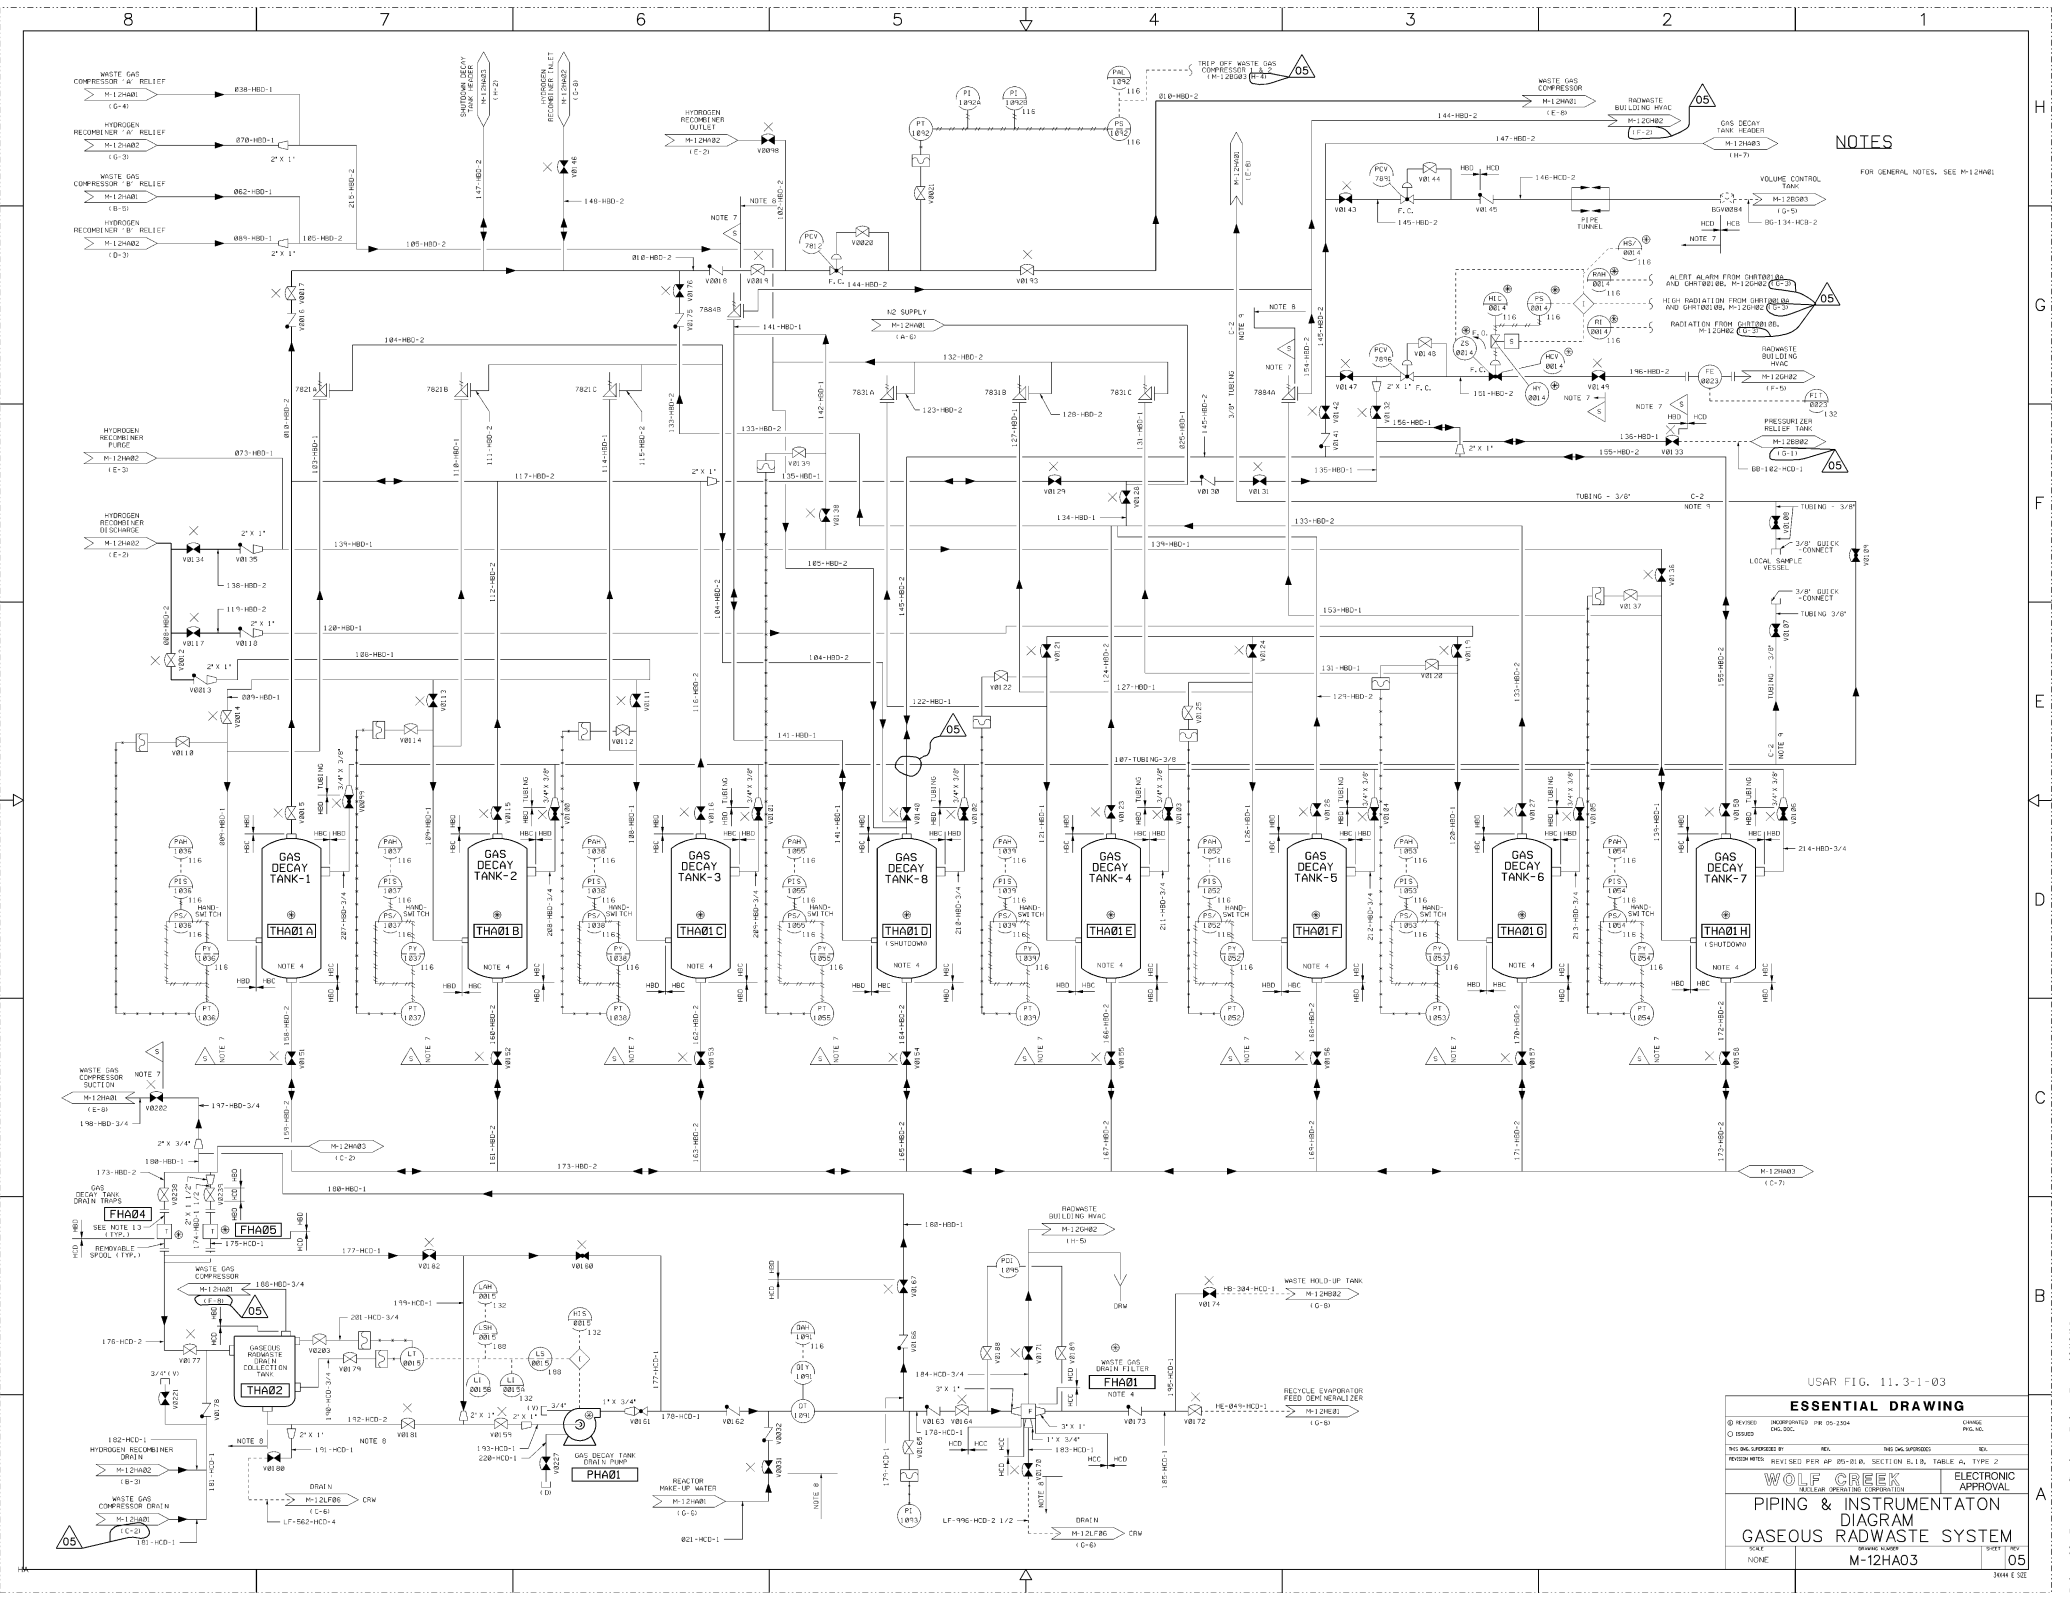

NOTES

FOR GENERAL NOTES, SEE M-12HAB

USAR FIG. 11.3-1-03

ESSENTIAL DRAWING


DESIGNED BY	REVISED BY	DATE	BY	DATE
WOLF CREEK	WOLF CREEK	11/3/03	WOLF CREEK	11/3/03

WOLF CREEK
PACIFIC NORTHWEST LABORATORY


PIPING & INSTRUMENTATION
DIAGRAM
GASEOUS RADWASTE SYSTEM

M-12HA03

05

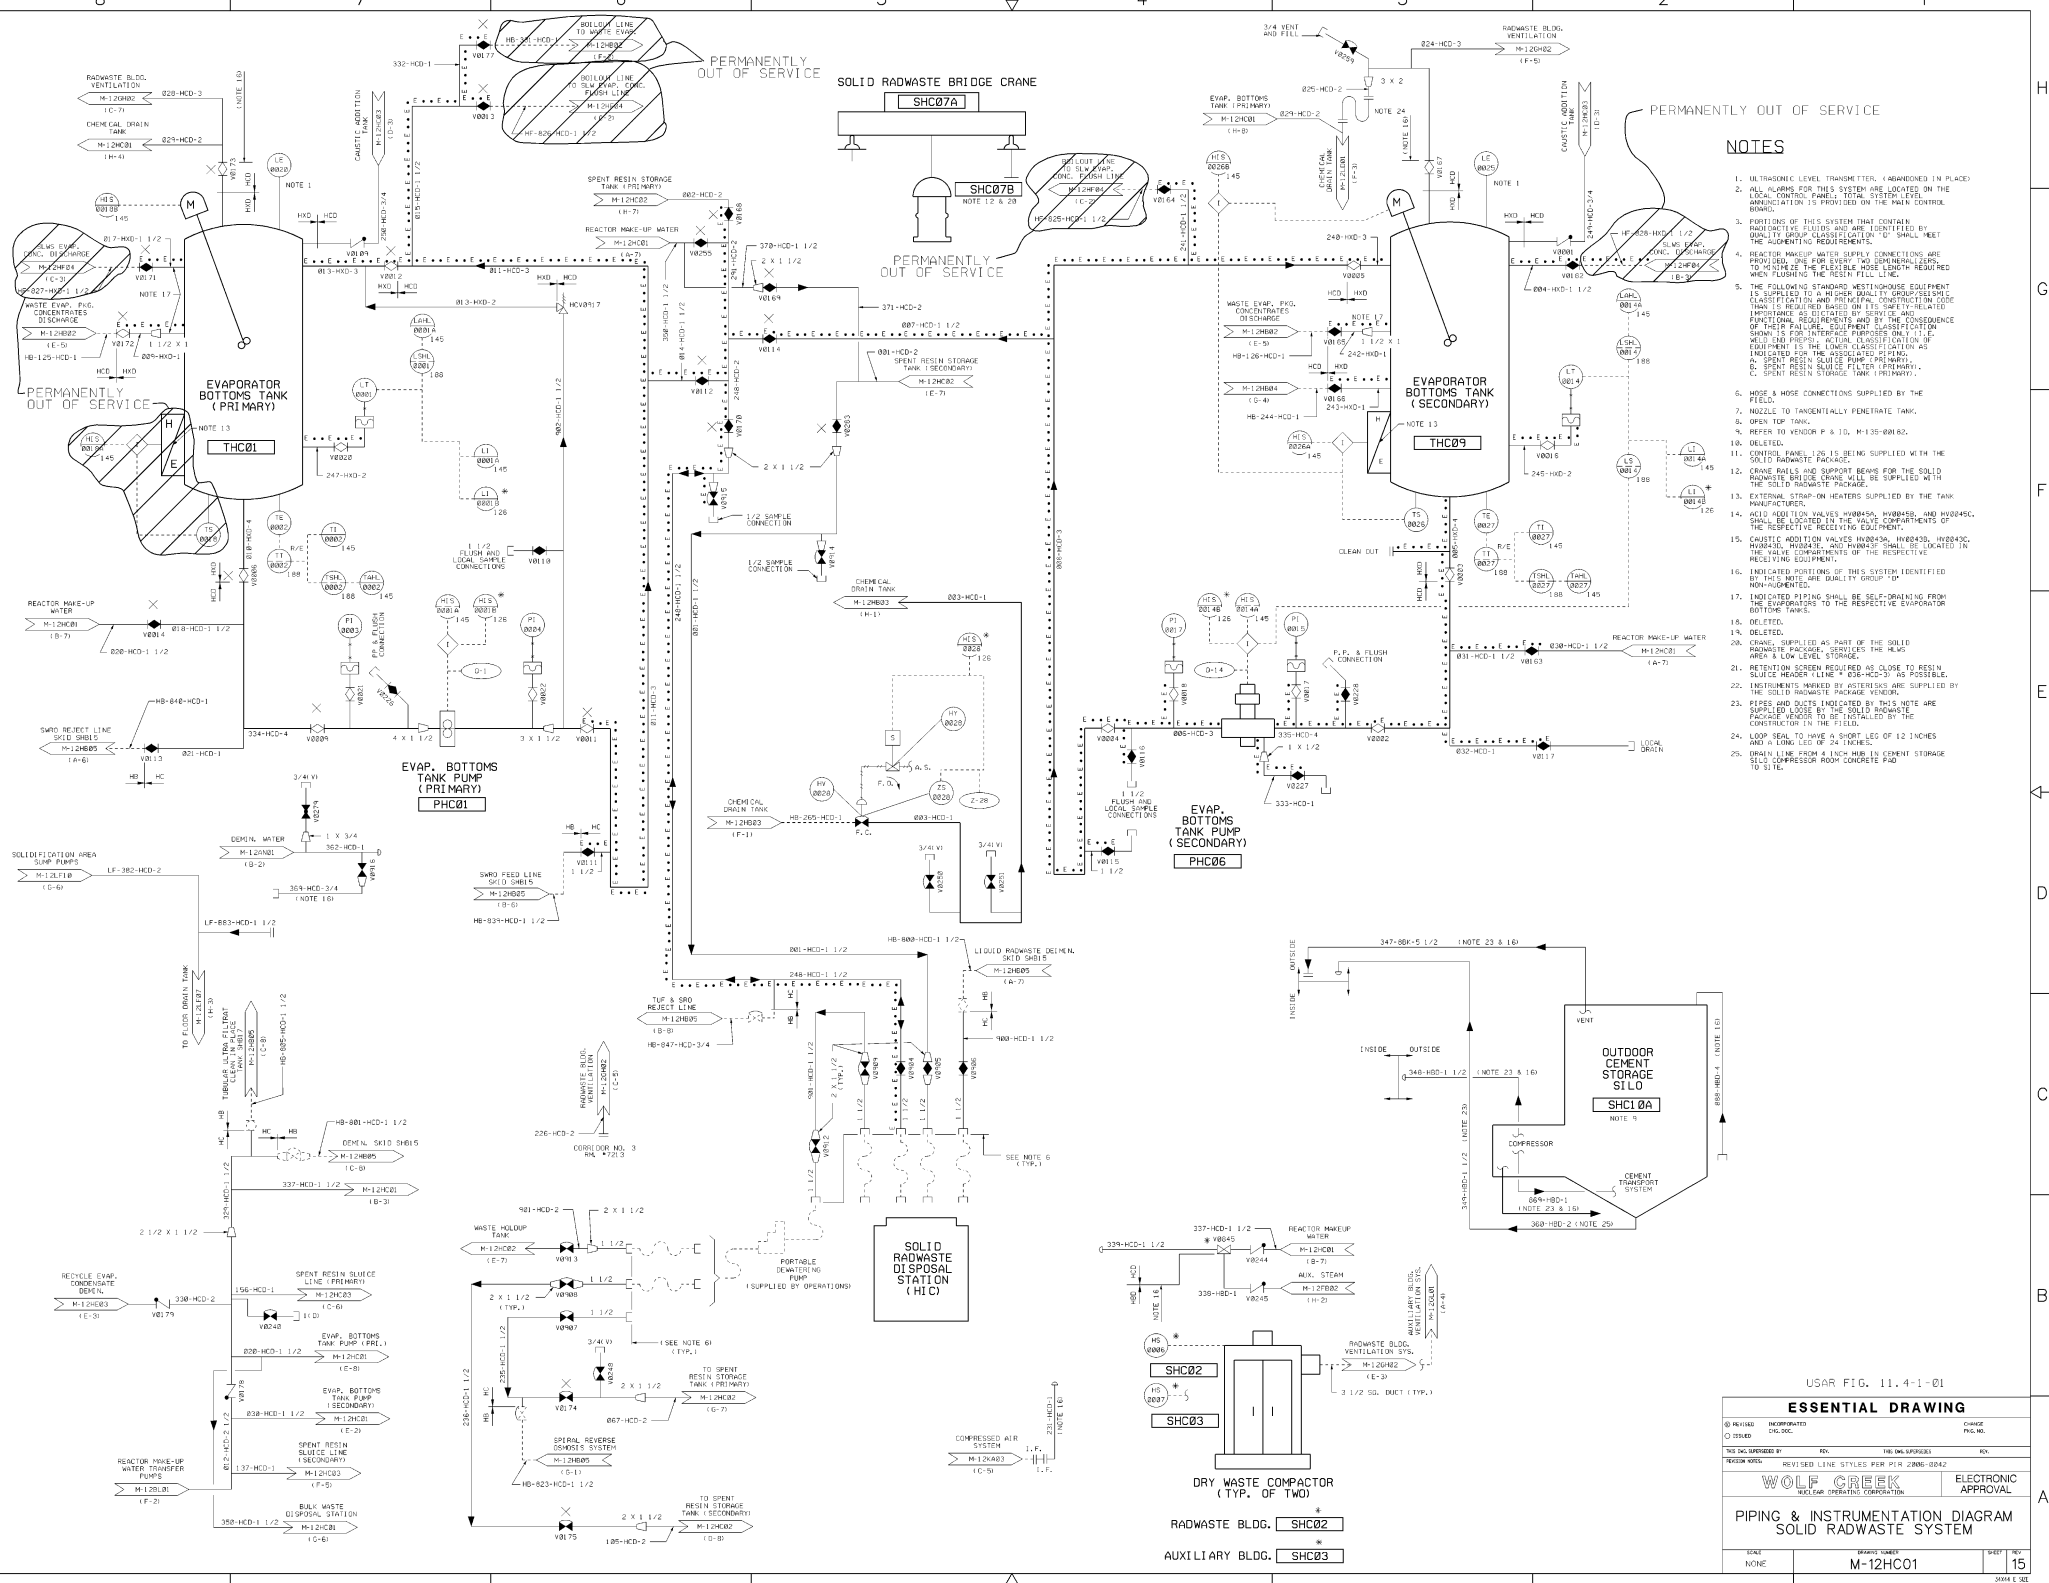

USAR FIG. 11.4-1-01			
ESSENTIAL DRAWING			
REVISION	DATE	BY	CHKD
1	11/1/81	WOLF CREEK	WOLF CREEK
WOLF CREEK			
ELECTRONIC APPROVAL			
PIPING & INSTRUMENTATION DIAGRAM			
SOLID RADWASTE SYSTEM			
TITLE	NO.	REV.	REV.
NONE	M-12HC01		15

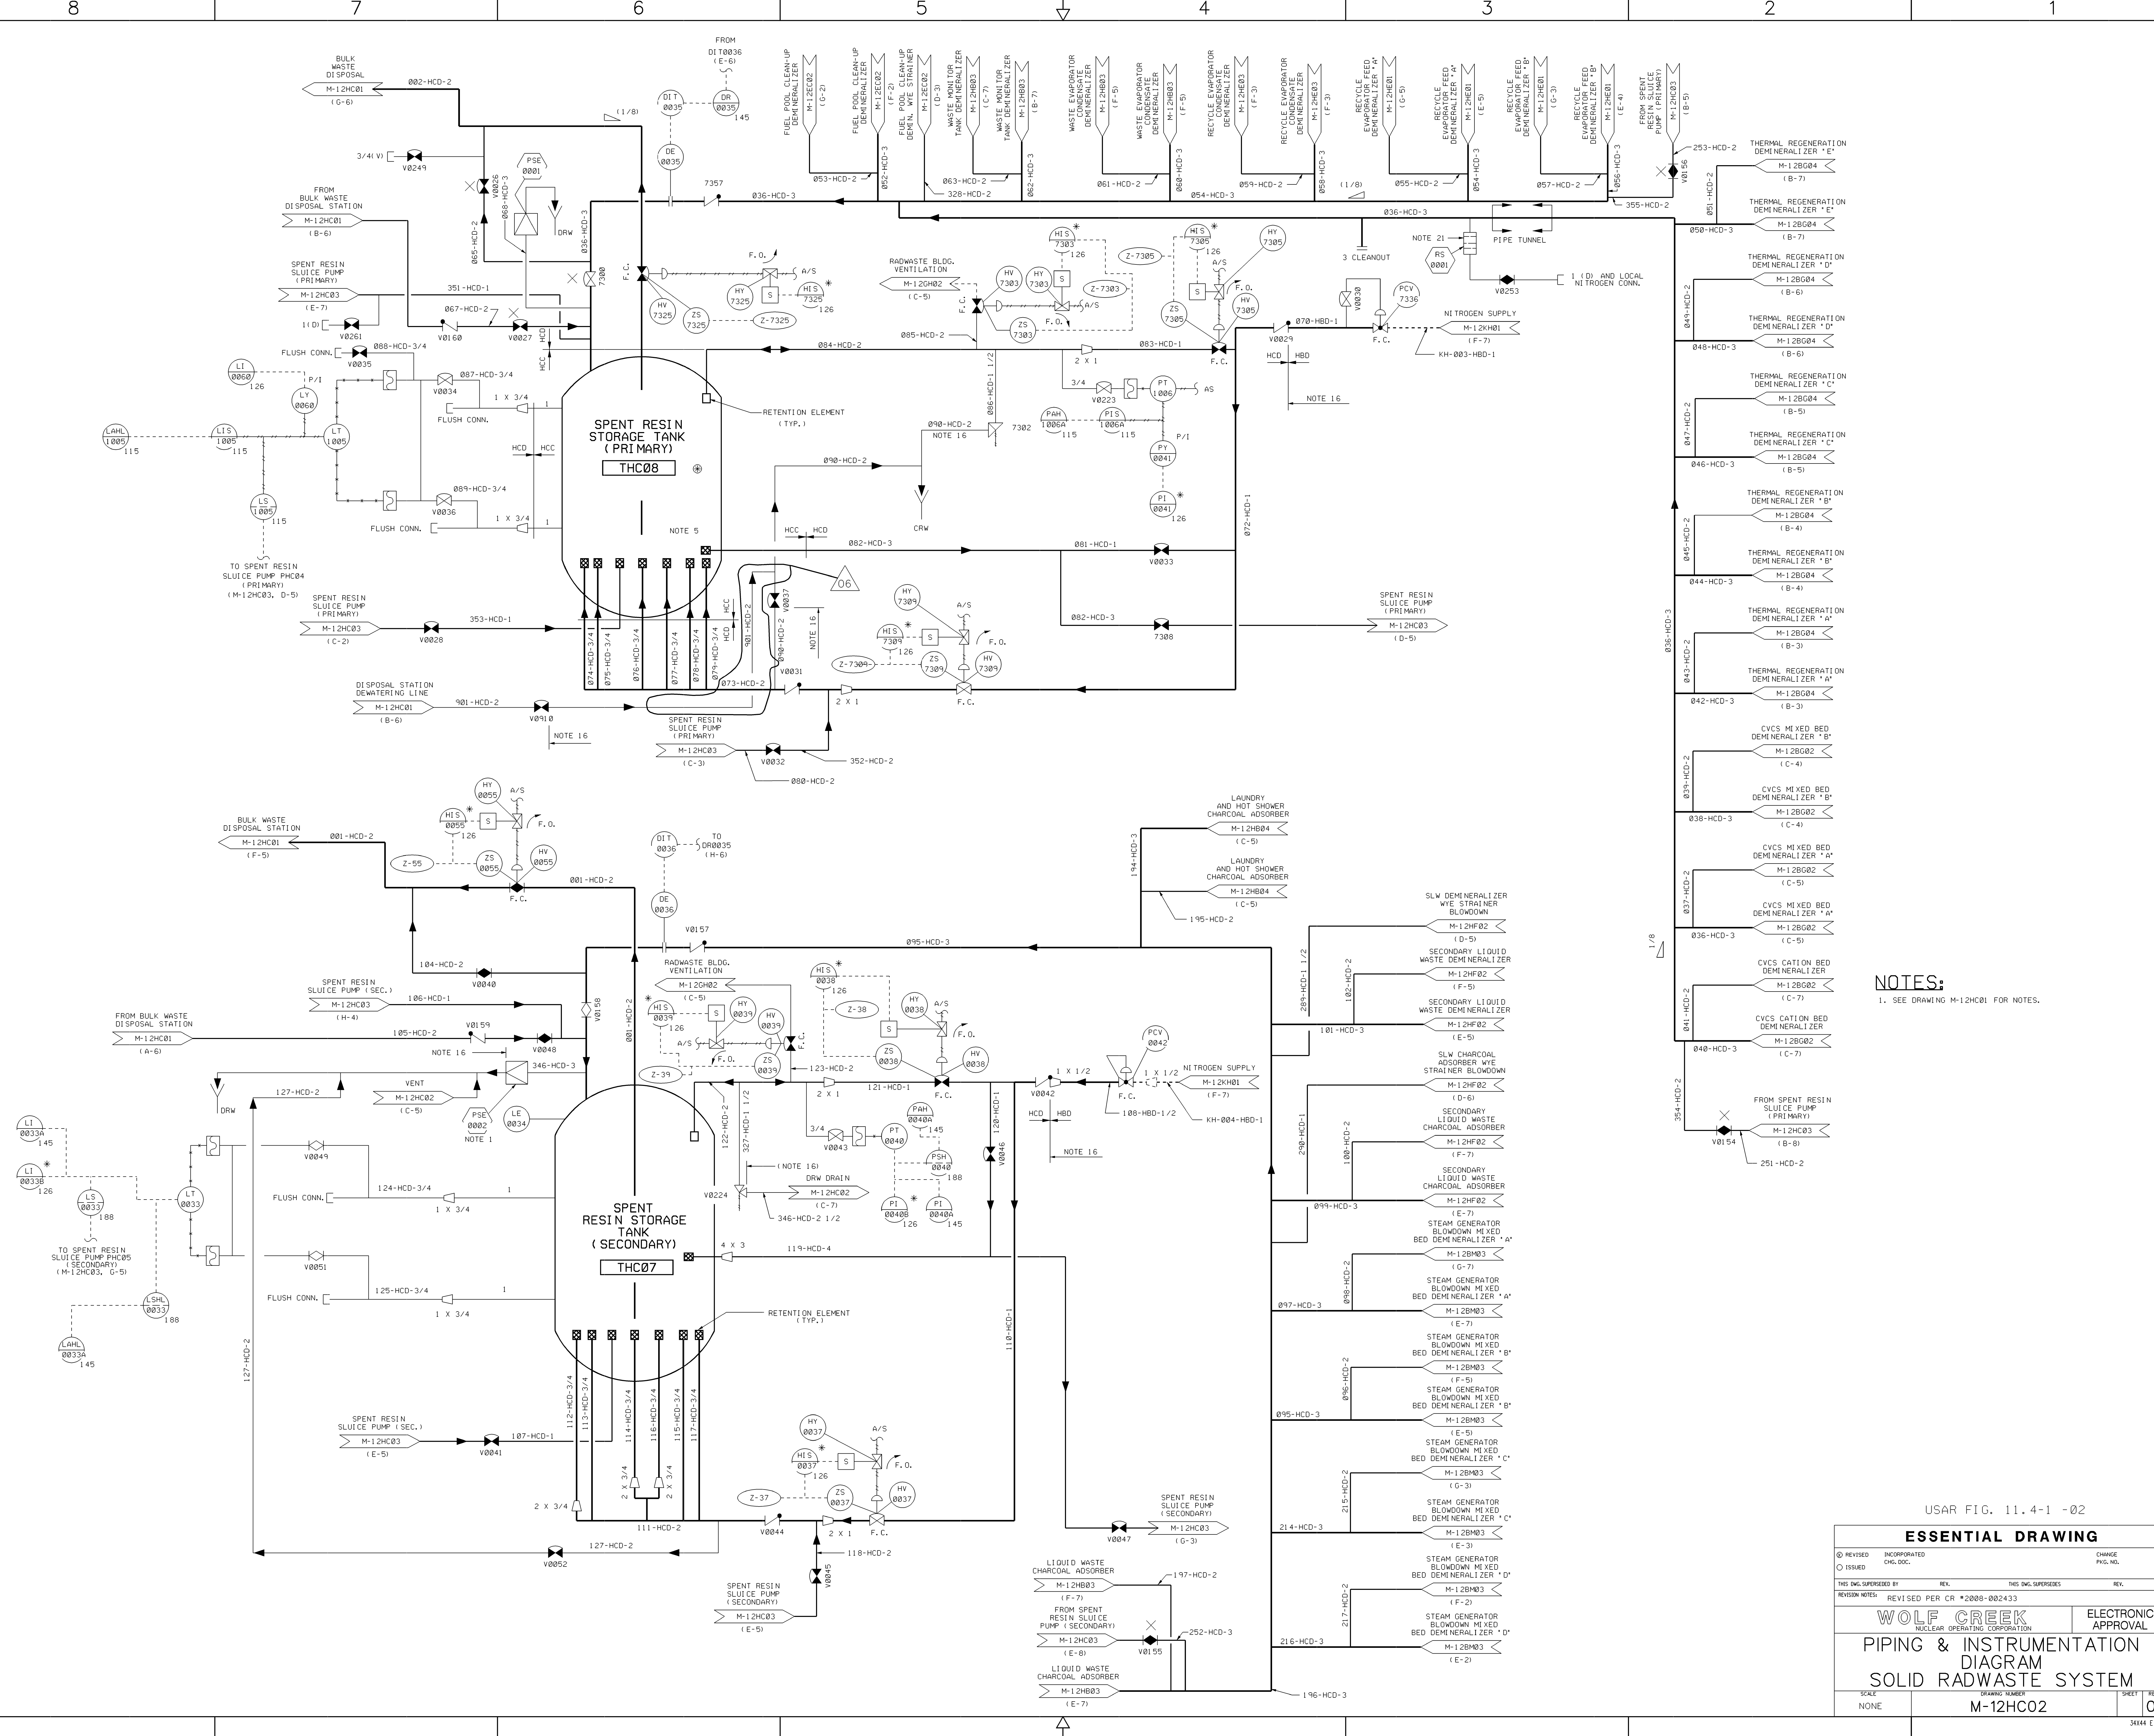

NOTES:
1. SEE DRAWING M-12HC01 FOR NOTES.

USAR FIG. 11.4-1 -02

ESSENTIAL DRAWING

REVISED

INCORPORATED

ISSUED

CHG. DOC.

CHG. NO.

PKG. NO.

THIS DWG. SUPERSEDES

REV.

THIS DWG. SUPERSEDES

REV.

REVISION NOTES: REVISED PER CR #2008-002433

WOLF CREEK
NUCLEAR OPERATING CORPORATION

ELECTRONIC
APPROVAL

**PIPING & INSTRUMENTATION
DIAGRAM**


SOLID RADWASTE SYSTEM

SCALE
NONE

DRAWING NUMBER
M-12HC02

SHEET
06

Released by Document Services Release Date: 07/09/08

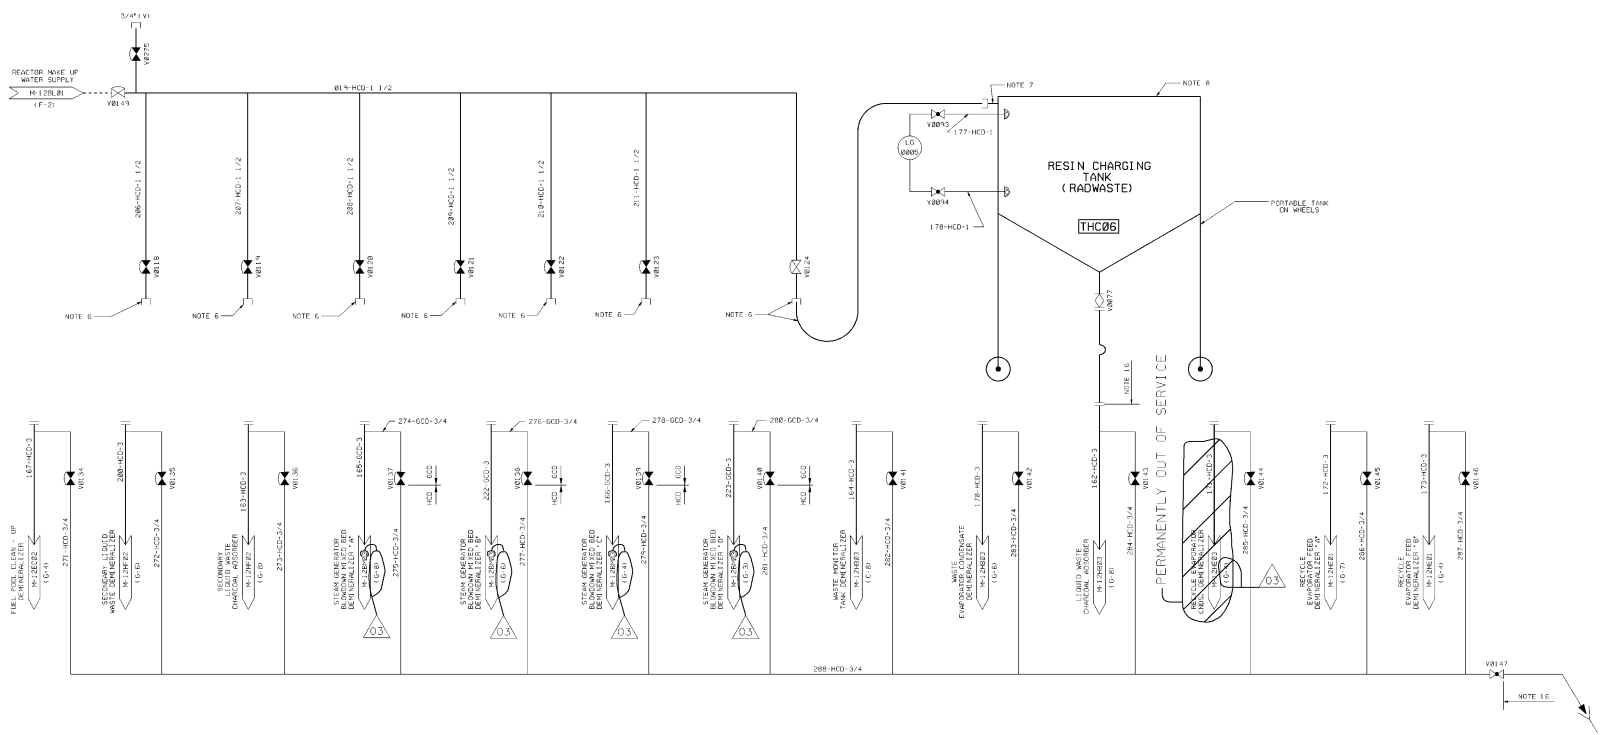

NOTES
FOR NOTES SEE DRAWING M-12HC04.

USAR FIG. 11.4-1-B4

ESSENTIAL DRAWING			
REVISION	DESCRIPTION	DATE	BY
1	ISSUED	10/1/80	WOLF CREEK
THIS DRAWING IS THE PROPERTY OF WOLF CREEK. IT IS TO BE USED FOR THE PROJECT ONLY AND IS NOT TO BE REPRODUCED OR TRANSMITTED IN ANY FORM OR BY ANY MEANS, ELECTRONIC OR MECHANICAL, WITHOUT PERMISSION IN WRITING FROM WOLF CREEK.		ELECTRONIC APPROVAL	
WOLF CREEK		ELECTRONIC APPROVAL	
LOCAL OPERATIONS CENTER		ELECTRONIC APPROVAL	
PIPING AND INSTRUMENTATION		ELECTRONIC APPROVAL	
SOLID RADWASTE SYSTEM		ELECTRONIC APPROVAL	
M-12HC04		ELECTRONIC APPROVAL	
SHEET NO. 03		ELECTRONIC APPROVAL	