


Figure 8a2.2-1 – One-Line Diagram – Uninterruptible Electrical Power Supply System

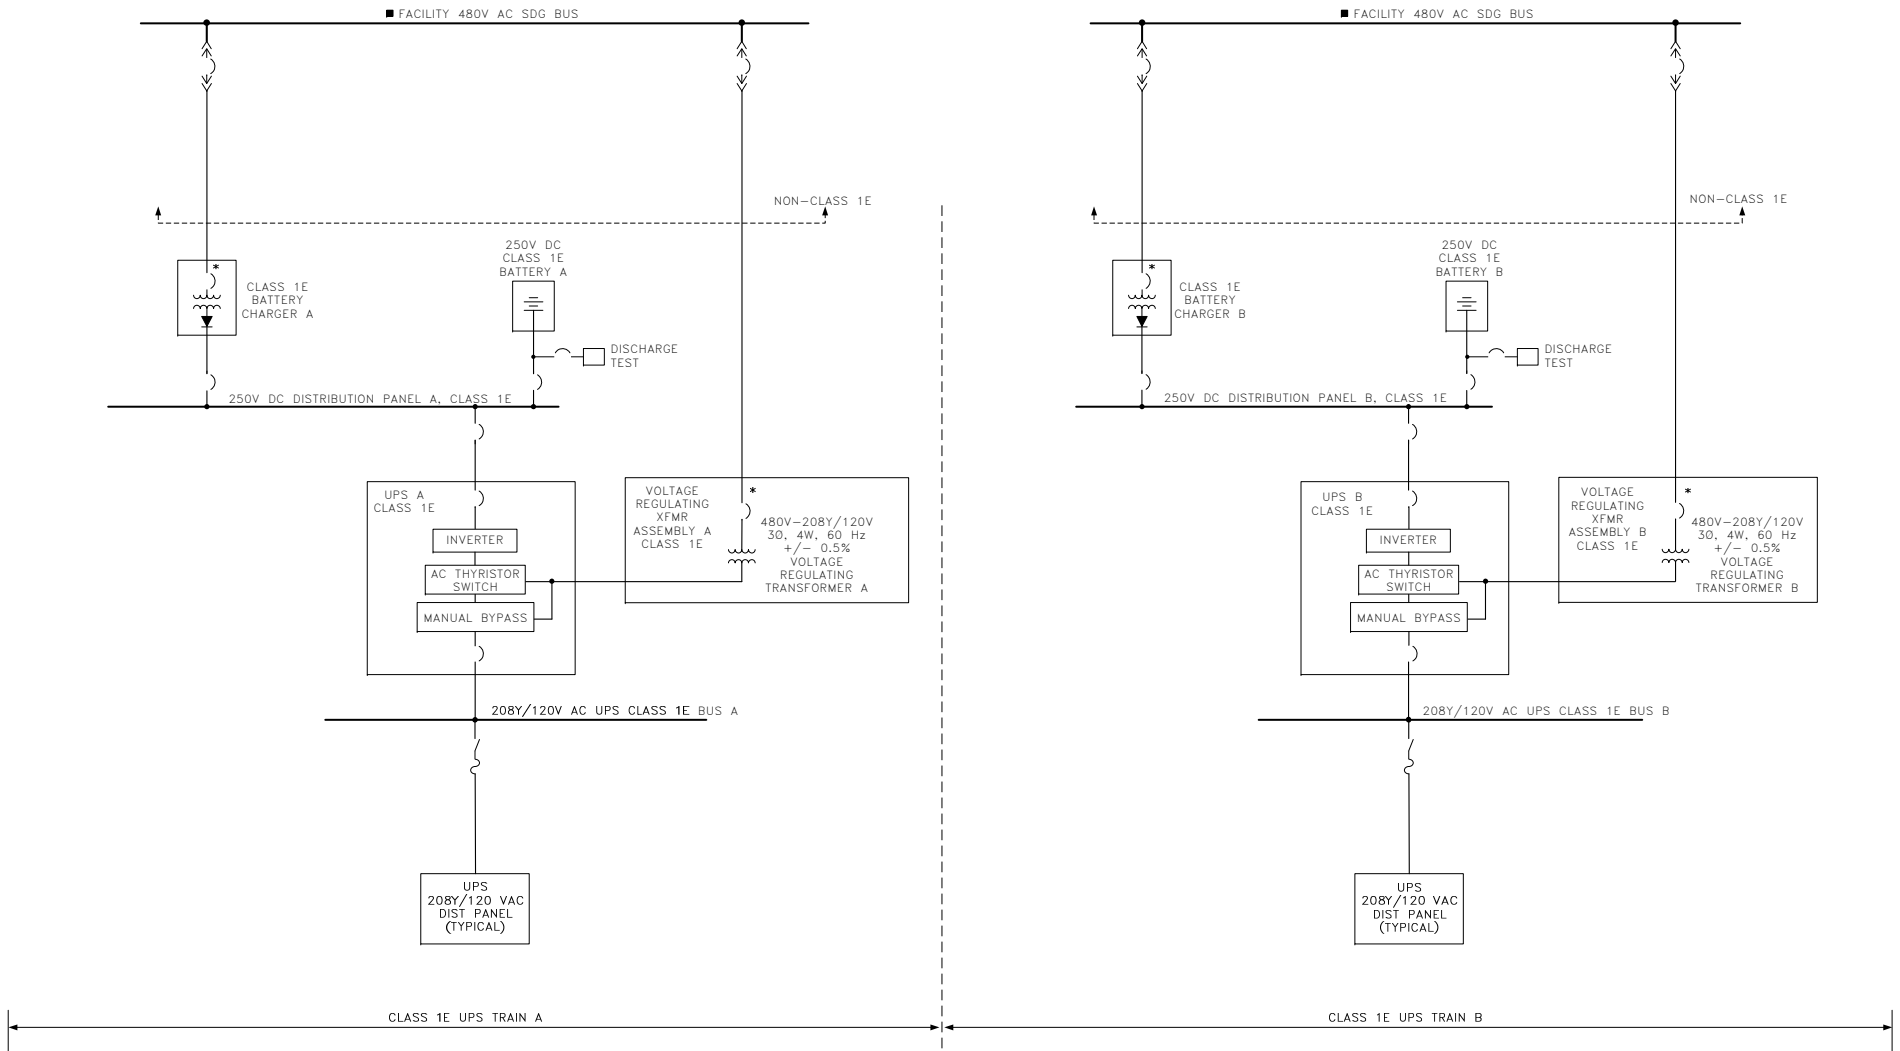

LEGEND:
 * NON-CLASS 1E TO CLASS 1E ISOLATOR
 ■ FACILITY ONE-LINE DIAGRAM DRAWING NUMBER LATER