
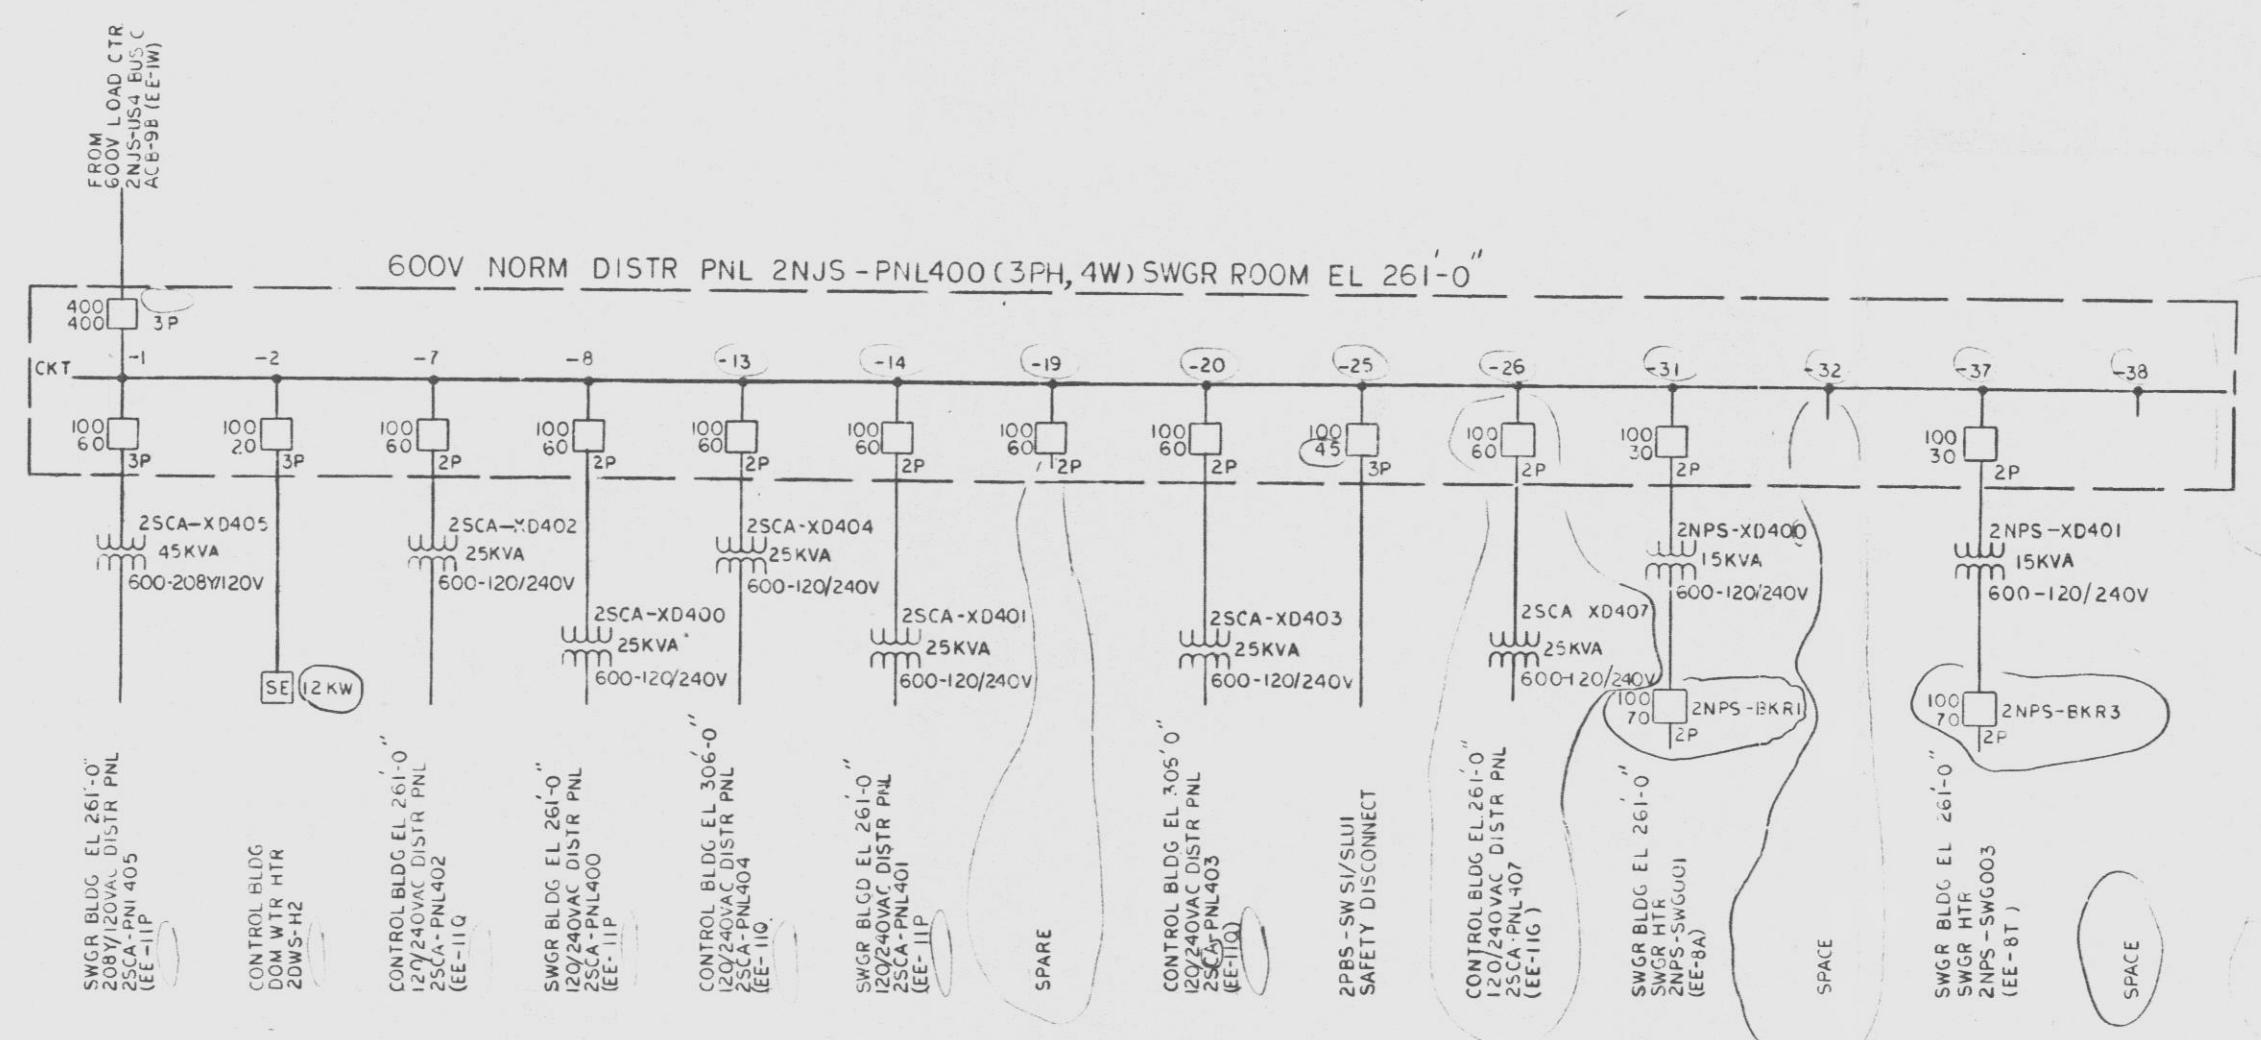


12177-EE-IBD-5

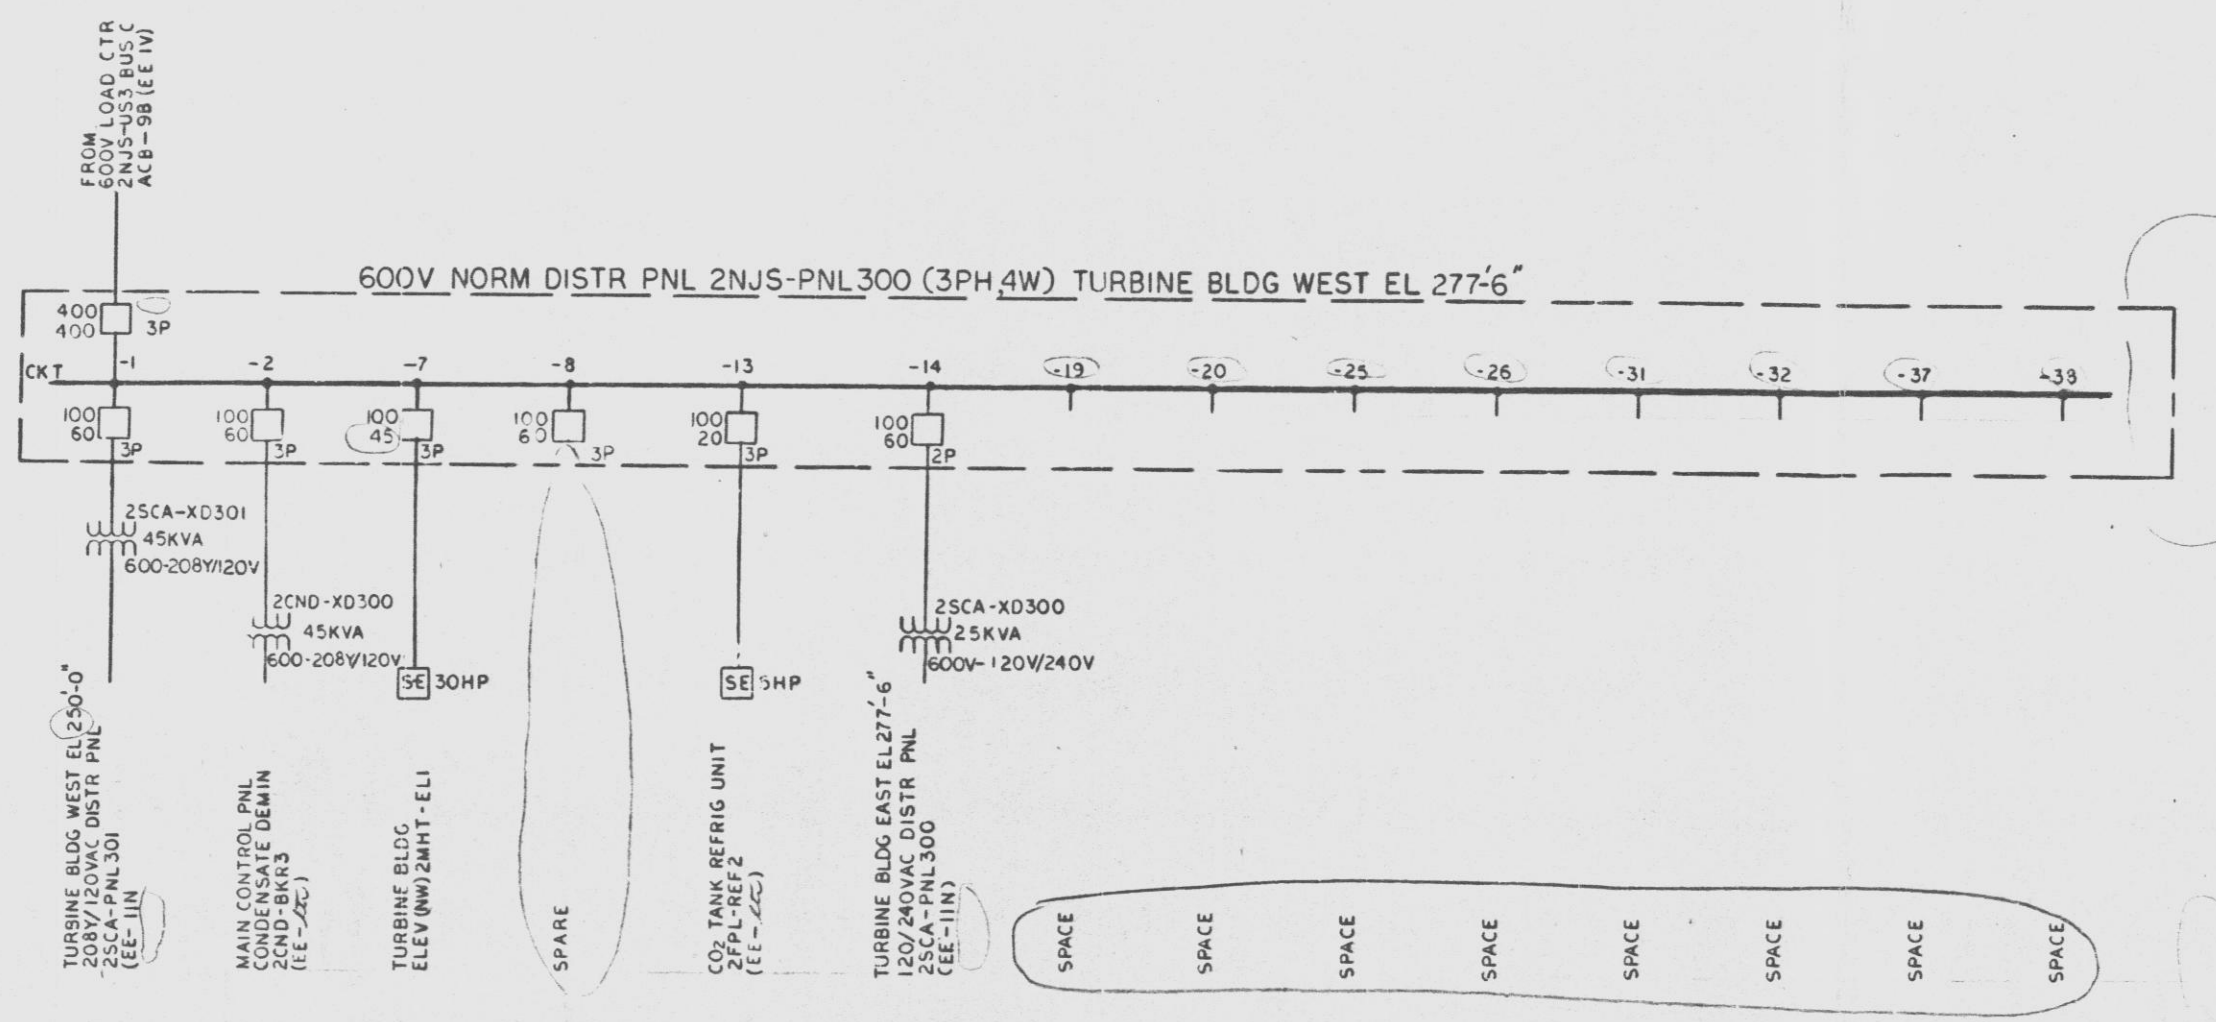

NOTES:
1. GENERAL NOTES, REFERENCES & ADDITIONAL SYMBOLS EE-ICA.

TI APERTURE CARD

QA CAT II



APPROVED Richard M. Melli
LICENSED PROFESSIONAL ENGINEER, NO. 052899
STATE OF NEW YORK
ALTERATION EXCEPT BY A LICENSED PROFESSIONAL ENGINEER IS ILLEGAL

600V ONE LINE DIAGRAM
DISTRIBUTION PANELS
2NJS-PNL300 & 2NJS-PNL400

NINE MILE POINT NUCLEAR STATION - UNIT 2
NIAGARA MOHAWK POWER CORPORATION
BYZON & WEBSTER ENGINEERING CORPORATION
BOSTON, MASS.

CH
DRAWING NUMBER 12177-EE-IBD-5

THE INFORMATION ON THIS DRAWING MAY NOT BE COPIED OR USED FOR OTHER THAN THE CONSTRUCTION, MAINTENANCE OR REPAIR OF THE PLANT FACILITY DESCRIBED IN THE TITLE BLOCK.

PDRCN NO. NJS-0002		ISSUED FOR DESIGN REVIEW															
1. SEE RECORD OF DWG CHANGES BCE-18D-5 2. SEE RECORD OF DWG CHANGES BCE-18D-4 3. SEE RECORD OF DRAWING CHANGES BCE-18D-3 4. SEE RECORD OF DRAWING CHANGES BCE-18D-2 ORIGINAL ISSUE																	
ISSUE	DESCRIPTION	CHG	COM	APPR	DATE	ISSUE	DESCRIPTION	CHG	COM	APPR	DATE	ISSUE	DESCRIPTION	CHG	COM	APPR	DATE
90	ARCH. CONC. STEEL L & T INST. M.D.B.M P.S. S.A. S.E. ELEC. LTB. MFT. P.C.T.				90	ARCH. CONC. STEEL L & T INST. M.D.B.M P.S. S.A. S.E. ELEC. LTB. MFT. P.C.T.					90	ARCH. CONC. STEEL L & T INST. M.D.B.M P.S. S.A. S.E. ELEC. LTB. MFT. P.C.T.					90