


12177-EE-1AY-3

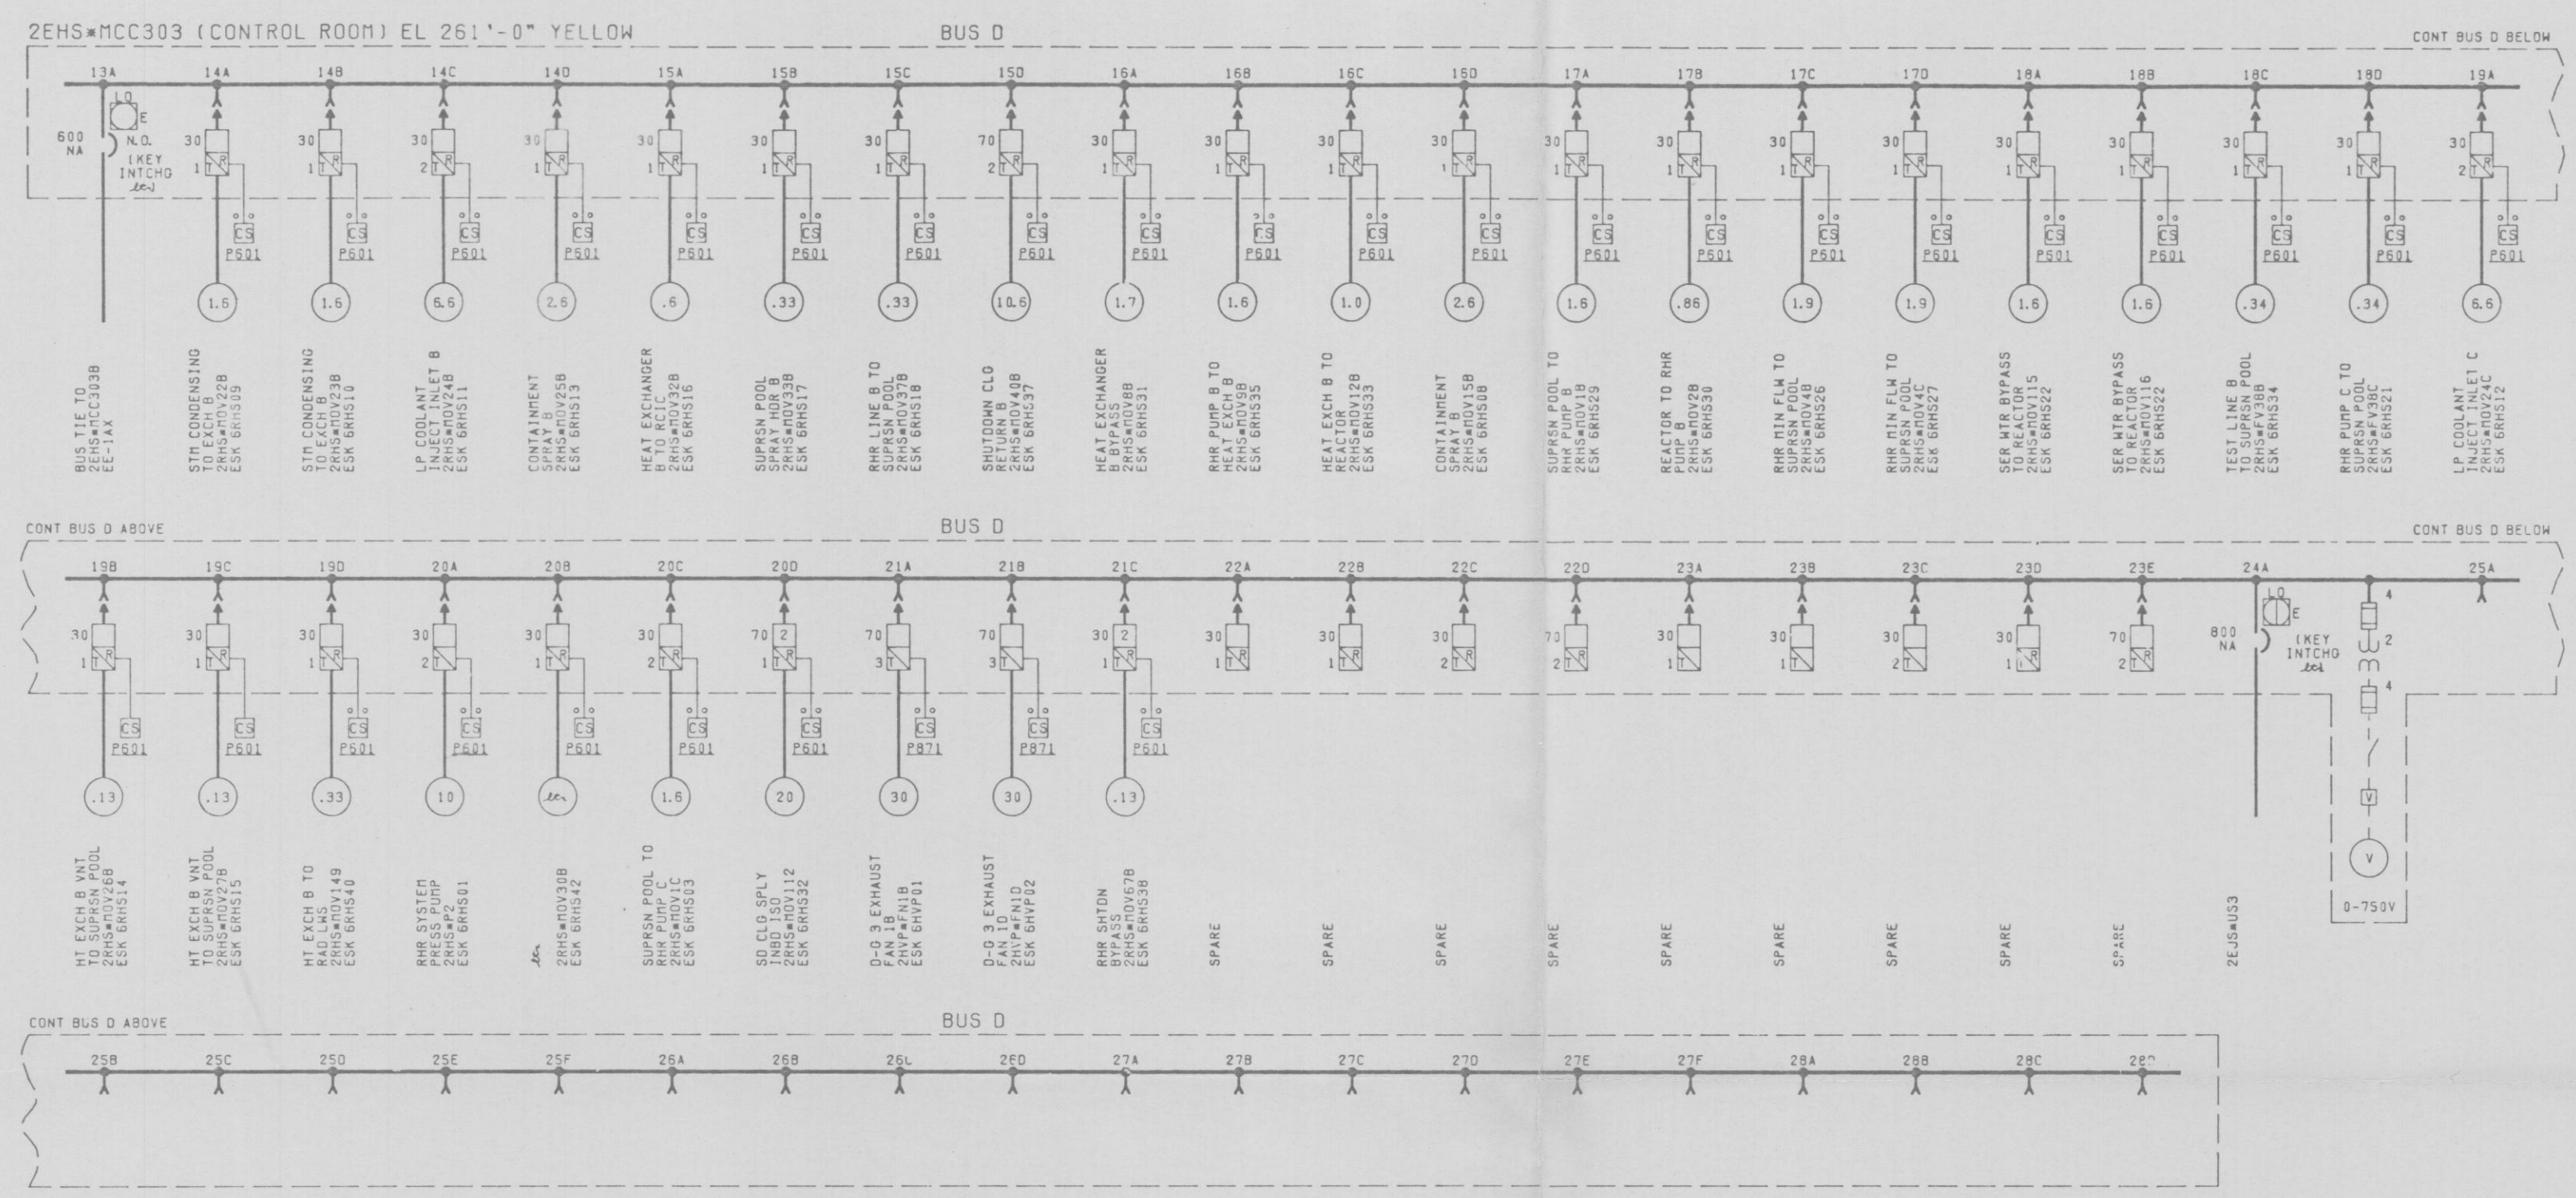

NOTES:  
1. GENERAL NOTES, REFERENCES, ADDITIONAL SYMBOLS & LOCATION SYMBOLS EE-1AA.

PRO APERTURE CARD



APPROVED *J. Davis*  
LICENSED PROFESSIONAL ENGINEER, NO. 55786  
ALTERNATION EXCEPT BY A LICENSED PROFESSIONAL ENGINEER IS ILLEGAL.

NUCLEAR SAFETY RELATED  
QA CAT I  
600V ONE LINE DIAGRAM  
2EHS\*MCC303  
CONTROL ROOM BUILDING  
NINE MILE POINT NUCLEAR STATION-UNIT 2  
NIAGARA MOHAWK POWER CORPORATION  
STONE & WEBSTER ENGINEERING CORPORATION  
CHERRY HILL, N.J.  
DRAWING NUMBER 12177-EE-1AY-3

THE INFORMATION ON THIS DRAWING MAY NOT BE COPIED OR USED FOR OTHER THAN THE CONSTRUCTION, MAINTENANCE OR REPAIR OF THE PLANT FACILITY DESCRIBED IN THE TITLE BLOCK.

ISSUE	DESCRIPTION	CHG	CORRECT	ISSUE	DESCRIPTION	CHG	CORRECT	ISSUE	DESCRIPTION	CHG	CORRECT	ISSUE	DESCRIPTION	CHG	CORRECT	ISSUE	DESCRIPTION	CHG	CORRECT	ISSUE	DESCRIPTION	
1	REVISED & REDRAWN																					
2	SUPERSEDED BY DWG 1AY-3																					
3	ORIGINAL ISSUE FOR ENGINEERING ONLY																					