


12177-EE-1AW-3

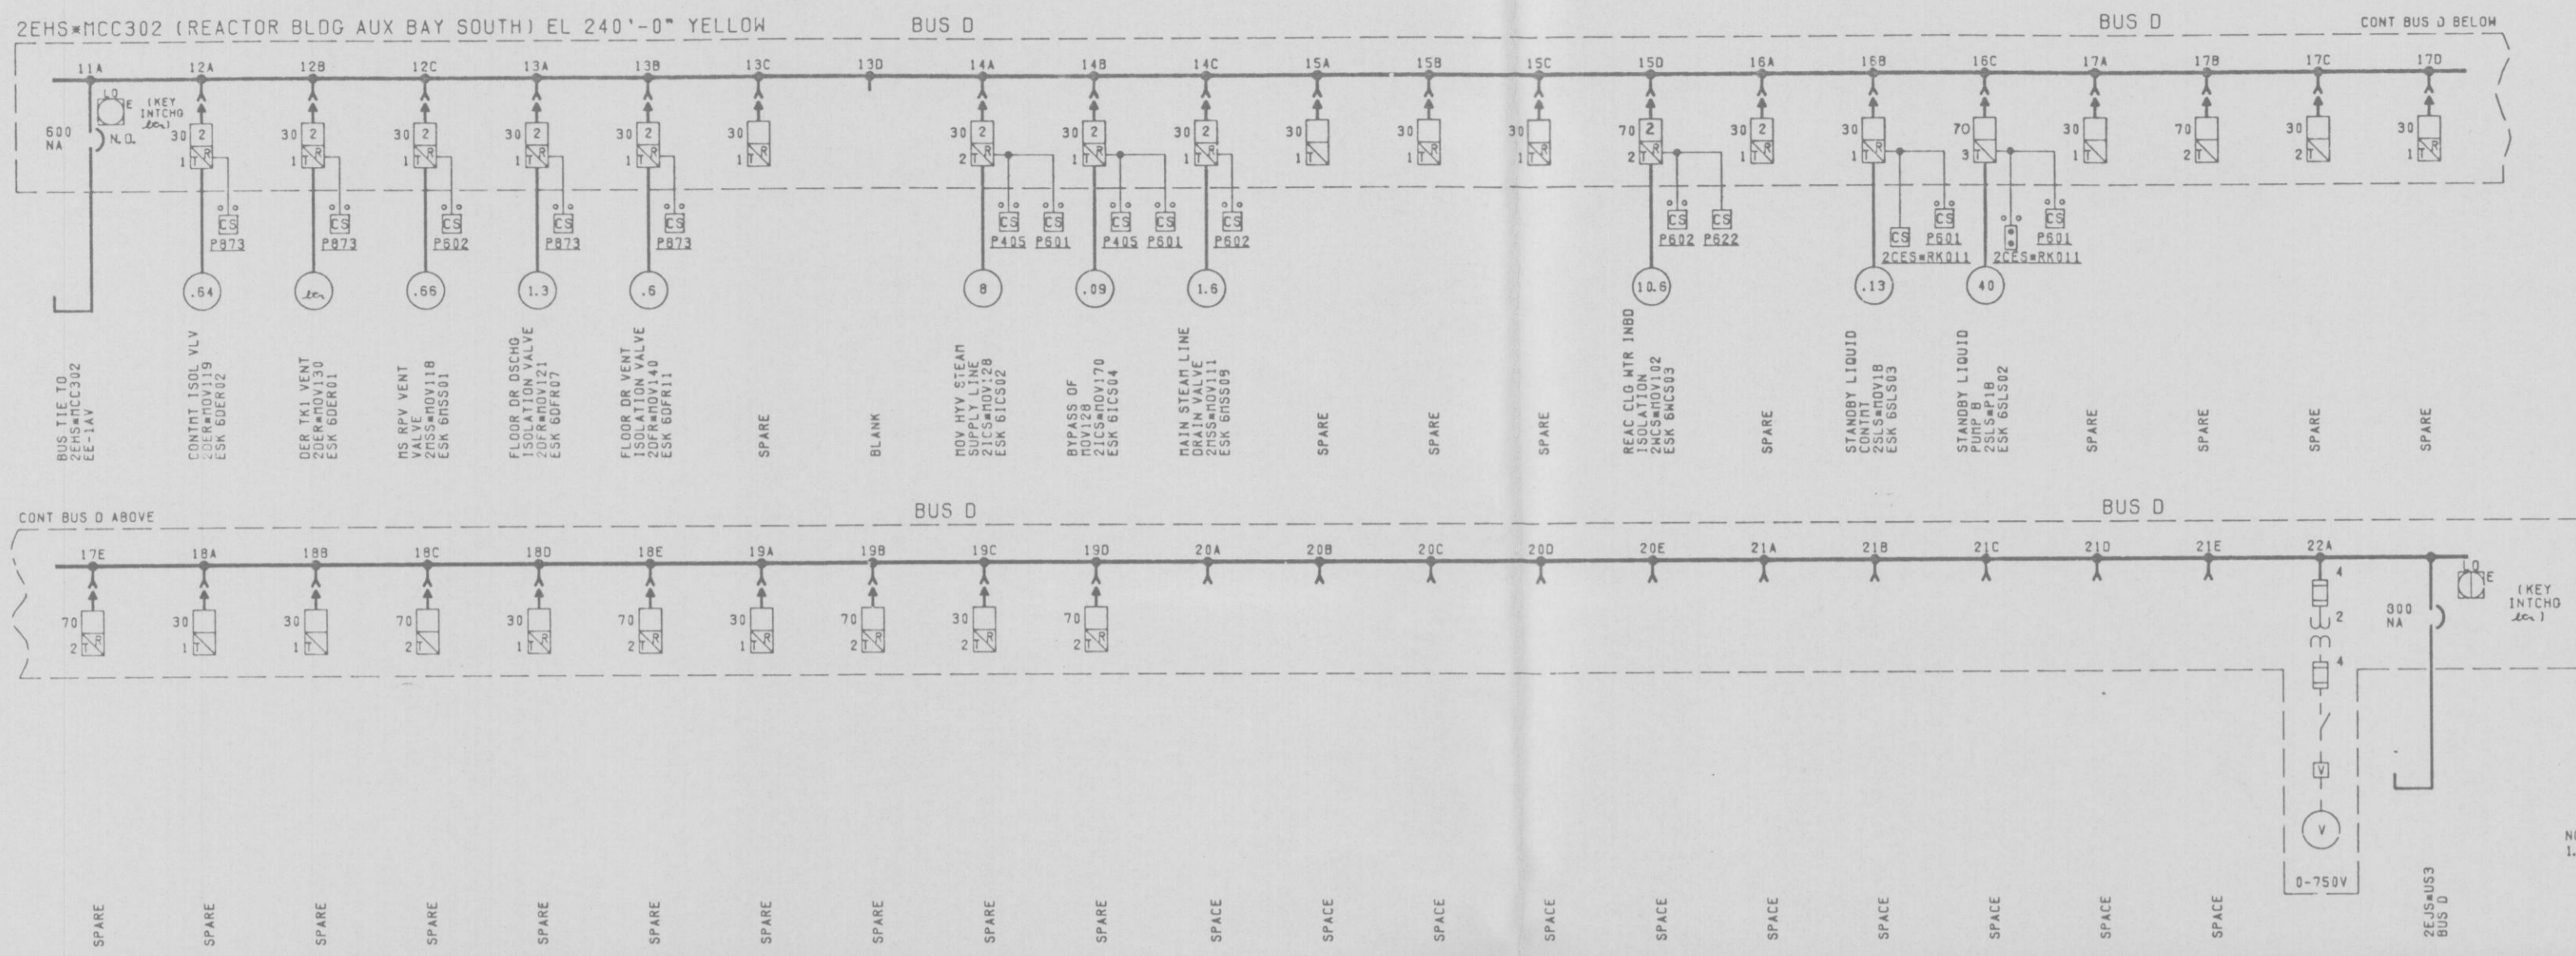

NOTES:
 1. GENERAL NOTES, REFERENCES, ADDITIONAL SYMBOLS & LOCATION SYMBOLS EE-1AA.

PRC APERTURE CARD



APPROVED: *K. Khawaja*
 LICENSED PROFESSIONAL ENGINEER, NO. 55784
 ALTERATION EXCEPT BY A LICENSED PROFESSIONAL ENGINEER IS ILLEGAL.

NUCLEAR SAFETY RELATED
 QA CAT 1

600V ONE LINE DIAGRAM
 2EHS*MCC302
 REACTOR BLDG AUX BAY SOUTH
 NINE MILE POINT NUCLEAR STATION-UNIT 2
 NIAGARA MOHAWK POWER CORPORATION
 STONE & WEBSTER ENGINEERING CORPORATION
 CHEMUNY HILL, N.Y.

DRAWING NUMBER 12177-EE-1AW-3

DESIGNED BY J. DAVIS DRAWN BY D. KALEY
 CHECKED BY C. HENDERSON

THE INFORMATION ON THIS DRAWING MAY NOT BE COPIED OR USED FOR OTHER THAN THE CONSTRUCTION, MAINTENANCE OR REPAIR OF THE PLANT FACILITY DESCRIBED IN THE TITLE BLOCK.

| REV | DATE | DESCRIPTION | BY | CHECKED |
|-----|----------|----------------------------------|-----|---------|
| 1 | 11-21-84 | REVISED & REDRAWN | JAC | JAC |
| 2 | | SUPERSEDED BY DWG 12177-EE-1AW-3 | | |

| NO. | DESCRIPTION | CHG | CORRECT | ISSUE | NO. | DESCRIPTION | CHG | CORRECT | ISSUE |
|-----|---|-----|---------|-------|-----|---|-----|---------|-------|
| 1 | PCT ARCH CIVIL CONC STL LWP INTL N.S. P.A. S.A. FAC ELEC LTR INTL | | | | 1 | PCT ARCH CIVIL CONC STL LWP INTL N.S. P.A. S.A. FAC ELEC LTR INTL | | | |

SCALE: 1" = 12"