
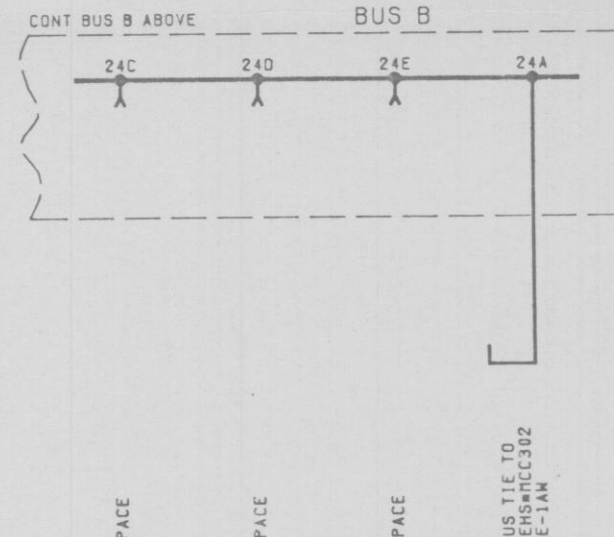
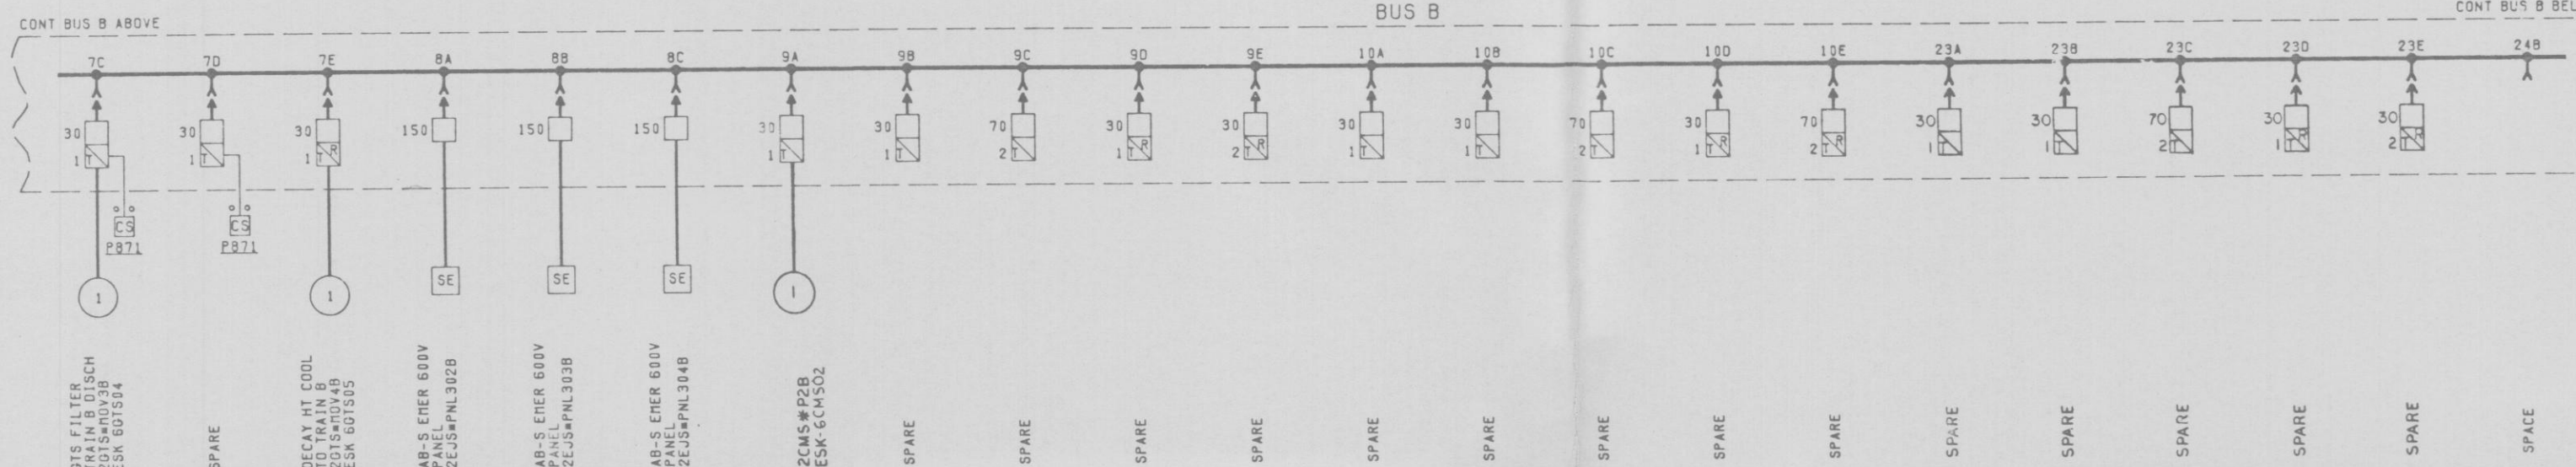


12177-EE-1AV-3

2EHS*MCC302 (REACTOR BLDG AUX BAY SOUTH) EL 240'-0" YELLOW

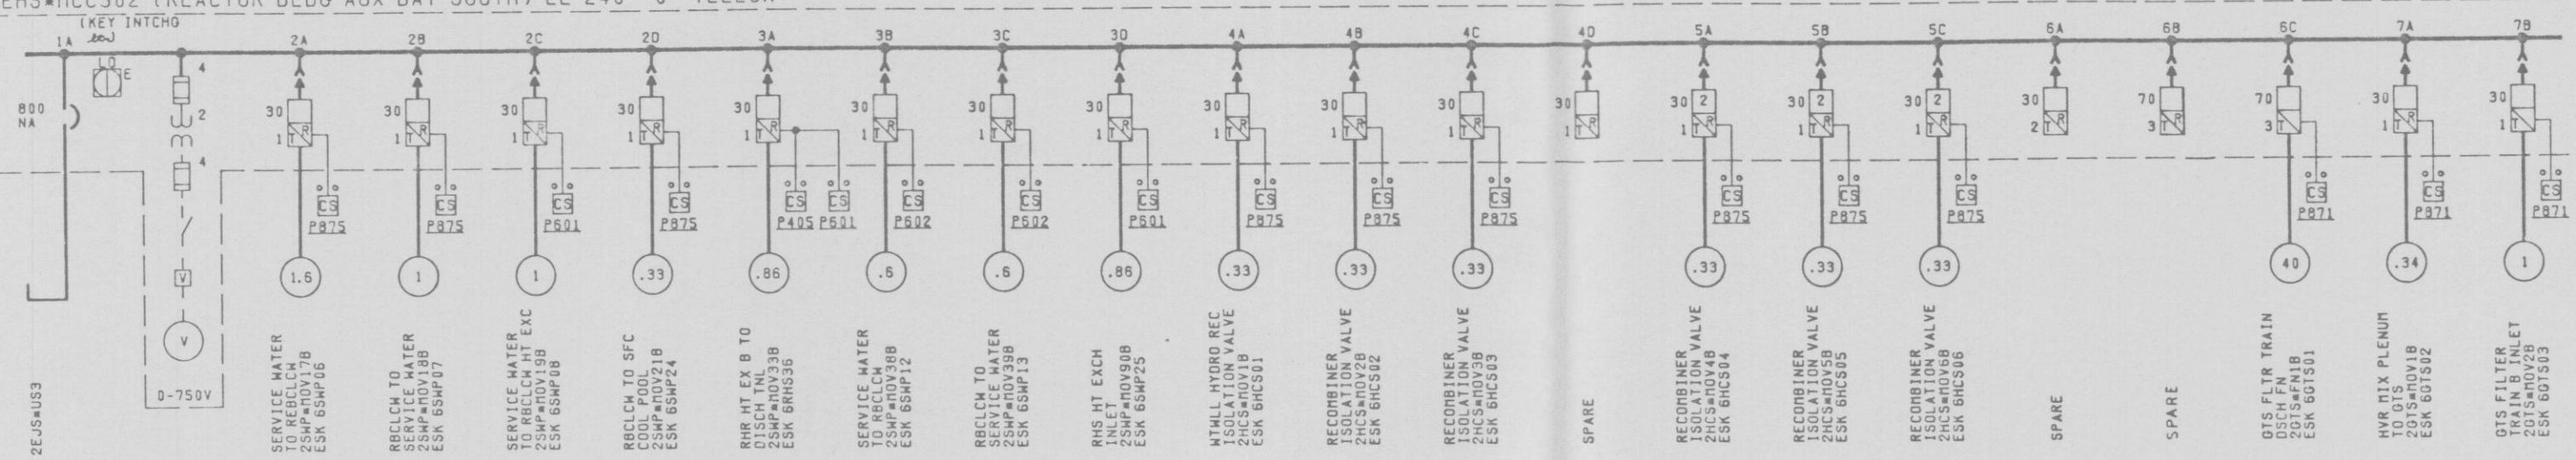

NOTES:
1. GENERAL NOTES, REFERENCES, ADDITIONAL SYMBOLS & LOCATION SYMBOLS EE-1AA.

PI APERTURE CARD



APPROVED: [Signature] LICENSE NO. 53786 ALTERNATION EXCEPT BY A LICENSED PROFESSIONAL ENGINEER IS ILLEGAL

NUCLEAR SAFETY RELATED
QA CAT I

600V ONE LINE DIAGRAM
2EHS*MCC302
REACTOR BLDG AUX BAY SOUTH
NINE MILE POINT NUCLEAR STATION-UNIT 2
NIAGARA MOHAWK POWER CORPORATION
STONE & WEBSTER ENGINEERING CORPORATION
 CHERRY HILL, N.Y.
CH DRAWING NUMBER **12177-EE-1AV-3**

THE INFORMATION ON THIS DRAWING MAY NOT BE COPIED OR USED FOR OTHER THAN THE CONSTRUCTION, MAINTENANCE OR REPAIR OF THE PLANT FACILITY DESCRIBED IN THE TITLE BLOCK.

DESIGNED BY: J. DAVIS
DRAWN BY: V. BERTINO
CHECKED BY: C. HENDERSON
DATE: [blank]

REV	NO	DATE	DESCRIPTION	BY				CHECKED				APPROVED				
				DESIGN	DRAWN	CHKD	APPD	DESIGN	DRAWN	CHKD	APPD	DESIGN	DRAWN	CHKD	APPD	
1			REVISED & REDRAWN	[initials]	[initials]	[initials]	[initials]	[initials]	[initials]	[initials]	[initials]	[initials]	[initials]	[initials]	[initials]	[initials]
			12177-EE-1AV-3	[initials]	[initials]	[initials]	[initials]	[initials]	[initials]	[initials]	[initials]	[initials]	[initials]	[initials]	[initials]	[initials]

REVISIONS

DATE

BY