


8856-M-174

This drawing and the design it covers are the property of BECHTEL. They are hereby loaned and on this borrower's express agreement that they will not be reproduced, copied, loaned, exhibited, or used except in the limited way and for the limited purpose intended by the lender to the borrower.

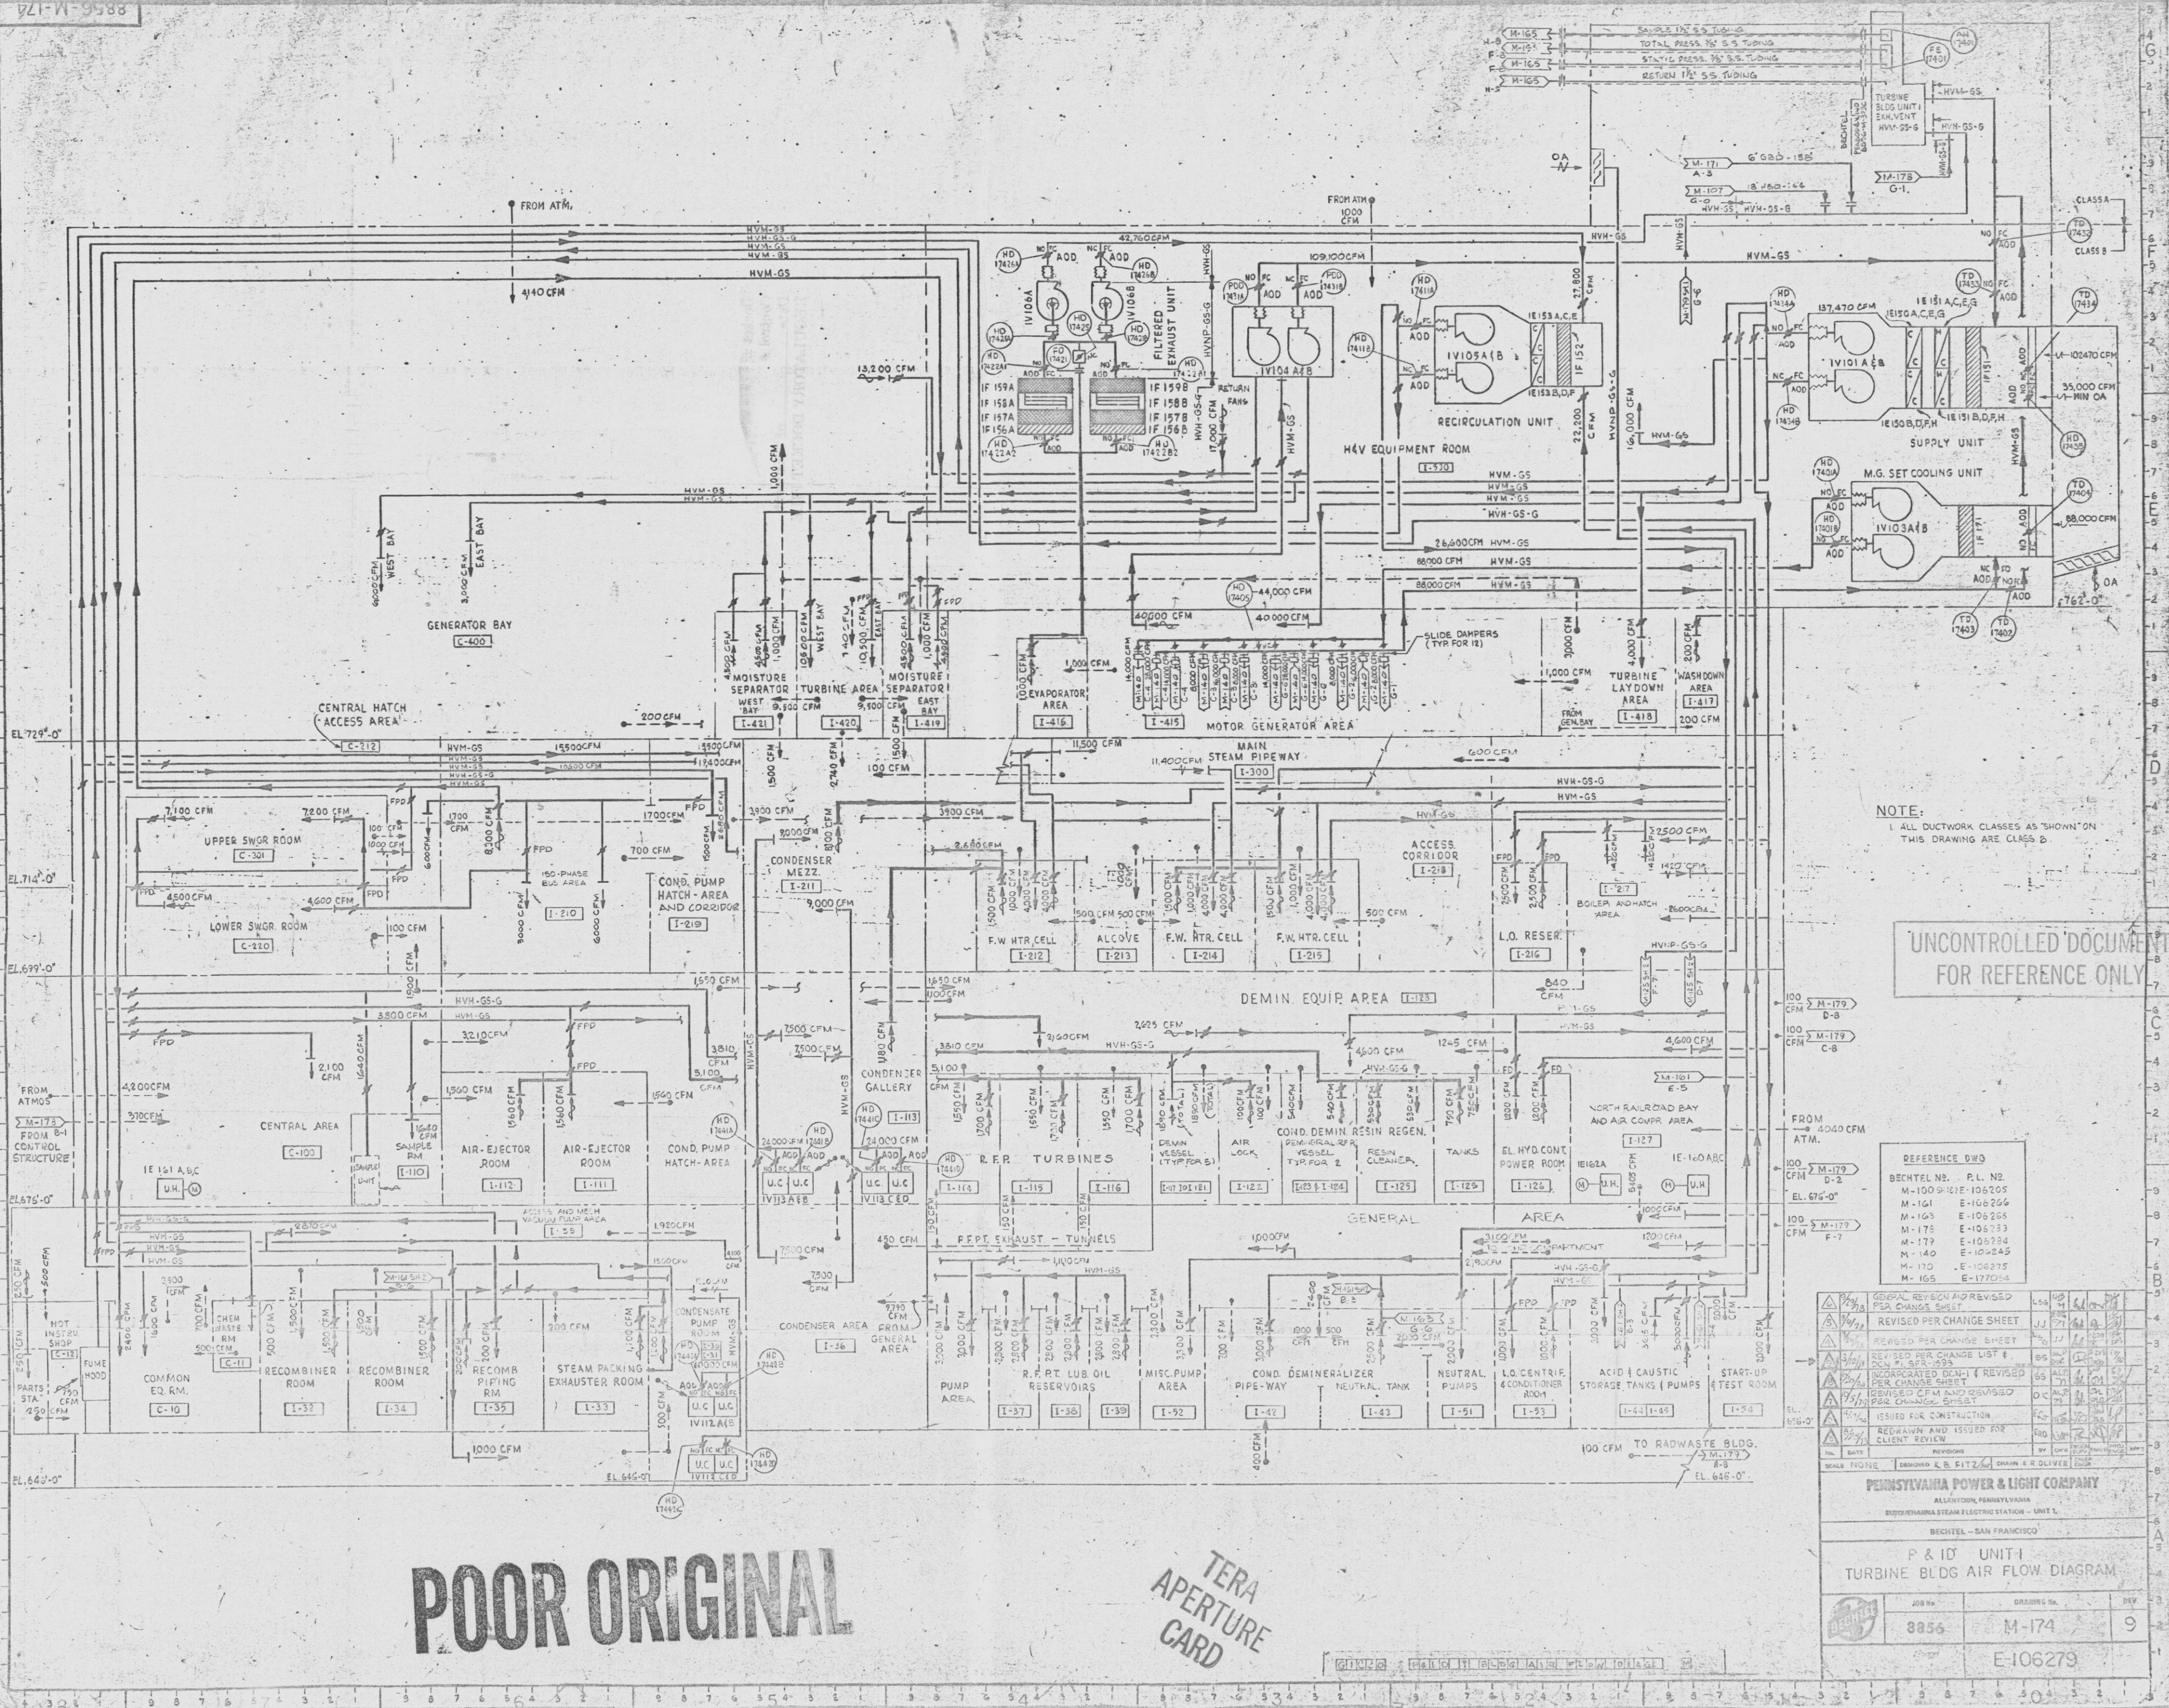

NOTE:
ALL DUCTWORK CLASSES AS SHOWN ON THIS DRAWING ARE CLASS B

UNCONTROLLED DOCUMENT
FOR REFERENCE ONLY

REFERENCE DWG

BECHTEL NO.	P.L. NO.
M-100-51012	106205
M-101	E-106206
M-103	E-106208
M-175	E-106213
M-179	E-106214
M-140	E-106245
M-170	E-106275
M-165	E-177054

GENERAL REVISION AND REVISED PER CHANGE SHEET	154	10/1/74	1/1
REVISED PER CHANGE SHEET	155	10/1/74	1/1
REVISED PER CHANGE SHEET	156	10/1/74	1/1
REVISED PER CHANGE SHEET	157	10/1/74	1/1
REVISED PER CHANGE SHEET	158	10/1/74	1/1
REVISED PER CHANGE SHEET	159	10/1/74	1/1
REVISED PER CHANGE SHEET	160	10/1/74	1/1
REVISED PER CHANGE SHEET	161	10/1/74	1/1
REVISED PER CHANGE SHEET	162	10/1/74	1/1
REVISED PER CHANGE SHEET	163	10/1/74	1/1
REVISED PER CHANGE SHEET	164	10/1/74	1/1
REVISED PER CHANGE SHEET	165	10/1/74	1/1
REVISED PER CHANGE SHEET	166	10/1/74	1/1
REVISED PER CHANGE SHEET	167	10/1/74	1/1
REVISED PER CHANGE SHEET	168	10/1/74	1/1
REVISED PER CHANGE SHEET	169	10/1/74	1/1
REVISED PER CHANGE SHEET	170	10/1/74	1/1
REVISED PER CHANGE SHEET	171	10/1/74	1/1
REVISED PER CHANGE SHEET	172	10/1/74	1/1
REVISED PER CHANGE SHEET	173	10/1/74	1/1
REVISED PER CHANGE SHEET	174	10/1/74	1/1
REVISED PER CHANGE SHEET	175	10/1/74	1/1
REVISED PER CHANGE SHEET	176	10/1/74	1/1
REVISED PER CHANGE SHEET	177	10/1/74	1/1
REVISED PER CHANGE SHEET	178	10/1/74	1/1
REVISED PER CHANGE SHEET	179	10/1/74	1/1
REVISED PER CHANGE SHEET	180	10/1/74	1/1
REVISED PER CHANGE SHEET	181	10/1/74	1/1
REVISED PER CHANGE SHEET	182	10/1/74	1/1
REVISED PER CHANGE SHEET	183	10/1/74	1/1
REVISED PER CHANGE SHEET	184	10/1/74	1/1
REVISED PER CHANGE SHEET	185	10/1/74	1/1
REVISED PER CHANGE SHEET	186	10/1/74	1/1
REVISED PER CHANGE SHEET	187	10/1/74	1/1
REVISED PER CHANGE SHEET	188	10/1/74	1/1
REVISED PER CHANGE SHEET	189	10/1/74	1/1
REVISED PER CHANGE SHEET	190	10/1/74	1/1
REVISED PER CHANGE SHEET	191	10/1/74	1/1
REVISED PER CHANGE SHEET	192	10/1/74	1/1
REVISED PER CHANGE SHEET	193	10/1/74	1/1
REVISED PER CHANGE SHEET	194	10/1/74	1/1
REVISED PER CHANGE SHEET	195	10/1/74	1/1
REVISED PER CHANGE SHEET	196	10/1/74	1/1
REVISED PER CHANGE SHEET	197	10/1/74	1/1
REVISED PER CHANGE SHEET	198	10/1/74	1/1
REVISED PER CHANGE SHEET	199	10/1/74	1/1
REVISED PER CHANGE SHEET	200	10/1/74	1/1

PENNSYLVANIA POWER & LIGHT COMPANY		
ALTOONA, PENNSYLVANIA		
BOOTHKAMP STEAM ELECTRIC STATION - UNIT 1		
BECHTEL - SAN FRANCISCO		
P & ID UNIT 1		
TURBINE BLDG AIR FLOW DIAGRAM		
JOB NO.	DRAWING NO.	REV.
8856	M-174	9
E-106279		

POOR ORIGINAL

TERA
APERTURE
CARD

30X

8106190248