



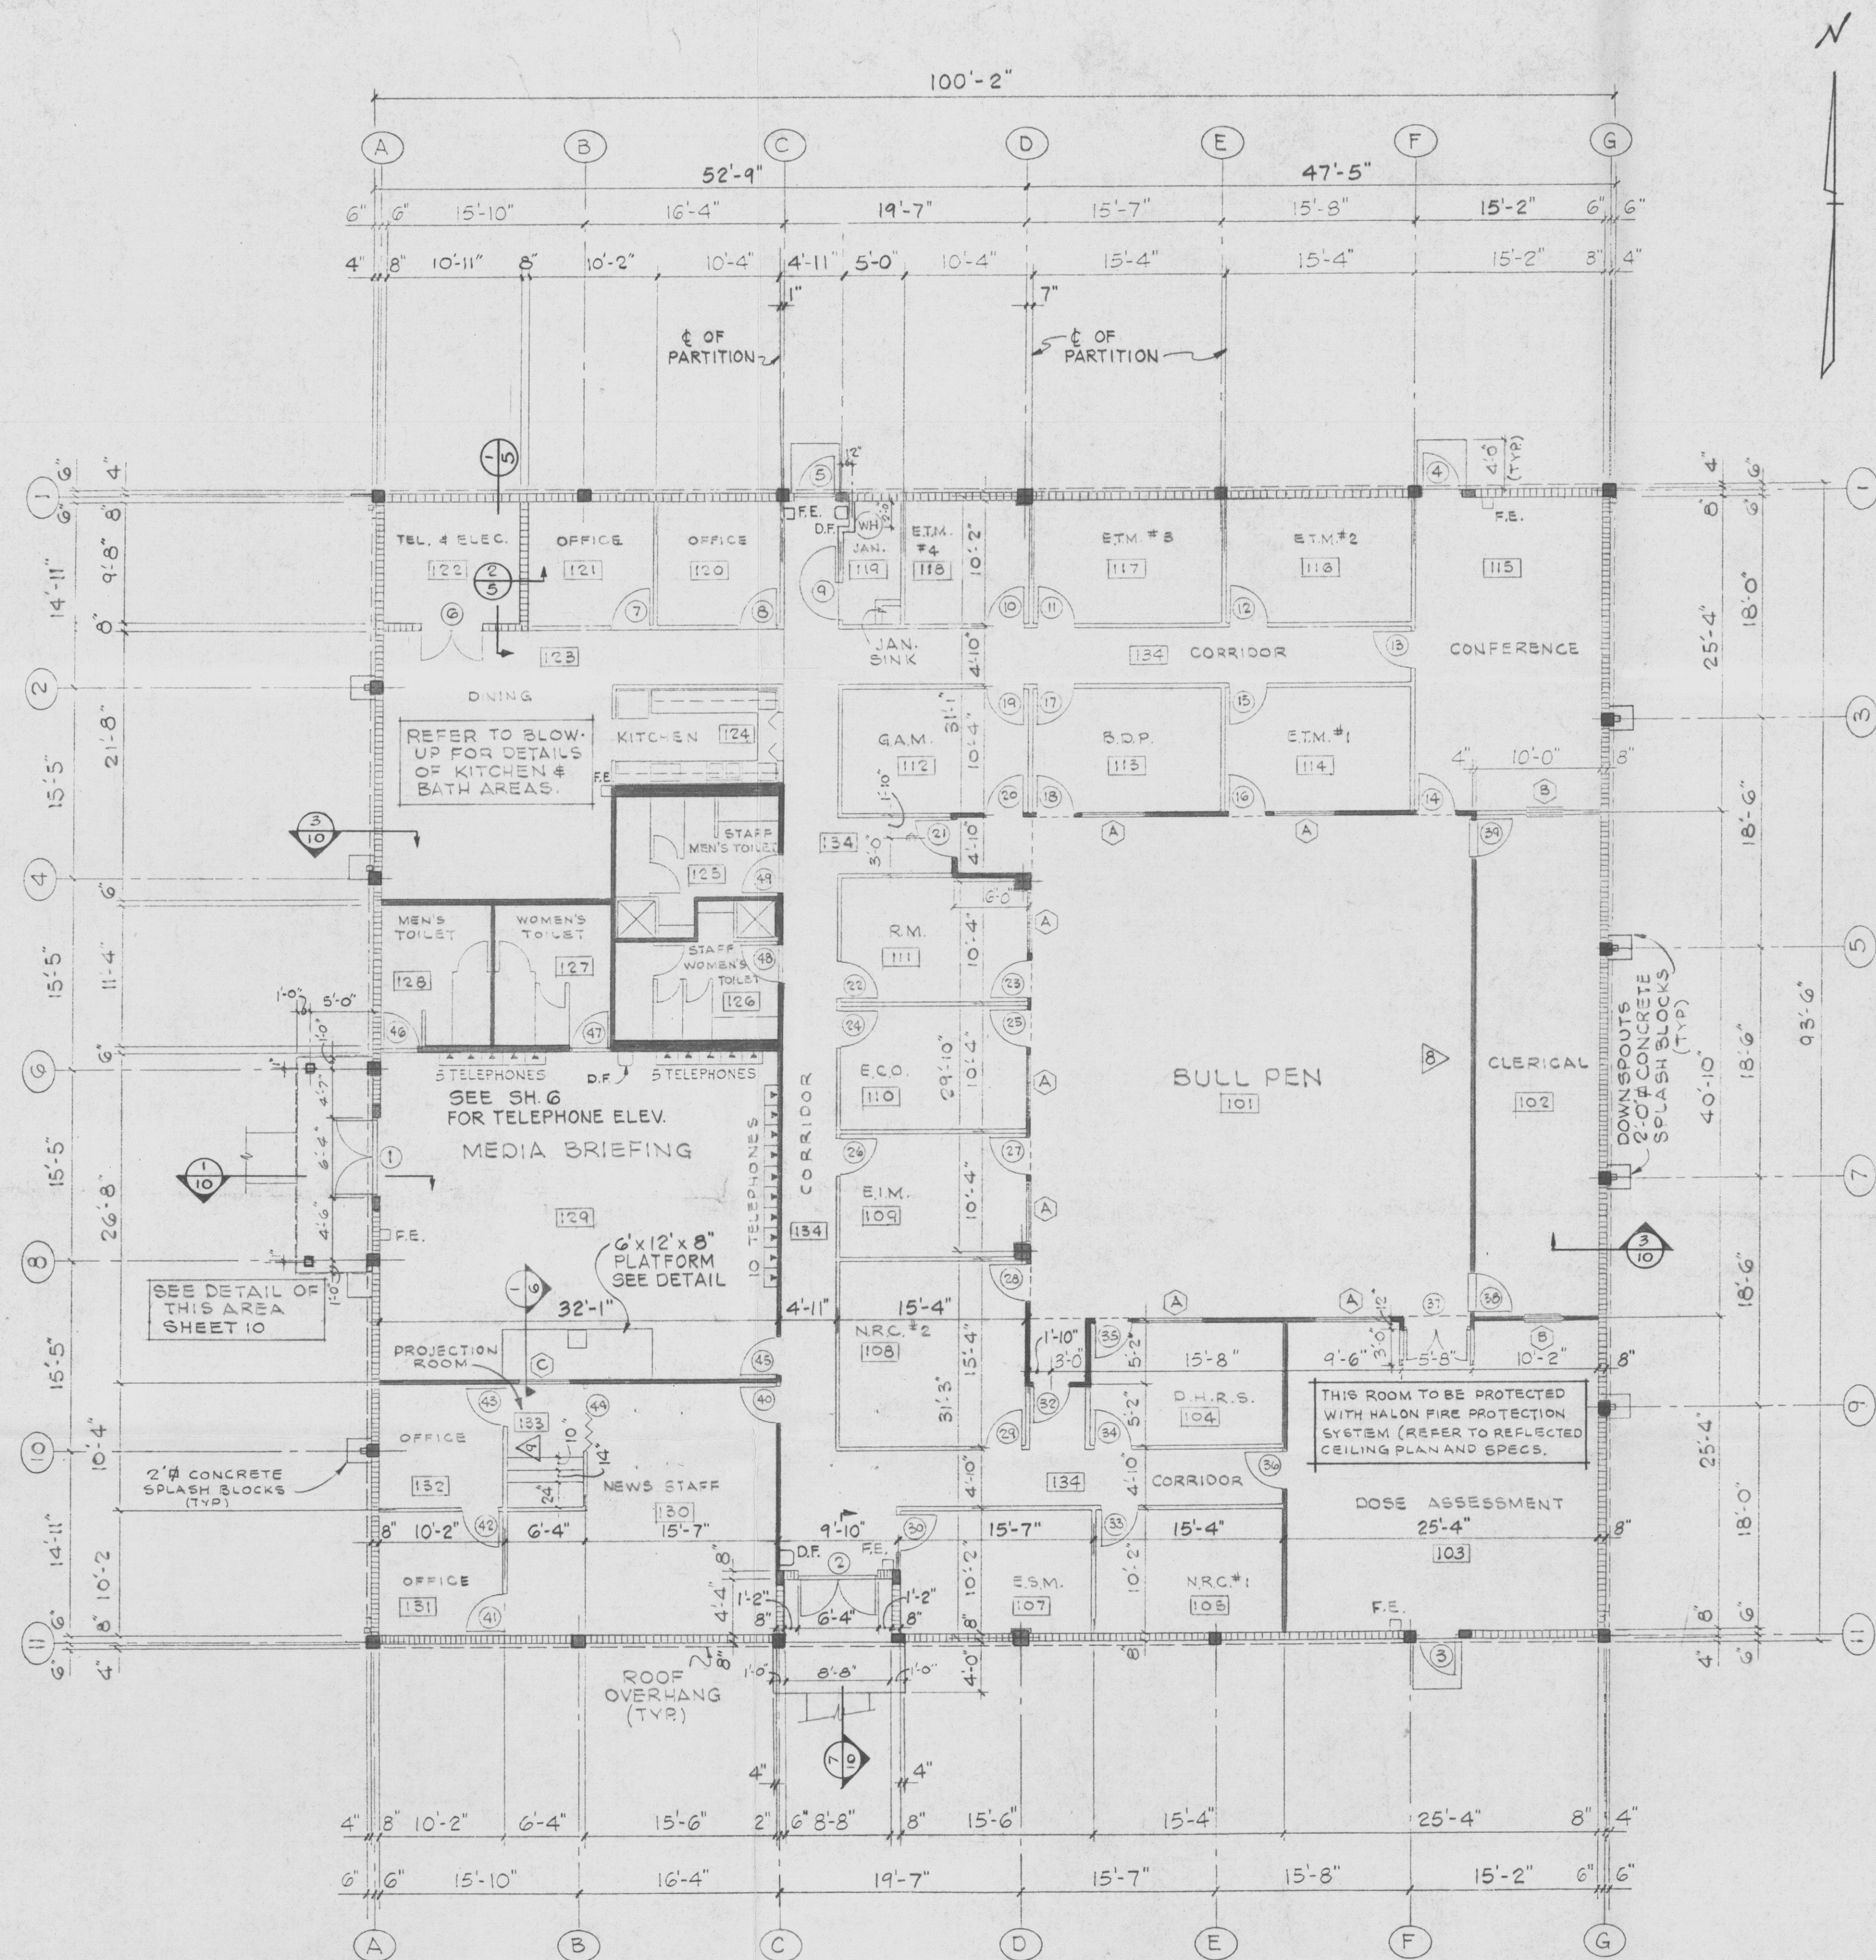


FLOOR PLAN

SCALE: 1/8" = 1'-0"

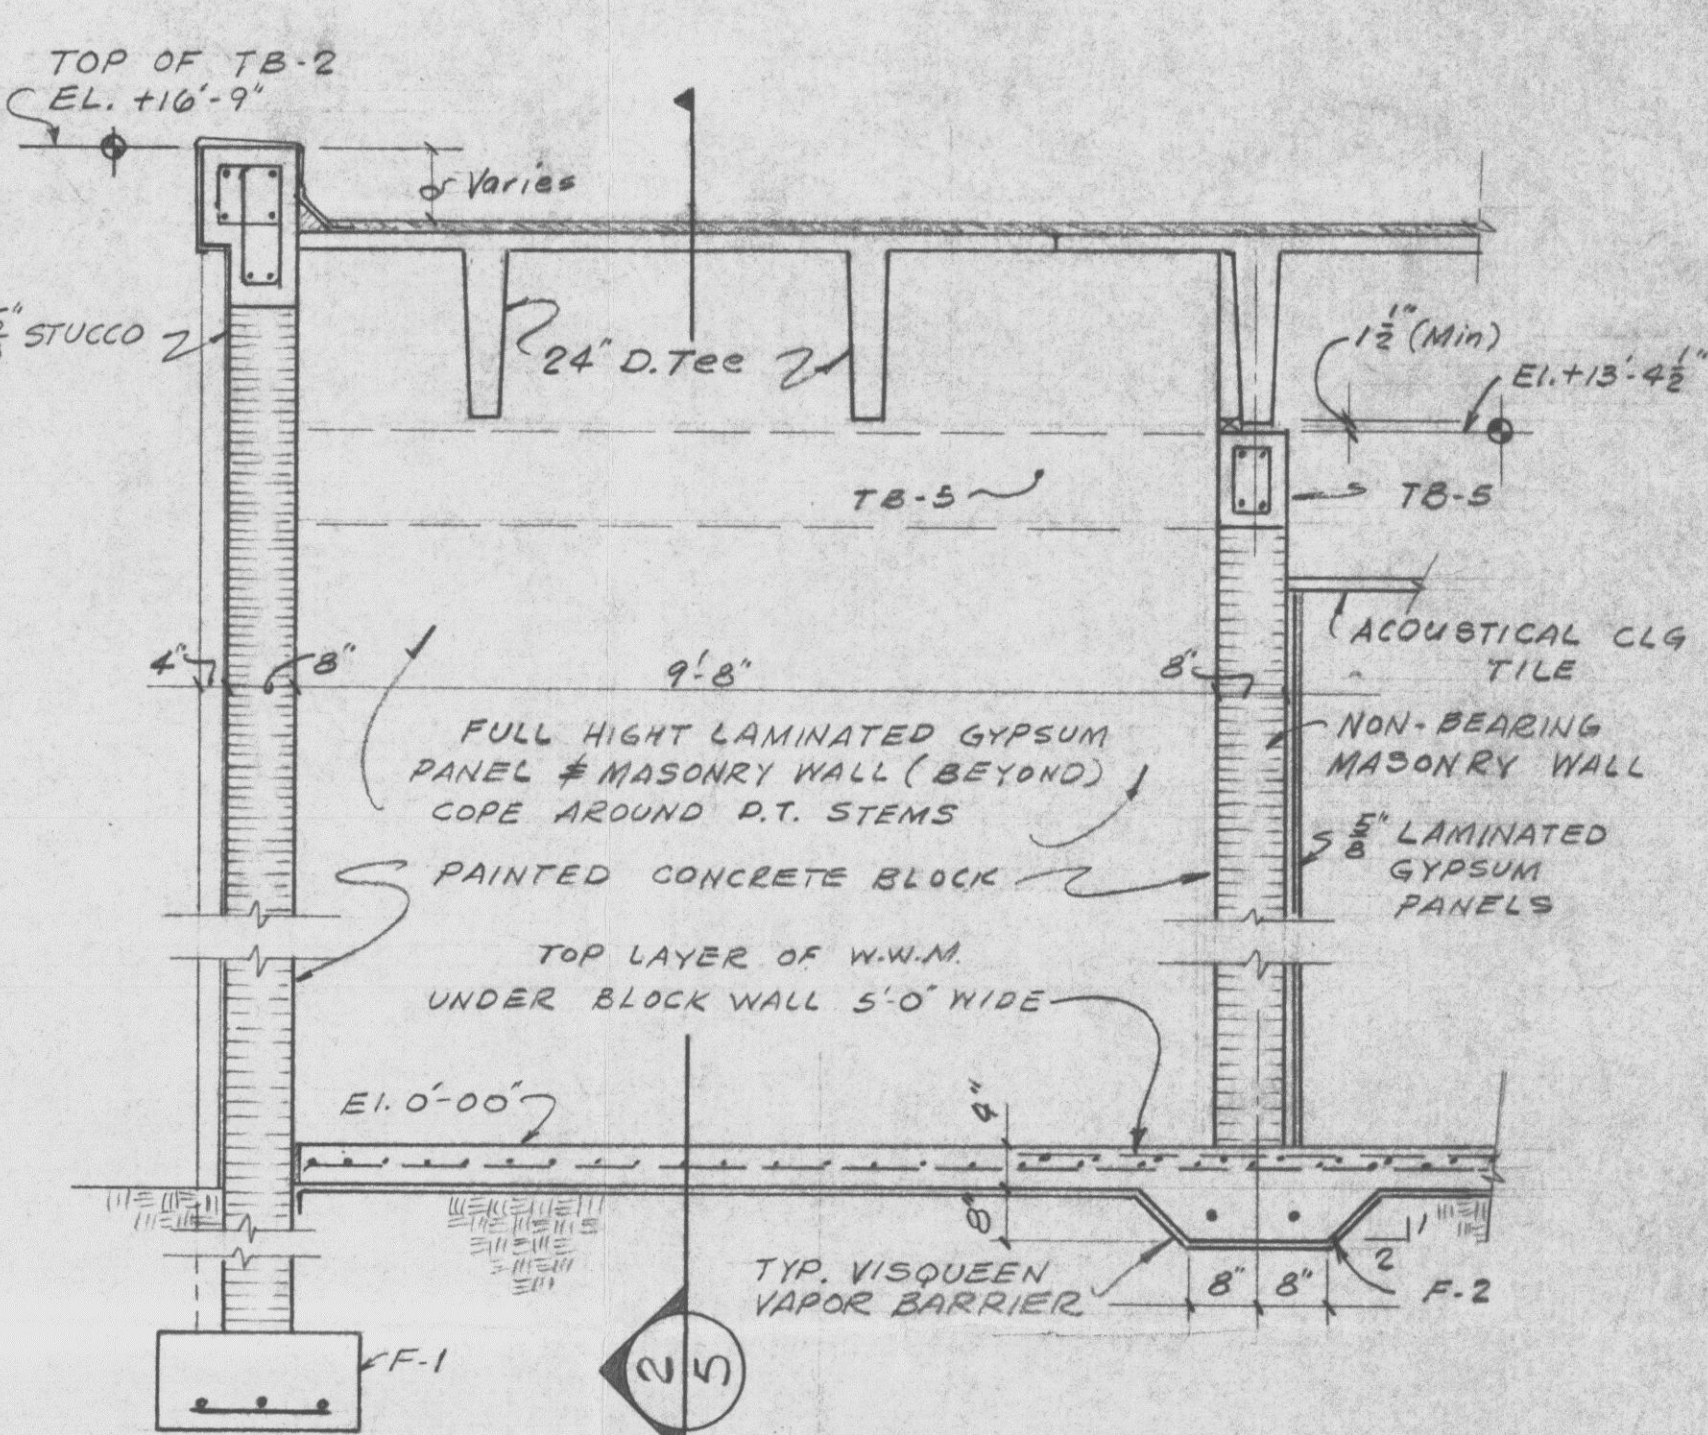

SECTION AT TELEPHONE AND ELECTRICAL ROOM

SCALE: 1/8" = 1'-0"

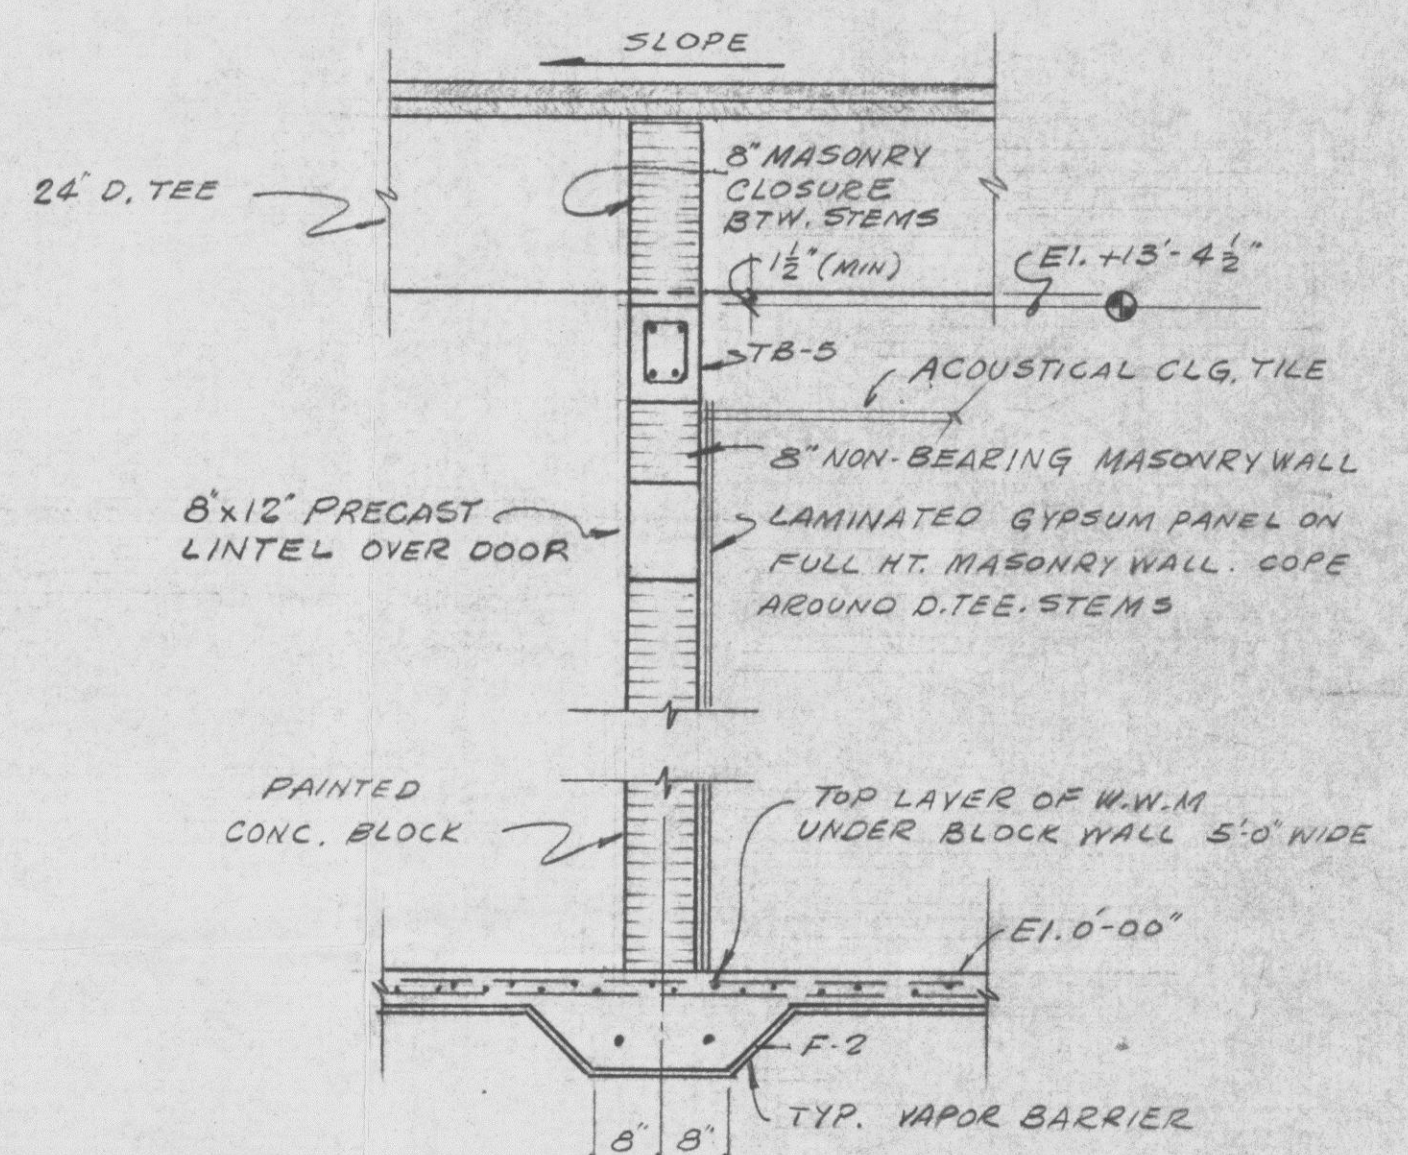

SECTION AT TELEPHONE AND ELECTRICAL ROOM

LEGEND

WALLS TO CONTAIN USG THERMAFIBER INSULATION "FULL THICKNESS"

PRC APERTURE CARD

Revised 4/80-335
Control 4/80-335-43
Date 12/8/82 of Document
REGULATORY DOCKET FILE

DATE 9/20/82 SCALE 0

DR MM ER NO. 4287
CH MW COR 44
APPROVED
A. B. Jabali

PSL
EMERGENCY OPERATIONS FACILITY
FLOOR PLAN & DETAILS

(SLP, A, -)
Sheet 5
8770-G-789
REV. NO.

AUTH	NO.	DATE	REVISION	BY	CH	COR	APP	AUTH	NO.	DATE	REVISION	BY	CH	COR	APP

8201030247 E