


B-324

SI
APERTURE
CARD

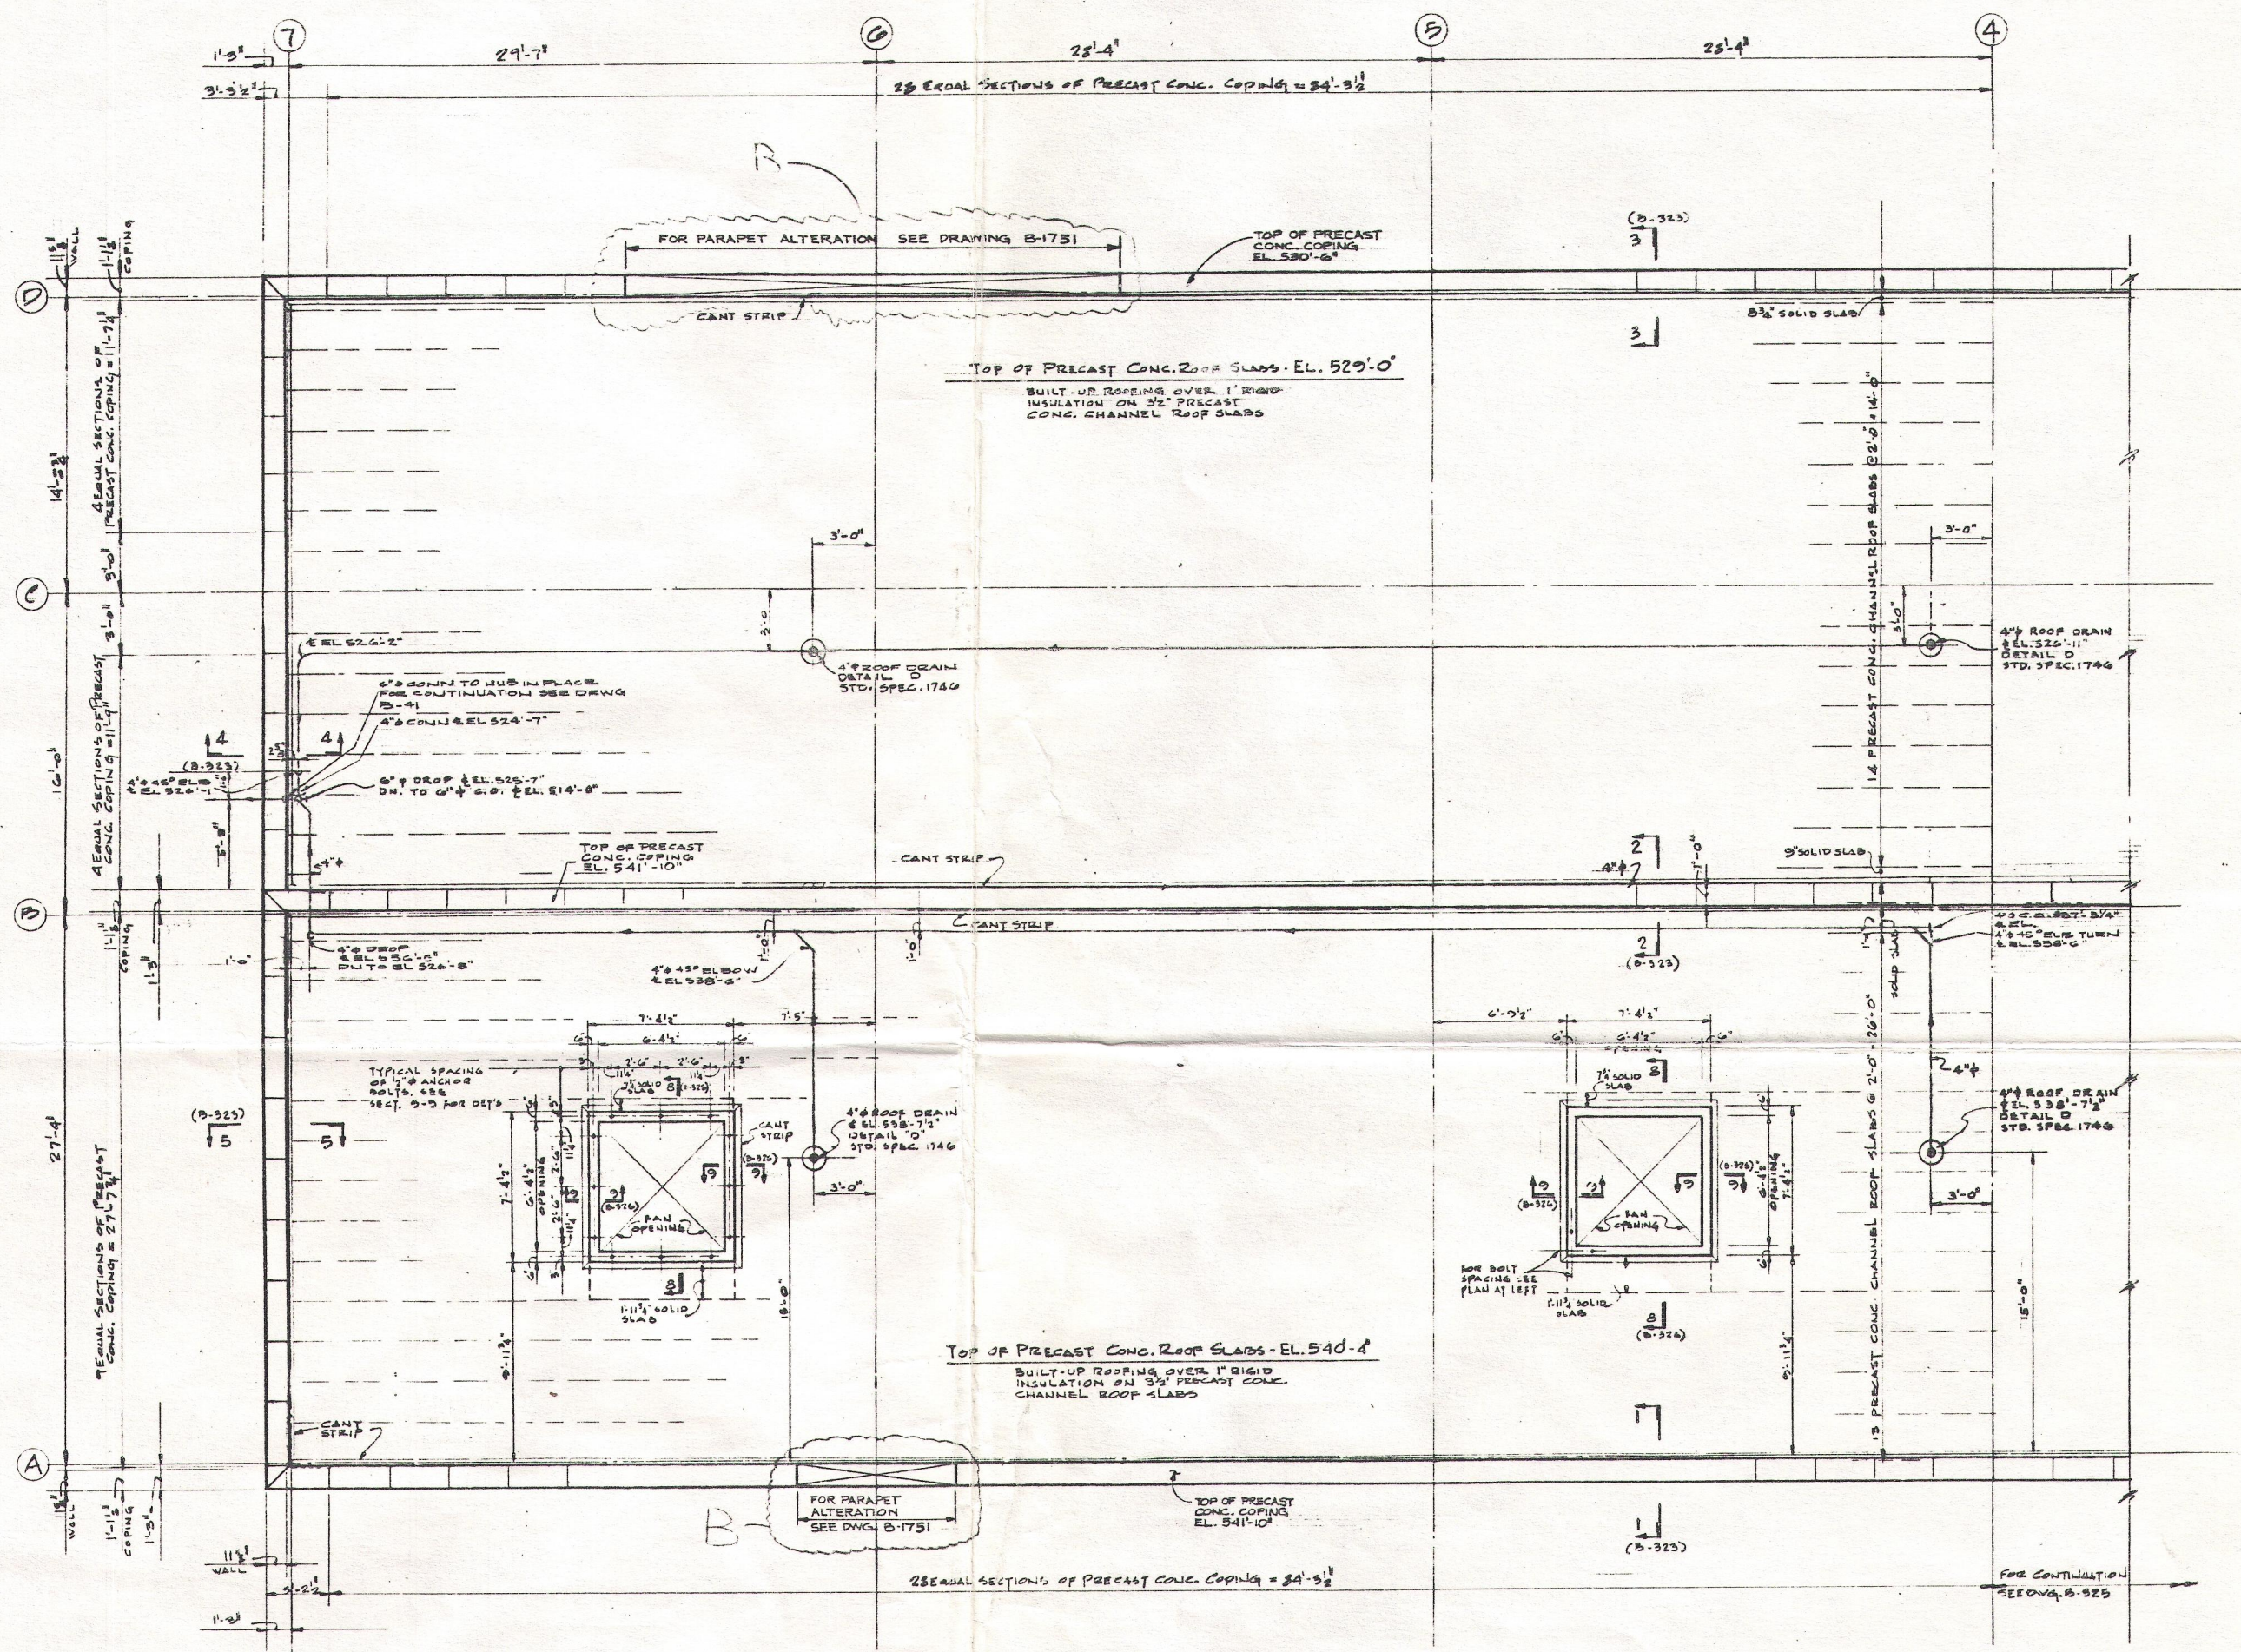

CRIB HOUSE ROOF PLAN - WEST AREA

NOTES

1. FOR NOTES SEE DWG. B-310

REFERENCE DRAWINGS

FOR REFERENCE DRAWINGS SEE DWG. B-310

SI
APERTURE
CARD



ANY MODIFICATION OR ADDITION TO THIS DRAWING BY AN ORGANIZATION OTHER THAN SARGENT & LUNDY IS NOT THE RESPONSIBILITY OF SARGENT & LUNDY.

DRAWING RELEASE RECORD				
REV	DATE RELEASED	PURPOSE	PREPARED	APPROVED
B	1-11-88	FOR RECORD AND NO. 5589-04	RENTON	R.A. HANCOCK
B	1-29-88	SENT TO CLIENT	R. HANCOCK	R. HANCOCK



REVISIONS	
1	REVISIONS
2	REVISIONS
3	REVISIONS
4	REVISIONS
5	REVISIONS
6	REVISIONS
7	REVISIONS
8	REVISIONS
9	REVISIONS
10	REVISIONS

CRIB HOUSE
ROOF PLAN WEST AREA

DRESDEN NUCLEAR POWER STATION
UNIT 2 & 3
GENERAL ELECTRIC CO.
COMMONWEALTH EDISON CO.
CHICAGO, ILLINOIS

SARGENT & LUNDY
INCORPORATED
ENGINEERS
CHICAGO

SCALE: 1/8" = 1'-0"
DRAWN: C. BAUMGARTNER 5-7-66
CHECKED: C. BAUMGARTNER 4-18-67
APPROVED: [Signature] 5-27-67
JOB NO. 5441 5585

DRAWING NUMBER: **B-324**

50-237
w/let dtk 8/30/89
#8909050464