
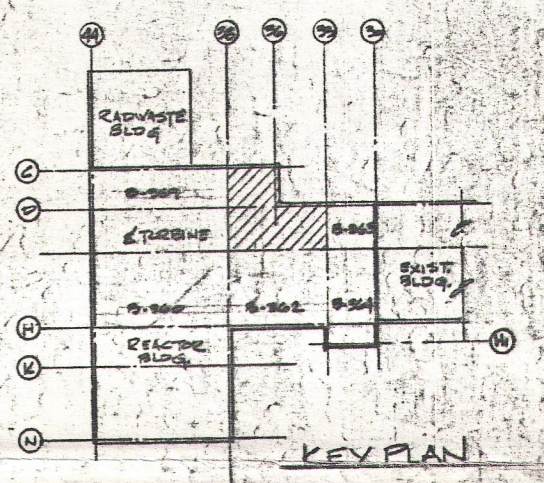


SI
APERTURE
CARD

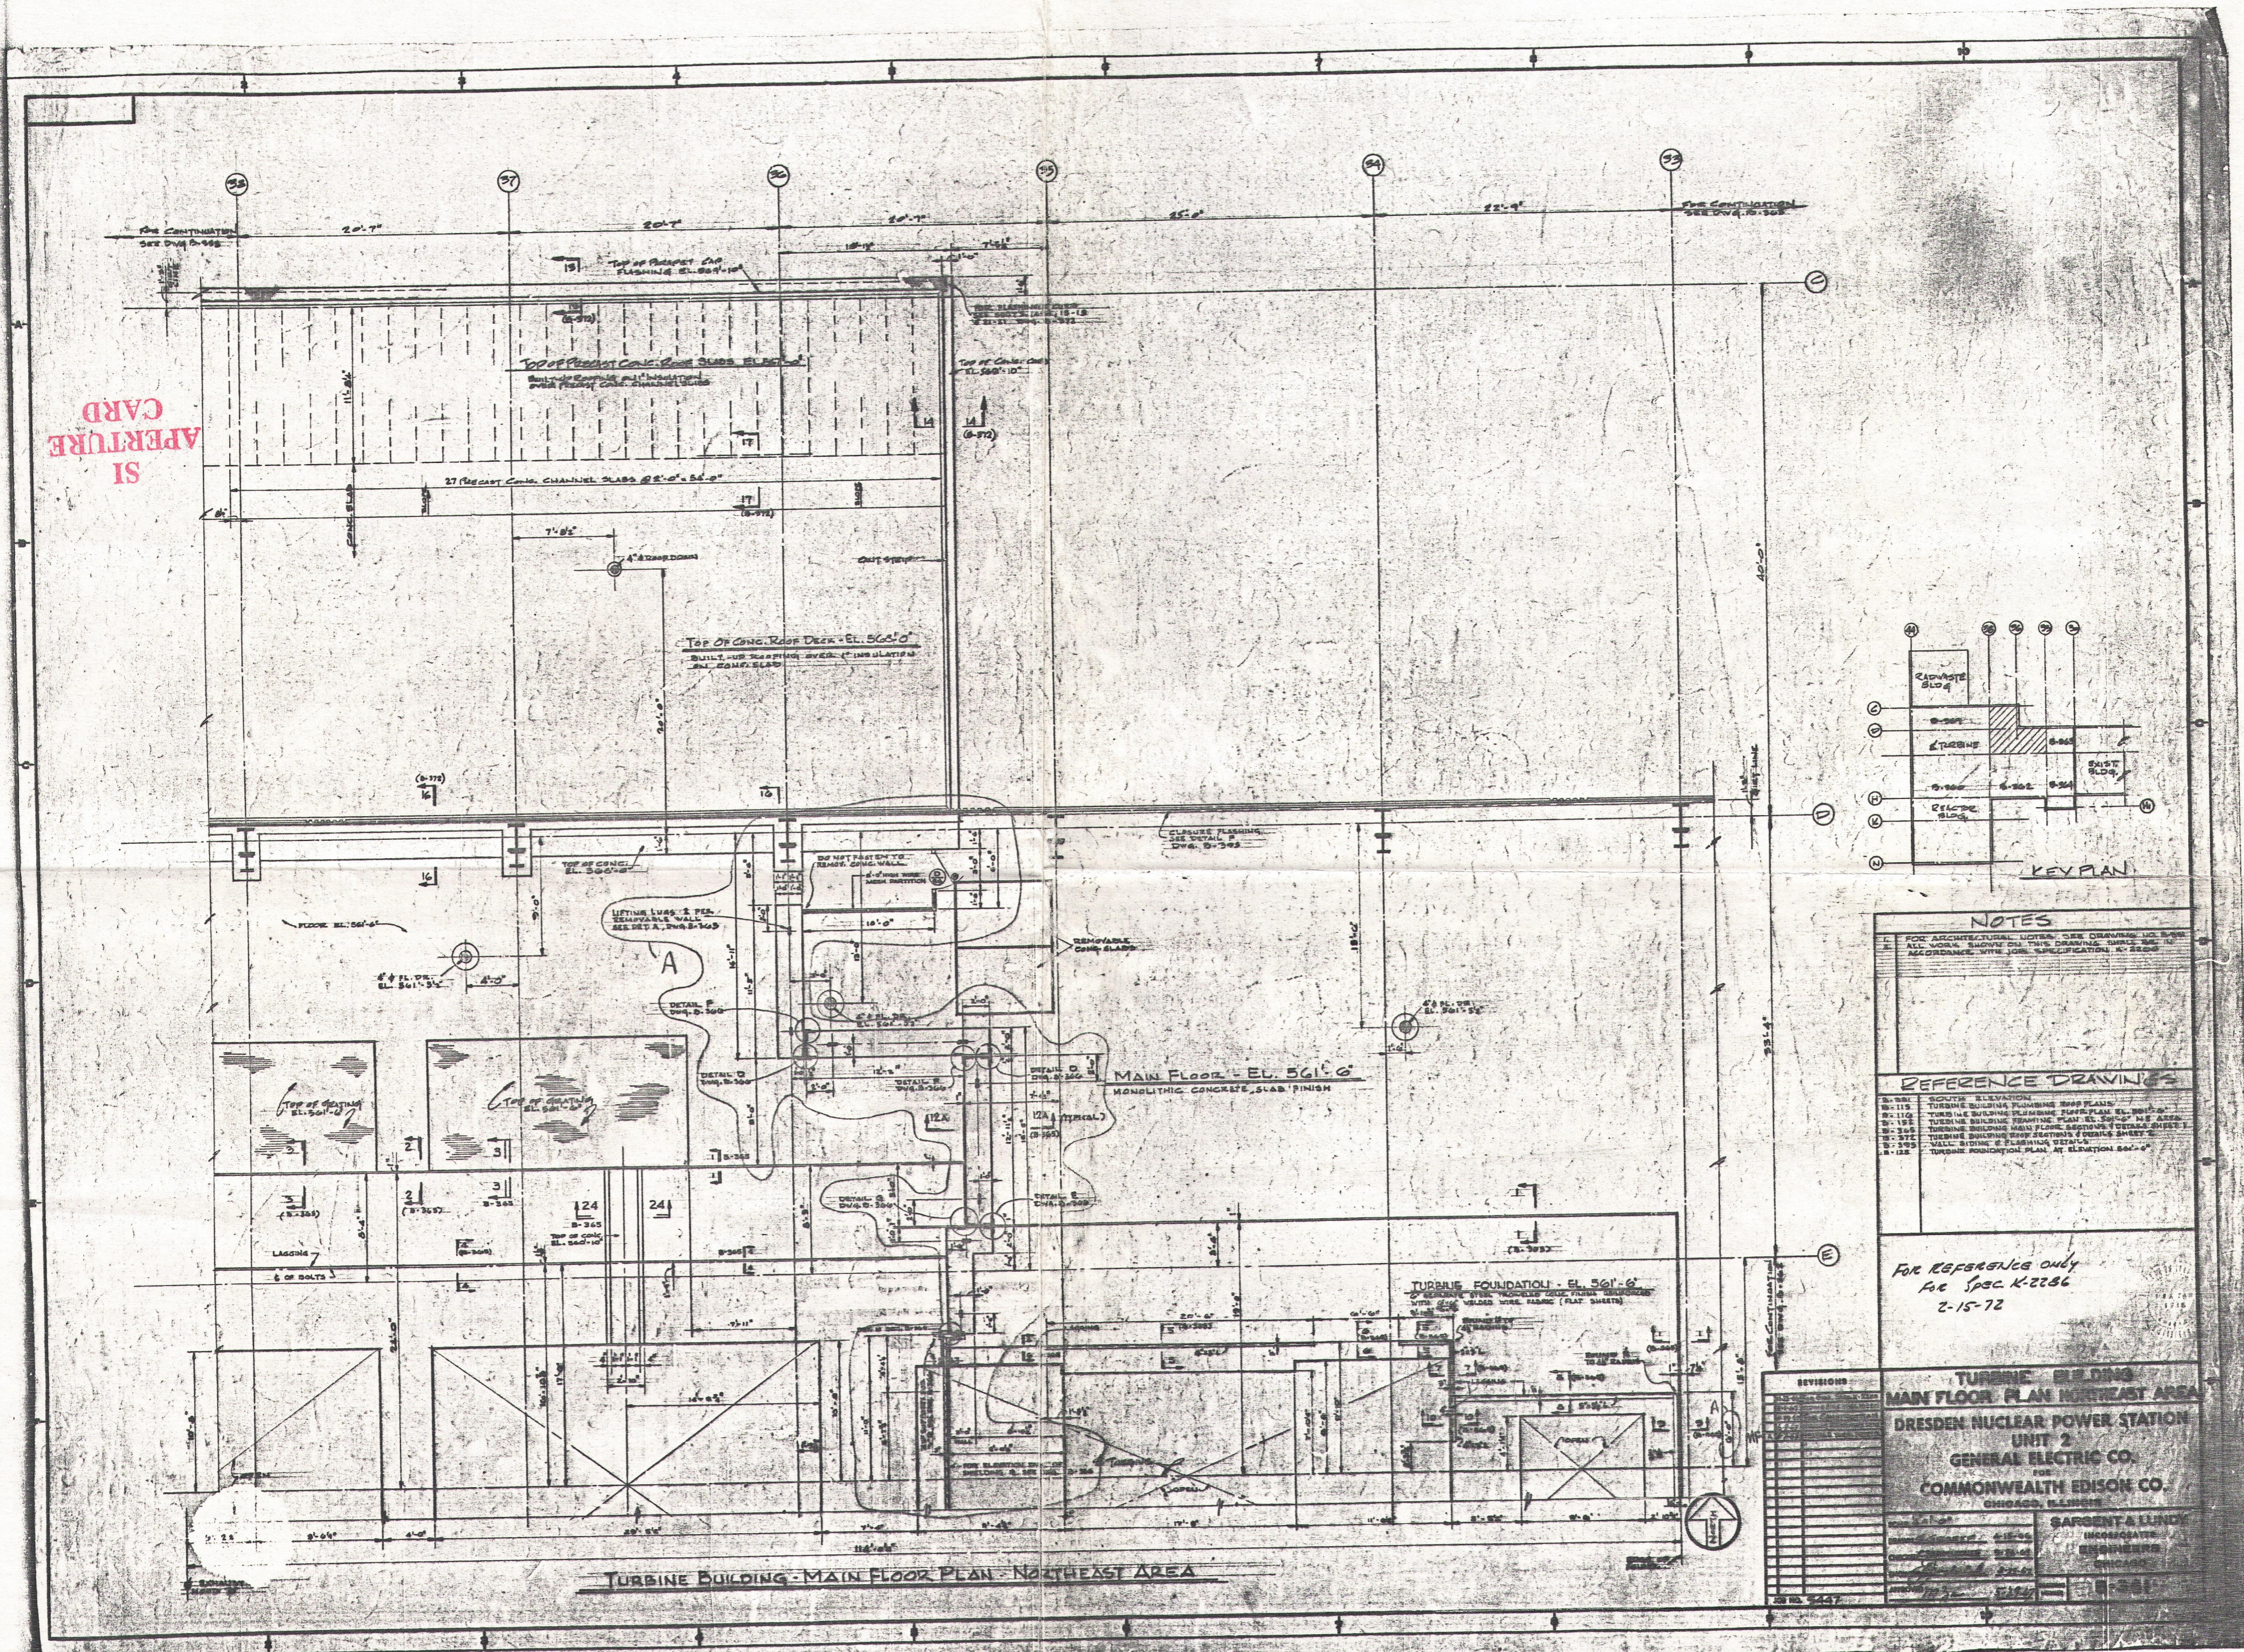

NOTES

1. FOR ARCHITECTURAL NOTES, SEE DRAWING NO. 2000
 2. ALL WORK SHOWN ON THIS DRAWING SHALL BE ACCORDANCE WITH JOB SPECIFICATION K-2286

REFERENCE DRAWINGS

2-100	SCOUTE ELEVATION
2-110	TURBINE BUILDING PLUMBING SHOP PLAN
2-115	TURBINE BUILDING PLUMBING SHOP PLAN EL. 561'-6"
2-120	TURBINE BUILDING PLUMBING SHOP PLAN EL. 561'-6" (SEE ARCH)
2-125	TURBINE BUILDING MAIN FLOOR ELEVATION & DETAILS SHEET 1
2-130	TURBINE BUILDING MAIN FLOOR ELEVATION & DETAILS SHEET 2
2-135	WALL SIDING & PLUMBING DETAILS
2-140	TURBINE FOUNDATION PLAN AT ELEVATION 561'-6"

For Reference only
 See Spec K-2286
 2-15-72

REVISIONS

1	ISSUED FOR PERMIT	11-15-71	WLB
2	ISSUED FOR CONSTRUCTION	1-15-72	WLB
3	ISSUED FOR CONSTRUCTION	2-15-72	WLB
4	ISSUED FOR CONSTRUCTION	2-15-72	WLB
5	ISSUED FOR CONSTRUCTION	2-15-72	WLB
6	ISSUED FOR CONSTRUCTION	2-15-72	WLB
7	ISSUED FOR CONSTRUCTION	2-15-72	WLB
8	ISSUED FOR CONSTRUCTION	2-15-72	WLB
9	ISSUED FOR CONSTRUCTION	2-15-72	WLB
10	ISSUED FOR CONSTRUCTION	2-15-72	WLB
11	ISSUED FOR CONSTRUCTION	2-15-72	WLB
12	ISSUED FOR CONSTRUCTION	2-15-72	WLB
13	ISSUED FOR CONSTRUCTION	2-15-72	WLB
14	ISSUED FOR CONSTRUCTION	2-15-72	WLB
15	ISSUED FOR CONSTRUCTION	2-15-72	WLB
16	ISSUED FOR CONSTRUCTION	2-15-72	WLB
17	ISSUED FOR CONSTRUCTION	2-15-72	WLB
18	ISSUED FOR CONSTRUCTION	2-15-72	WLB
19	ISSUED FOR CONSTRUCTION	2-15-72	WLB
20	ISSUED FOR CONSTRUCTION	2-15-72	WLB
21	ISSUED FOR CONSTRUCTION	2-15-72	WLB
22	ISSUED FOR CONSTRUCTION	2-15-72	WLB
23	ISSUED FOR CONSTRUCTION	2-15-72	WLB
24	ISSUED FOR CONSTRUCTION	2-15-72	WLB
25	ISSUED FOR CONSTRUCTION	2-15-72	WLB
26	ISSUED FOR CONSTRUCTION	2-15-72	WLB
27	ISSUED FOR CONSTRUCTION	2-15-72	WLB
28	ISSUED FOR CONSTRUCTION	2-15-72	WLB
29	ISSUED FOR CONSTRUCTION	2-15-72	WLB
30	ISSUED FOR CONSTRUCTION	2-15-72	WLB
31	ISSUED FOR CONSTRUCTION	2-15-72	WLB
32	ISSUED FOR CONSTRUCTION	2-15-72	WLB
33	ISSUED FOR CONSTRUCTION	2-15-72	WLB
34	ISSUED FOR CONSTRUCTION	2-15-72	WLB
35	ISSUED FOR CONSTRUCTION	2-15-72	WLB
36	ISSUED FOR CONSTRUCTION	2-15-72	WLB
37	ISSUED FOR CONSTRUCTION	2-15-72	WLB
38	ISSUED FOR CONSTRUCTION	2-15-72	WLB
39	ISSUED FOR CONSTRUCTION	2-15-72	WLB
40	ISSUED FOR CONSTRUCTION	2-15-72	WLB
41	ISSUED FOR CONSTRUCTION	2-15-72	WLB
42	ISSUED FOR CONSTRUCTION	2-15-72	WLB
43	ISSUED FOR CONSTRUCTION	2-15-72	WLB
44	ISSUED FOR CONSTRUCTION	2-15-72	WLB
45	ISSUED FOR CONSTRUCTION	2-15-72	WLB
46	ISSUED FOR CONSTRUCTION	2-15-72	WLB
47	ISSUED FOR CONSTRUCTION	2-15-72	WLB
48	ISSUED FOR CONSTRUCTION	2-15-72	WLB
49	ISSUED FOR CONSTRUCTION	2-15-72	WLB
50	ISSUED FOR CONSTRUCTION	2-15-72	WLB

**TURBINE BUILDING
 MAIN FLOOR PLAN - NORTHEAST AREA
 DRESDEN NUCLEAR POWER STATION
 UNIT 2
 GENERAL ELECTRIC CO.
 COMMONWEALTH EDISON CO.
 CHICAGO, ILLINOIS**

SARGENT & LUNDY
 INCORPORATED
 ENGINEERS
 CHICAGO

30X S.L. 50-237
 WLB dhl 8/30/89
 # 8909050464

SI
 APERTURE
 CARD