


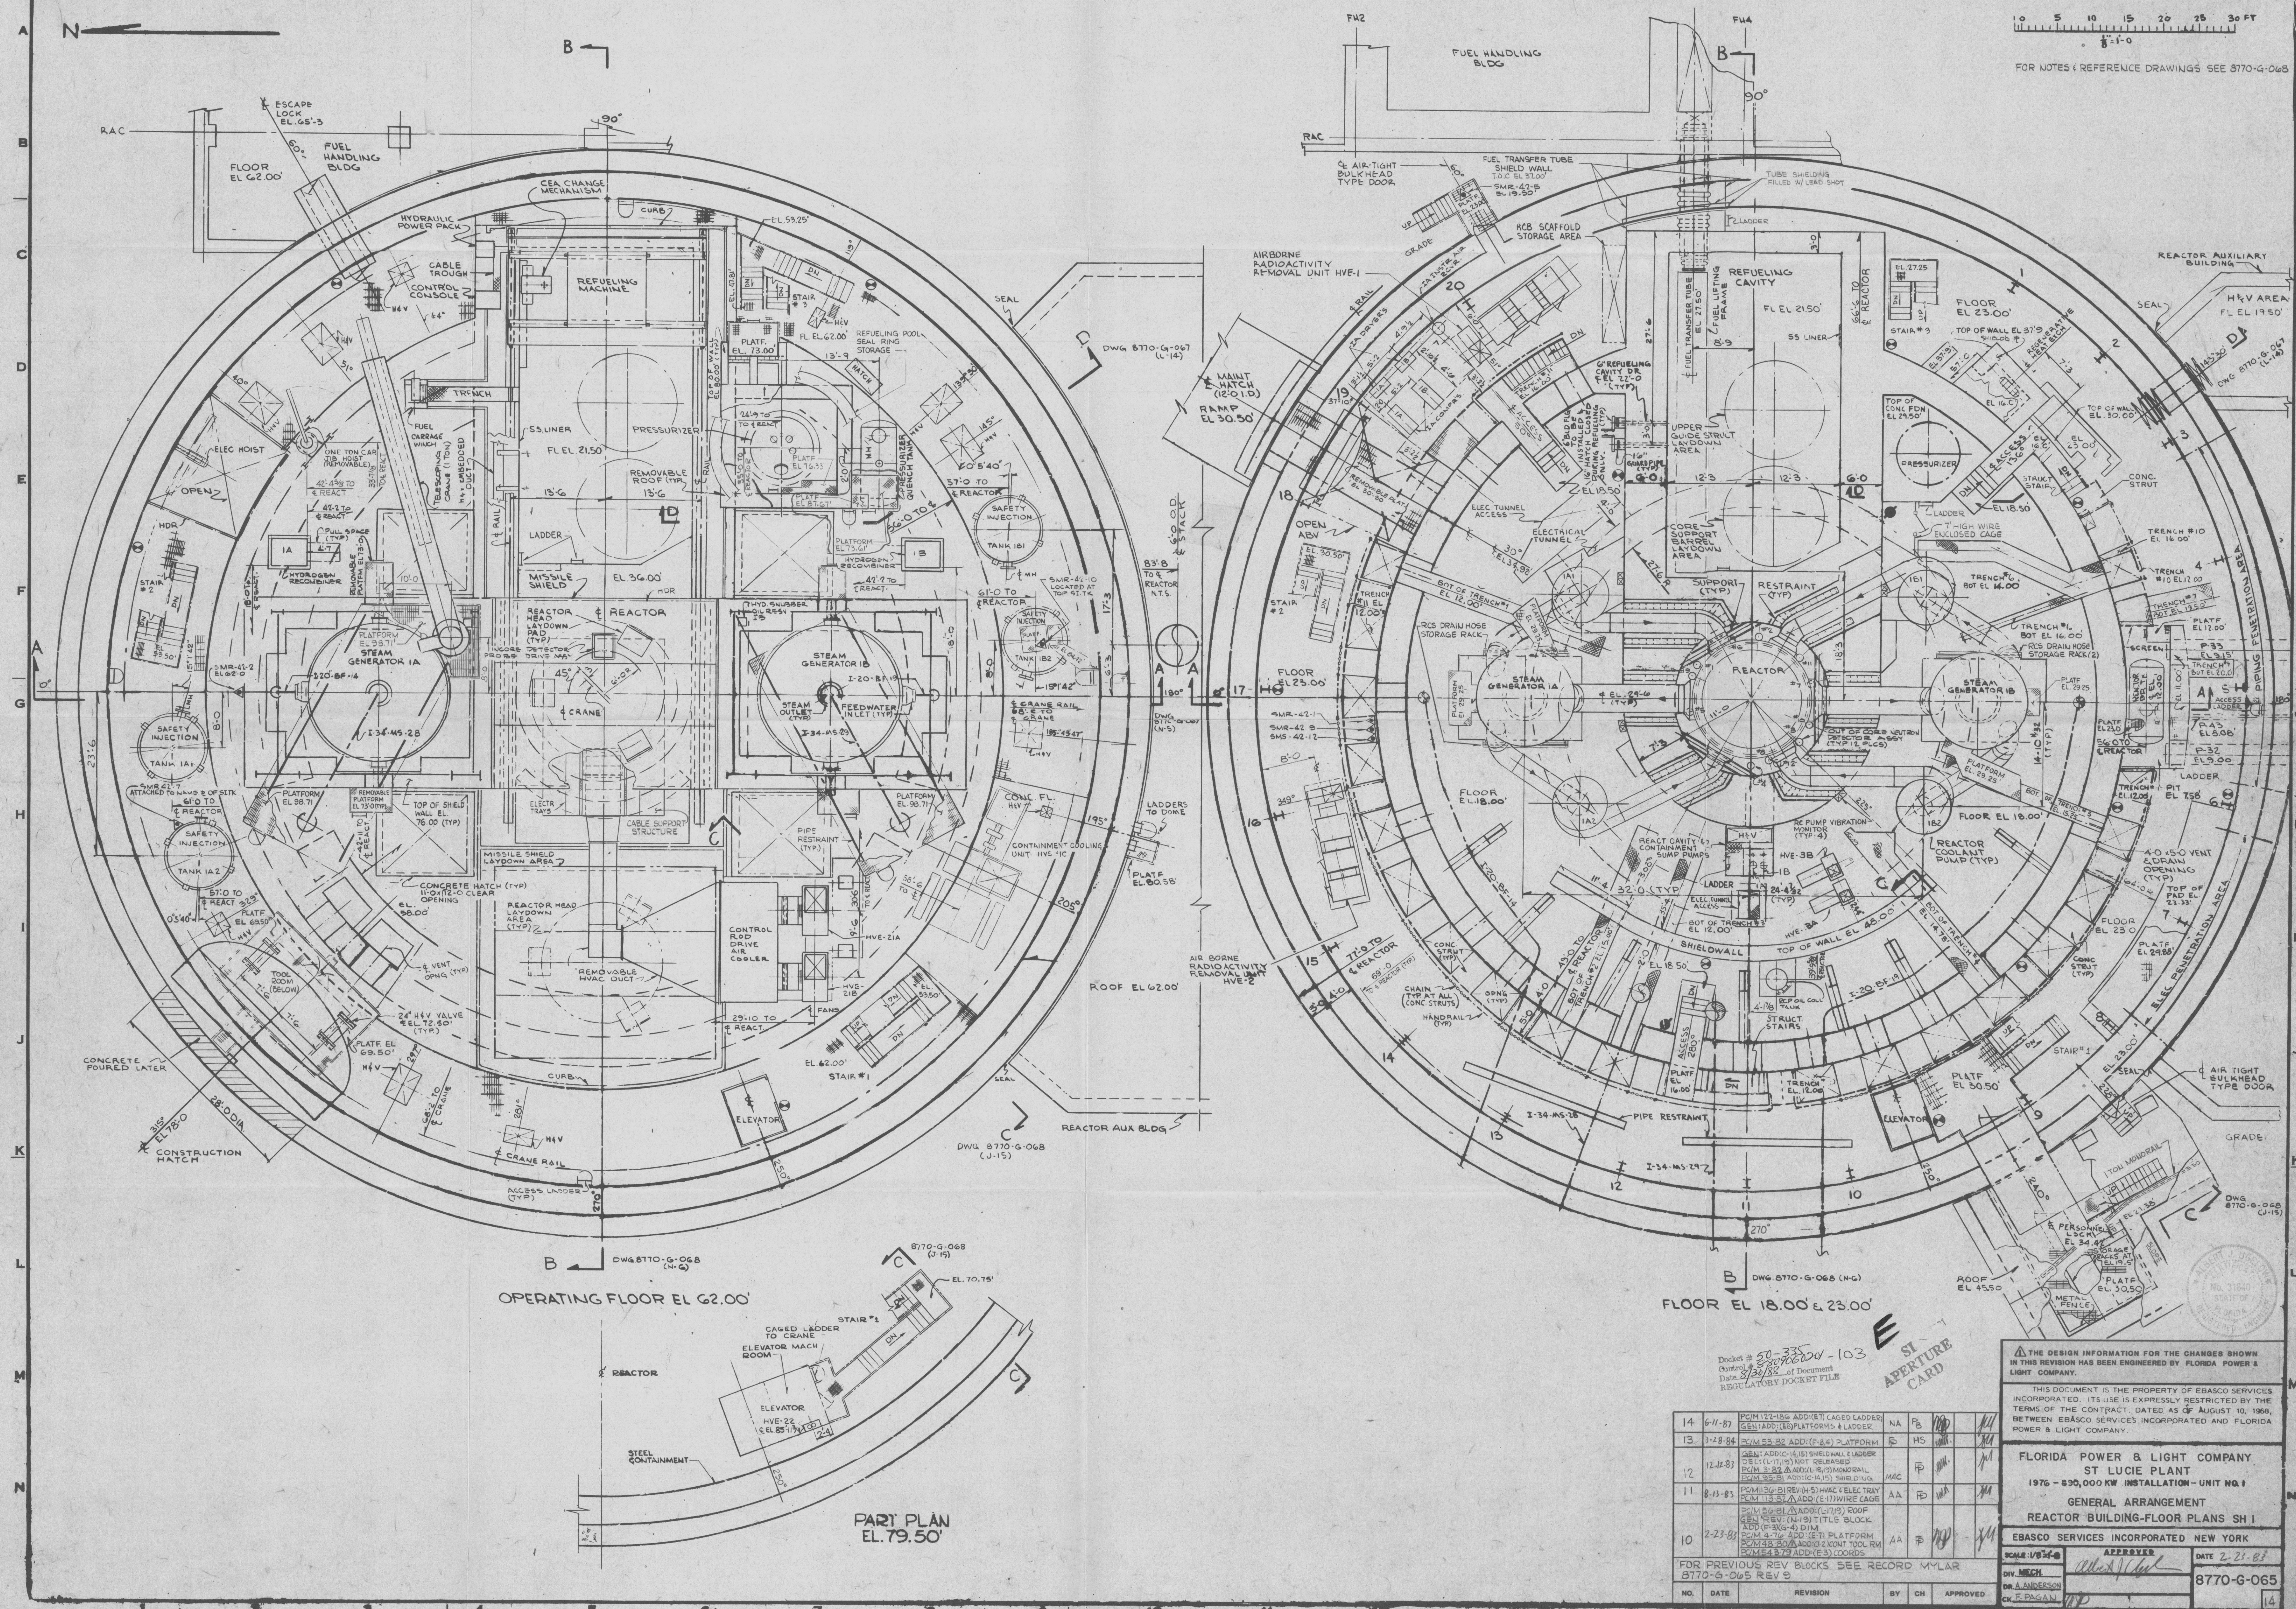

Docket # 50-335
 Drawing
 Date 8/20/88 of Document
 REGULATORY DOCKET FILE

ST
 APERTURE
 CARD

14	6-11-87	PC/M 122-186 ADD (E) CAGED LADDER GEN ADD (E) PLATFORMS & LADDER	NA	B	NA	NA
13	3-18-84	PC/M 55-82 ADD (F-3) PLATFORM	NA	HS	NA	NA
12	12-11-83	GEN ADD (C-14) SHIELD WALL & LADDER DEL (C-17) NOT RELEASED PC/M 3-82 ADD (H-10) MONITORIAL PC/M 92-28 ADD (C-14) SHIELDING	NA	CP	NA	NA
11	8-13-83	PC/M 136-B REV (H-5) HVAC ELECTRICAL PC/M 113-87 ADD (E-17) WIRE CAGE PC/M 6-8 (ADD) (L-17) ROOF GEN ADD (H-10) TITLES BLOCK ADD (F-3) (G-4) DIM	AA	PD	NA	NA
10	2-23-83	PC/M 1-76 ADD (E-17) PLATFORM PC/M 3-80 ADD (E-17) CONT. TOOL RM PC/M 4-79 ADD (E-3) COORDS	AA	B	NA	NA

FOR PREVIOUS REV BLOCKS SEE RECORD MYLAR
 8770-G-065 REV 9

THE DESIGN INFORMATION FOR THE CHANGES SHOWN
 IN THIS REVISION HAS BEEN ENGINEERED BY FLORIDA POWER &
 LIGHT COMPANY.

THIS DOCUMENT IS THE PROPERTY OF EBASCO SERVICES
 INCORPORATED. ITS USE IS EXPRESSLY RESTRICTED BY THE
 TERMS OF THE CONTRACT, DATED AS OF AUGUST 10, 1968,
 BETWEEN EBASCO SERVICES, INCORPORATED AND FLORIDA
 POWER & LIGHT COMPANY.

FLORIDA POWER & LIGHT COMPANY
 ST LUCIE PLANT
 1976 - 830,000 KW INSTALLATION - UNIT NO. 1
 GENERAL ARRANGEMENT
 REACTOR BUILDING - FLOOR PLANS SH. 1

EBASCO SERVICES INCORPORATED NEW YORK

SCALE: 1/8" = 1'-0"

APPROVED

DATE 2-21-88

8770-G-065