


DRAWING NUMBER
8770-G-066


DRAWING NUMBER
8770-G-066

DRAWING NUMBER
8770-G-066

8770-G-066

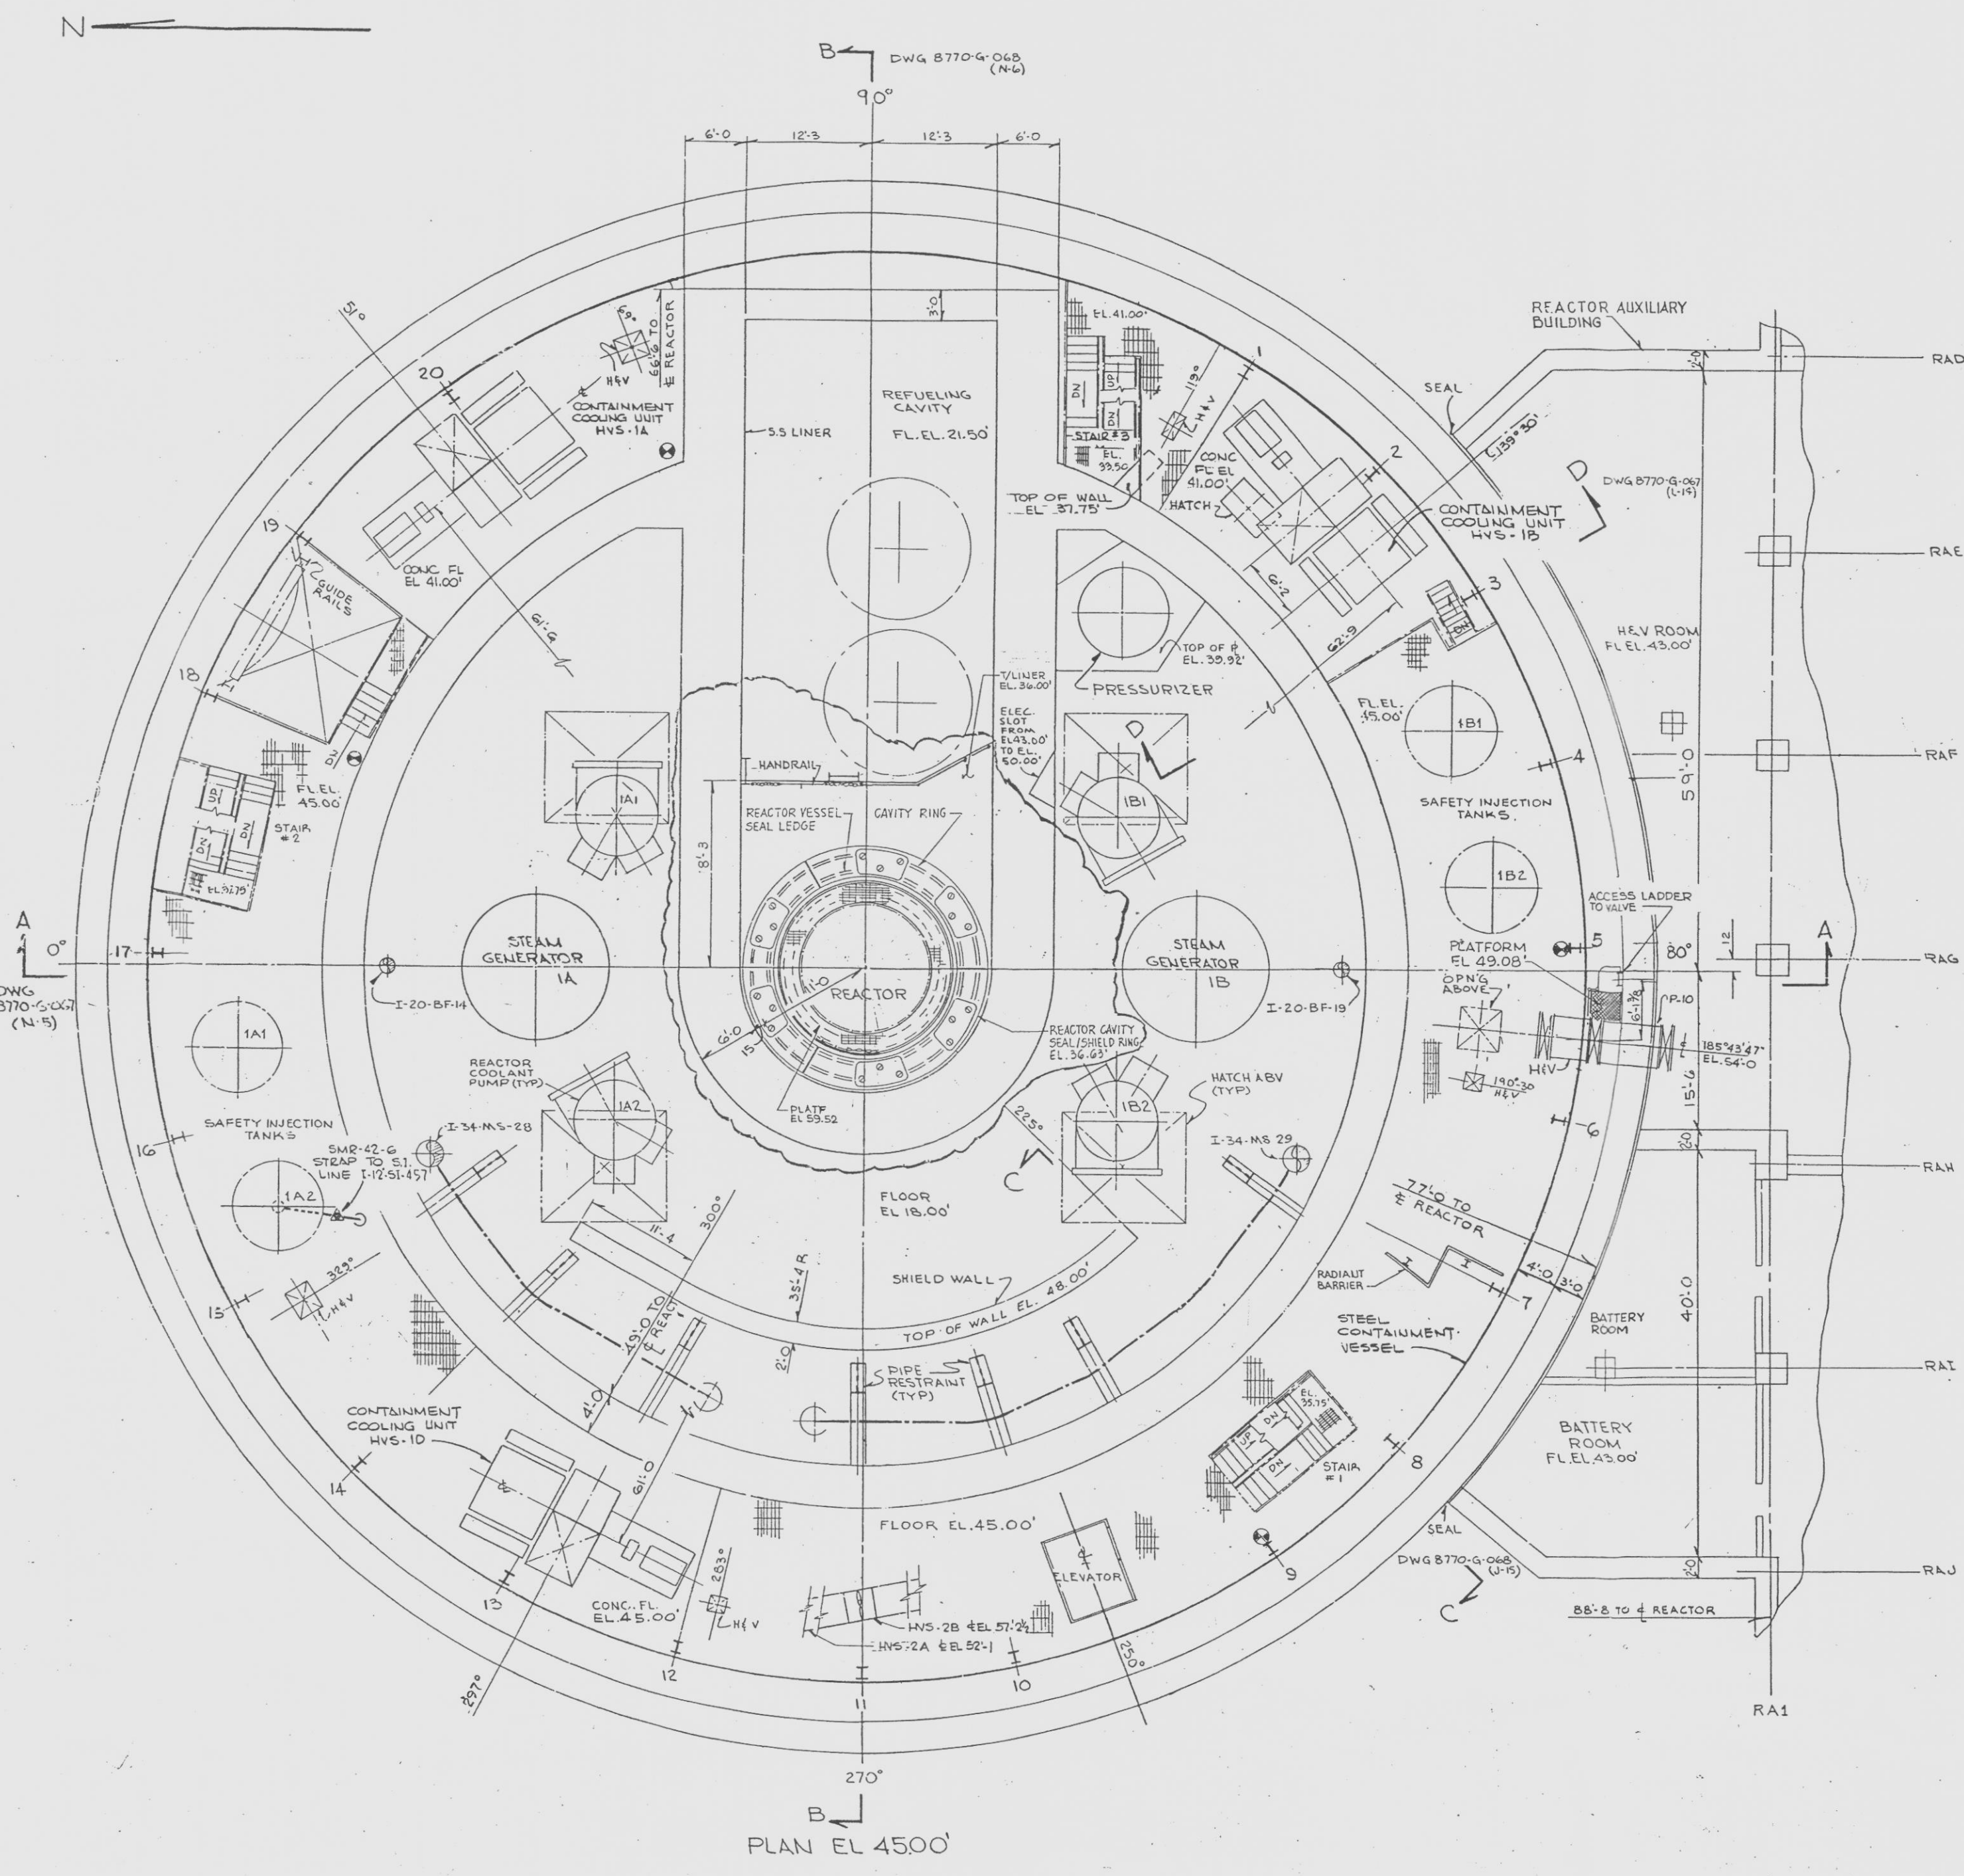

NOTE
FOR NOTES & REFERENCE DRAWINGS SEE 8770-G-068

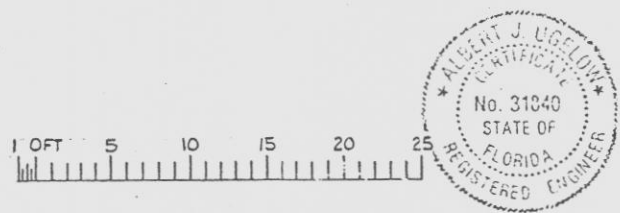

RECEIVED APR 20 1985 NUCLEAR RECORDS DOCUMENT CONTROL CENTER		THE DESIGN INFORMATION FOR THE CHANGES SHOWN IN THIS REVISION HAS BEEN ENGINEERED BY FLORIDA POWER & LIGHT COMPANY.	
THIS DOCUMENT IS THE PROPERTY OF EBASCO SERVICES INCORPORATED. ITS USE IS EXPRESSLY RESTRICTED BY THE TERMS OF THE CONTRACT, DATED AS OF AUGUST 16, 1968, BETWEEN EBASCO SERVICES INCORPORATED AND FLORIDA POWER & LIGHT COMPANY.			
FLORIDA POWER & LIGHT COMPANY ST LUCIE PLANT 1976 - 890,000 KW INSTALLATION - UNIT NO. 1 GENERAL ARRANGEMENT REACTOR BUILDING-FLOOR PLANS SH 2			
EBASCO SERVICES INCORPORATED NEW YORK		SCALE 1/8"=1'-0"	
APPROVED DIV. MECH. DI. ADJ. DESIGN CH. T. P. G. ADJ.		DATE 2-23-83 8770-G-066	
NO. DATE		REVISION	
BY CH. APPROVED			

9701270078-35

E