


108D803
SHEET 10

LOOP 1 REACTOR COOLANT FLOW

LOOP 2 REACTOR COOLANT FLOW

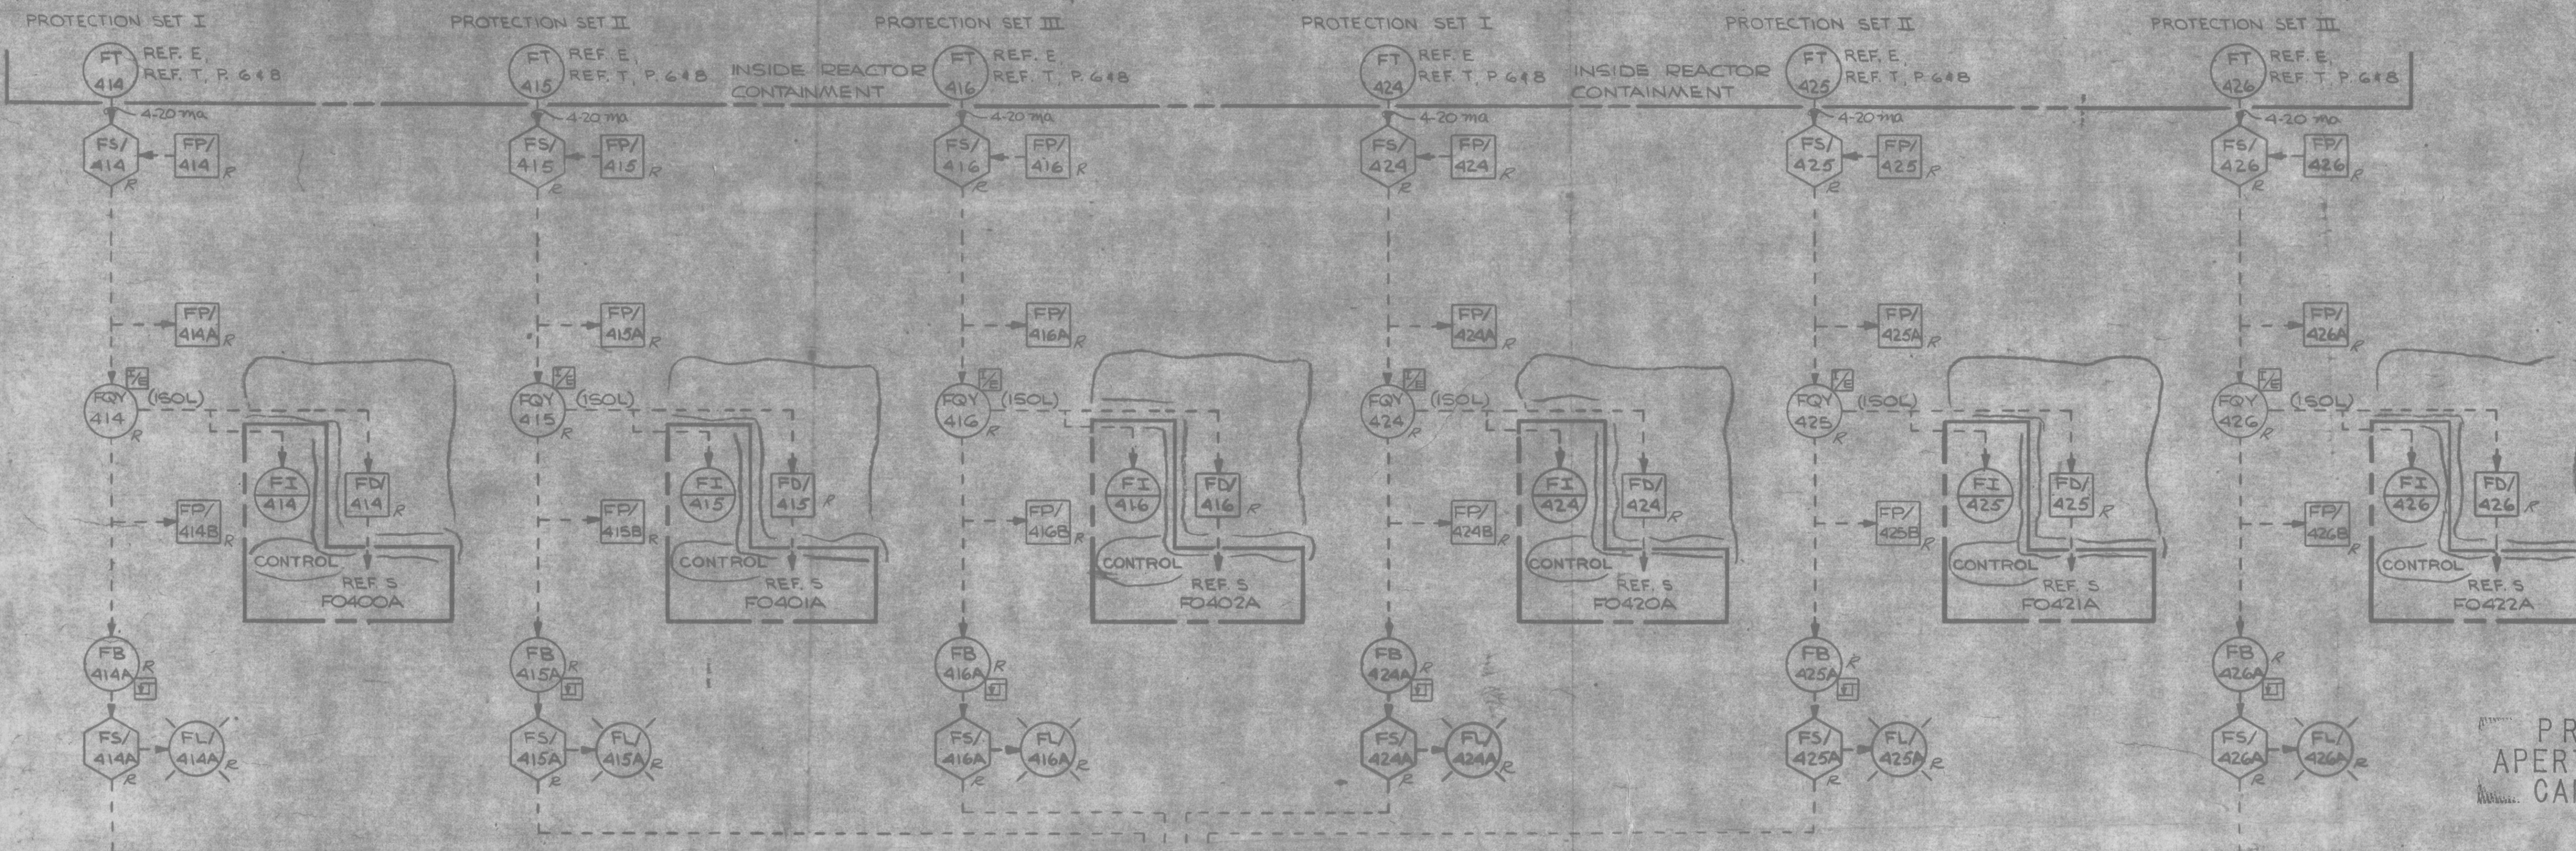

PRO
APERTURE
CARD

NOTES:
1. ALL ALPHA REFERENCES ON SHEET 1.

POOR ORIGINAL

DOCUMENT CONTROL
RECEIVED
JUN 17 1980
SHEARON HARRIS N.P.C.

CAROLINA POWER AND LIGHT COMPANY
PLANT: SHEARON HARRIS NUCLEAR POWER PLANT
UNIT: 1234
STATUS: APPROVED
CERTIFICATION LETTER NO. COL-5615
AUTHORITY: R. L. WHITNEY
ENGR. LTR. NO. EP/SA-26705

NO.	DATE	CHANGE
1	10/2/72	REVISION 1320
2	10/2/72	REVISION 1320
3	10/2/72	REVISION 1320
4	10/2/72	REVISION 1320
5	10/2/72	REVISION 1320
6	10/2/72	REVISION 1320
7	10/2/72	REVISION 1320
8	10/2/72	REVISION 1320
9	10/2/72	REVISION 1320
10	10/2/72	REVISION 1320
11	10/2/72	REVISION 1320

DESIGNER: K. SCHILLO	DATE: 10/2/72
CHKD: J. J. JONES	DATE: 10/2/72
MTLS. ENG: J. J. JONES	DATE: 10/2/72
APP: J. J. JONES	DATE: 10/2/72
DFTG. SUPV: J. J. JONES	DATE: 10/2/72
SCALE: 1/2" = 1'-0"	
DIMENSIONS IN INCHES	
DO NOT SCALE	
SUB: 1234	

Control # 50-100
Control # 50-1000000 - 60
Date 11/5/82 of document
REGULATORY DOCKET FILE

108-1328-7
108-1328-7
Uncontrolled Copy
FOR INFORMATION ONLY