

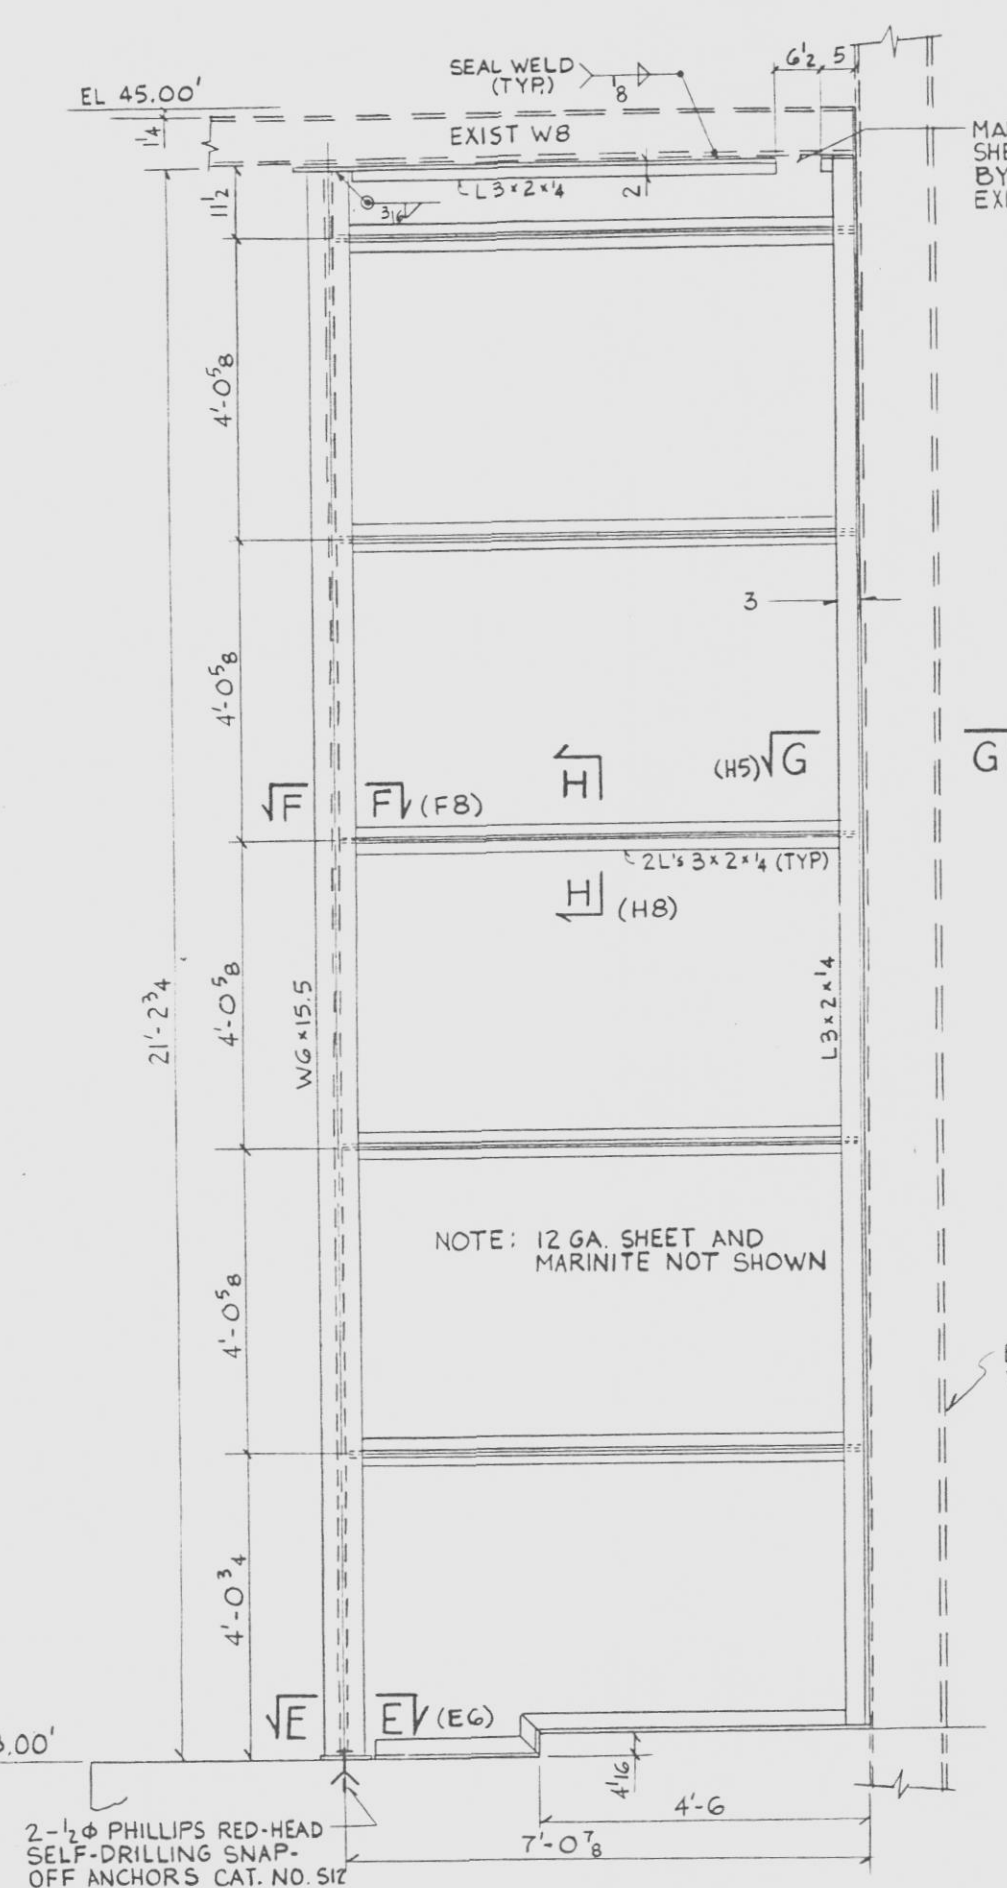



8770-G-814
SH. 9

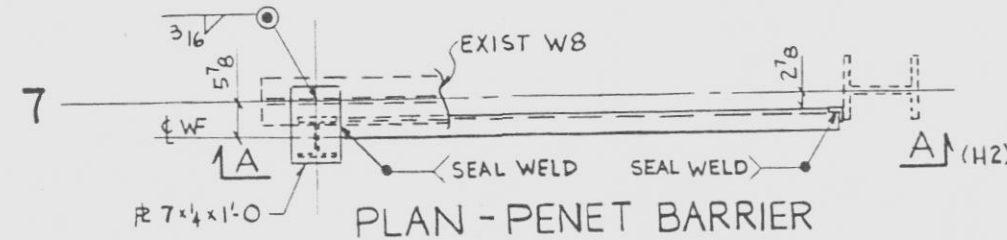


PLAN AT EL 43.00' - SUPPORT FRAMES FOR HVE 6A & 6B
3/4" = 1'-0"

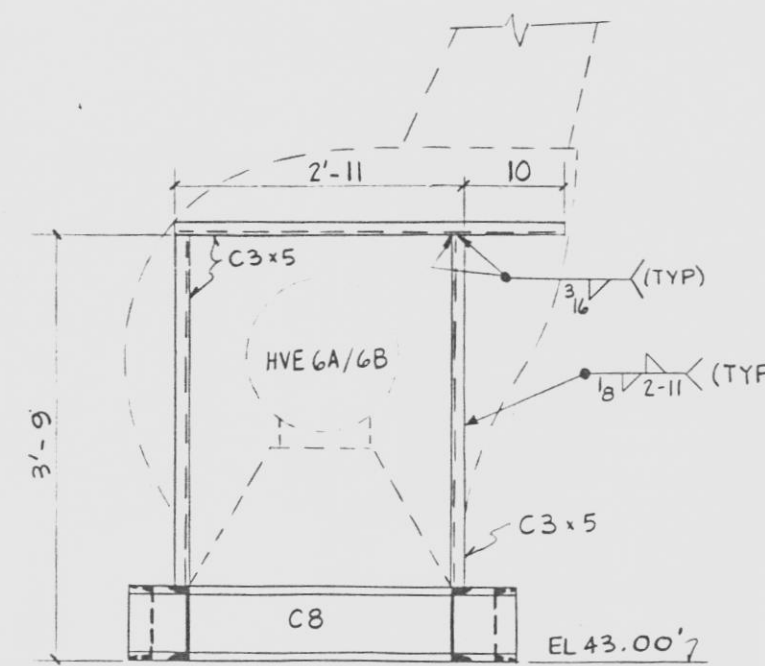


SECT B (C7)
3/4" = 1'-0"

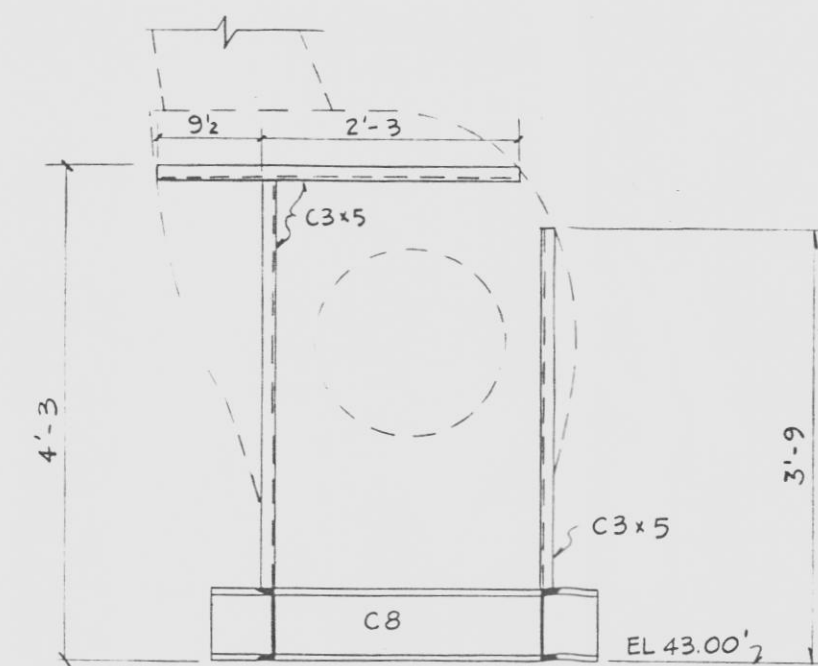


SECT C (B6)
3/4" = 1'-0"

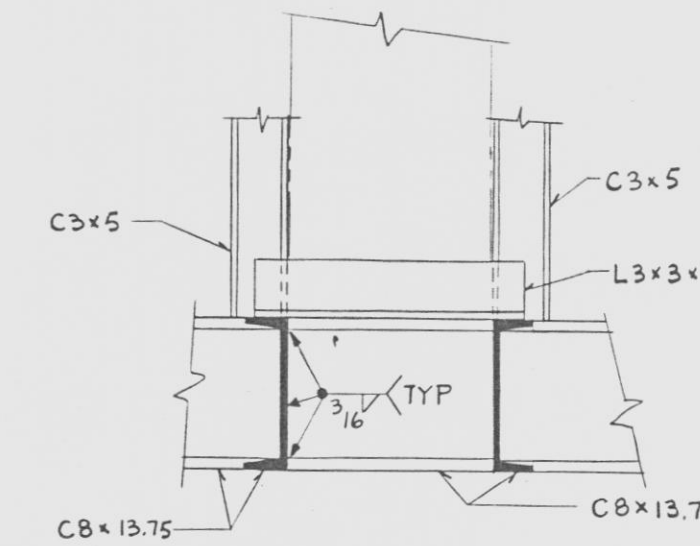


SECT D (B7, C7)
1/2" = 1'-0"

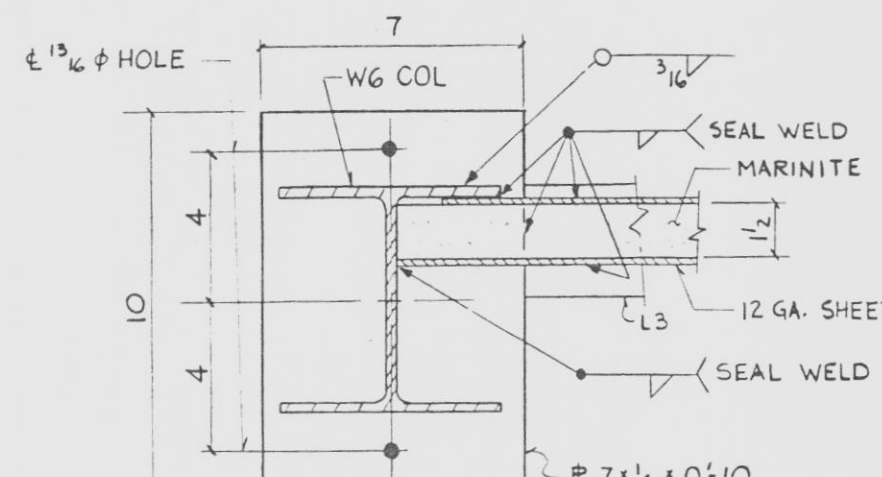


SECT E (H2)
3/4" = 1'-0"

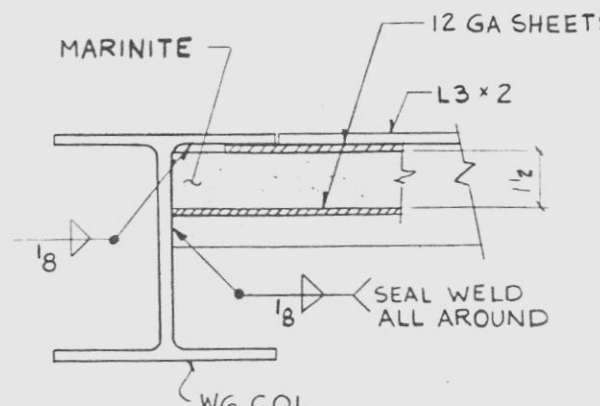


SECT F (D2)
3/4" = 1'-0"

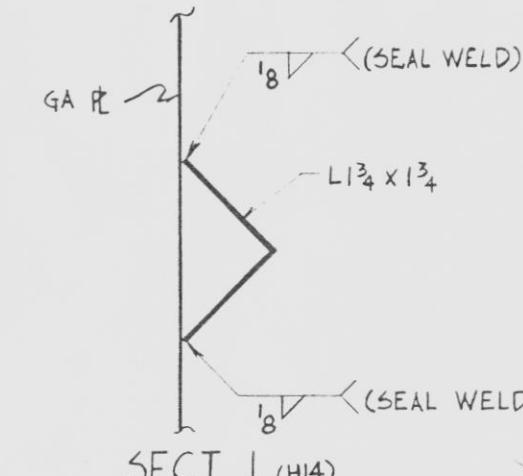


SECT L (H14)

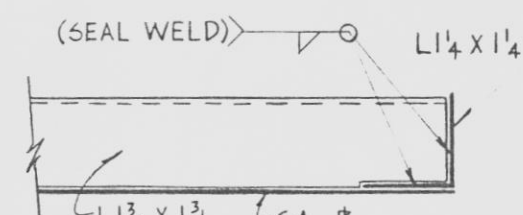


SECT M (H14)

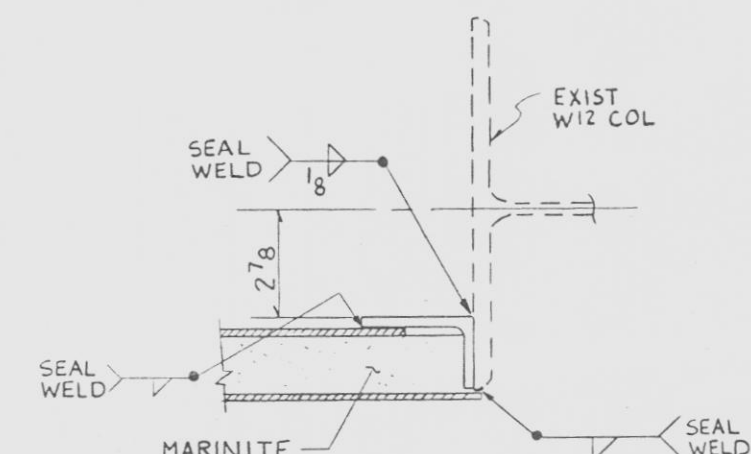

SECT G (D3)
3/4" = 1'-0"

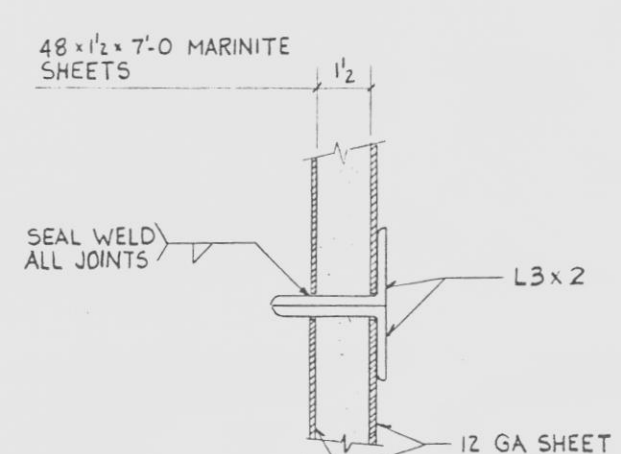

SECT H (E2)
3/4" = 1'-0"

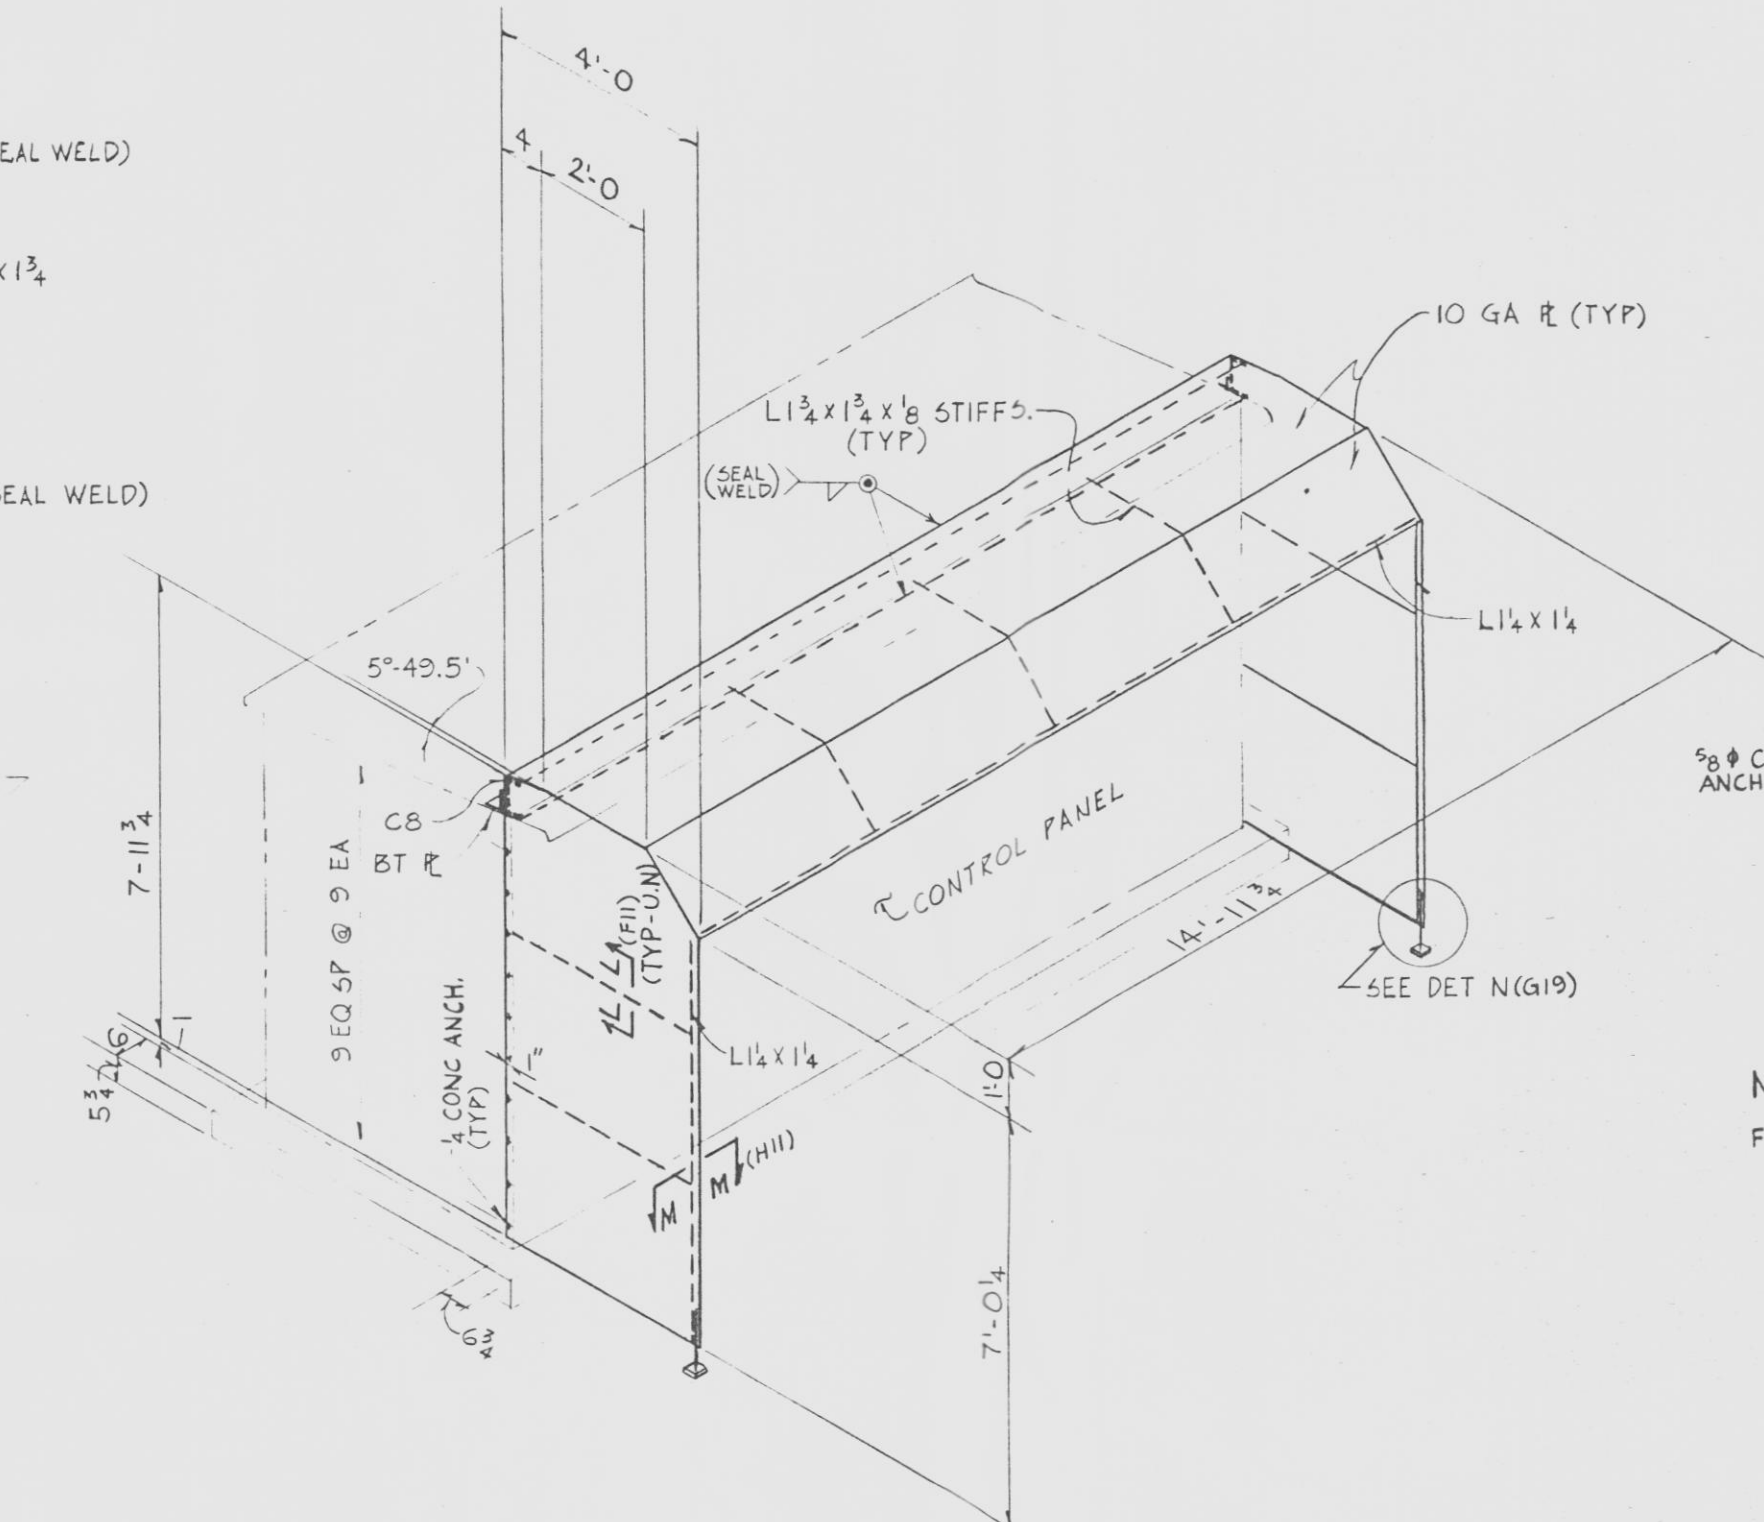

RAIN HOOD FOR WATER TREATMENT CONTROL PANEL
3/8" = 1'-0"

NOTES
FOR GENERAL NOTES SEE 8770-G-807 SH. 1

REFERENCE DRAWINGS
LIST OF DRAWINGS
RAB PEN. AREA - CONDUIT TRAYS & GDS 8770-G-347
RAB EMBEDDED STEEL 8770-G-823
HVAC-CONTROL RM AREA 8770-G-873
T.B. COLUMN SCHEDULE SH. 1 8770-G-807



RECEIVED
AUG - 3 1979
ST. LUCIE PLANT NO. 2

ITEMS ON THIS DRAWING
1. PENETRATION BARRIER
2. SUPPORT FRAMES FOR HVE-6A & HVE-6B
3. RAIN HOOD FOR WATER TREATMENT CONTROL PANEL
4. ACC 3A-3B-3C-3D MOUNTING DETAILS
5. REACTOR AUX BLDG PENETRATION BOX SUPP DETS

SEISMIC CLASS 1 - ITEMS #1, #2 & #4

THIS DOCUMENT IS THE PROPERTY OF EBASCO SERVICES INCORPORATED. ITS USE IS EXPRESSLY RESTRICTED BY THE TERMS OF THE CONTRACT, DATED AS OF AUGUST 10, 1968, BETWEEN EBASCO SERVICES INCORPORATED AND FLORIDA POWER & LIGHT COMPANY.


FLORIDA POWER & LIGHT COMPANY
ST LUCIE PLANT
1976 - 890,000 KW INSTALLATION - UNIT NO. 1
MISCELLANEOUS STRUCTURAL STEEL
ALL AREAS SH. 9

EBASCO SERVICES INCORPORATED
SCALE AS NOTED
APPROVED
DATE 8-13-1979
DR. CIVIL
DR. GOSSELIN
CH. R. KOZOV
8770-G-814
SH. 9


DRAWING TRANSFERRED TO FPL 7-21-79

THIS DRAWING SHOWS AS-BUILT CONDITIONS AND REPRESENTS THE INFORMATION SHOWN ON FSB-8770-AS-164, FSB-8770-AS-150, FSB-8770-AS-153, FSB-8770-AS-144 & FSB-8770-AS-140

NOTE: THIS REVISION REFLECTS AS-BUILT CONDITIONS

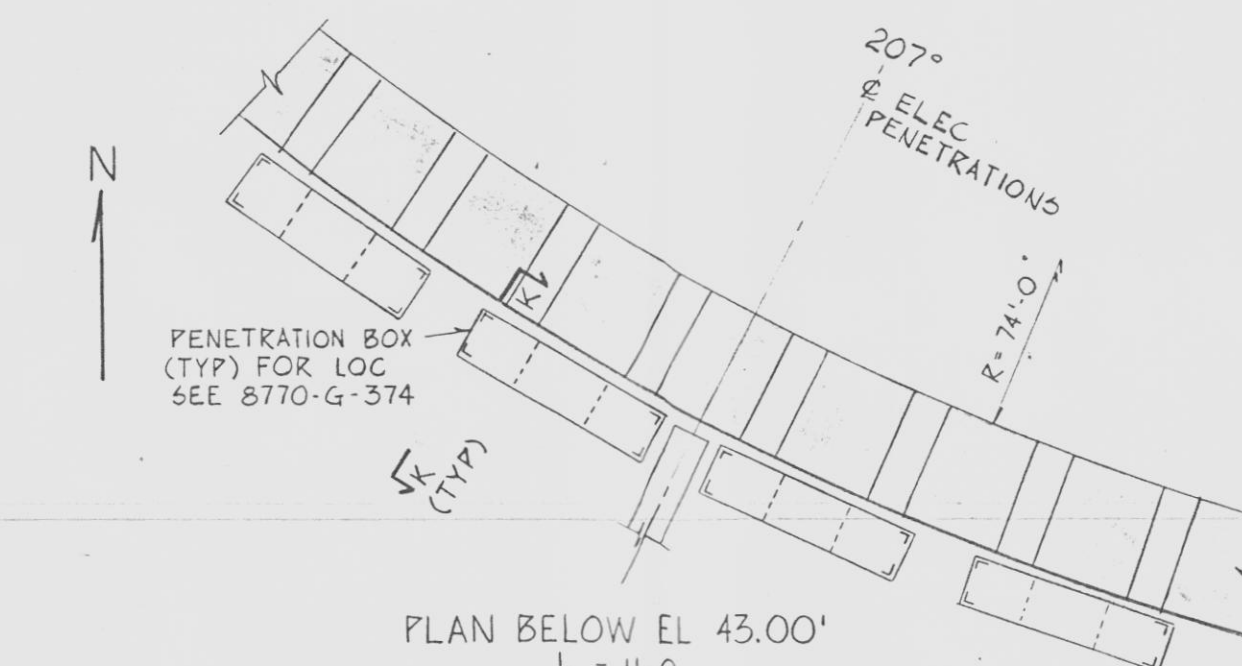


PLAN BELOW EL 43.00'
1/4" = 1'-0"

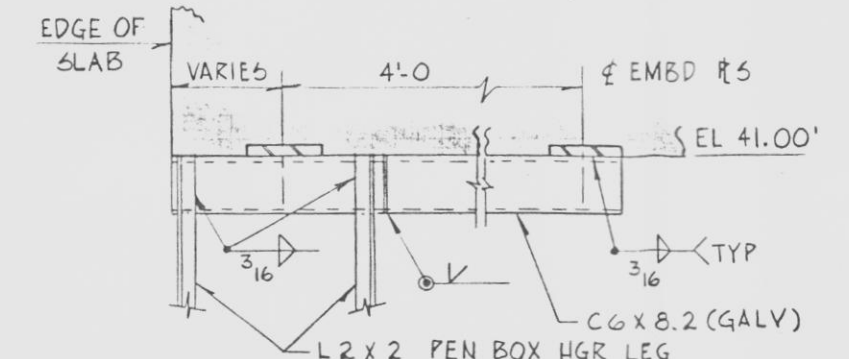


SECT K
3/4" = 1'-0"

REACTOR AUX BLDG
PENETRATION BOX SUPPORT DETS

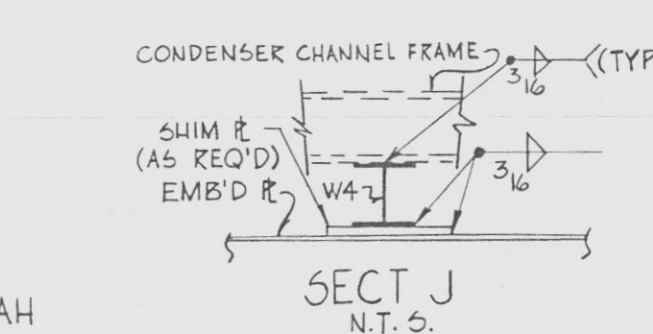

SECT J
N.T.S.

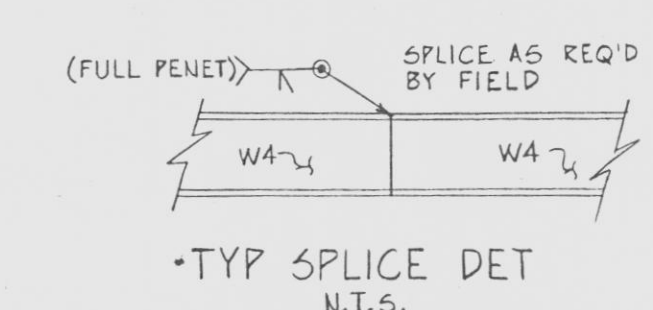

TYP SPLICE DET
N.T.S.

ACC 3A-3B-3C-3D MOUNTING DETAILS
PART PLAN EL 62.00'

