



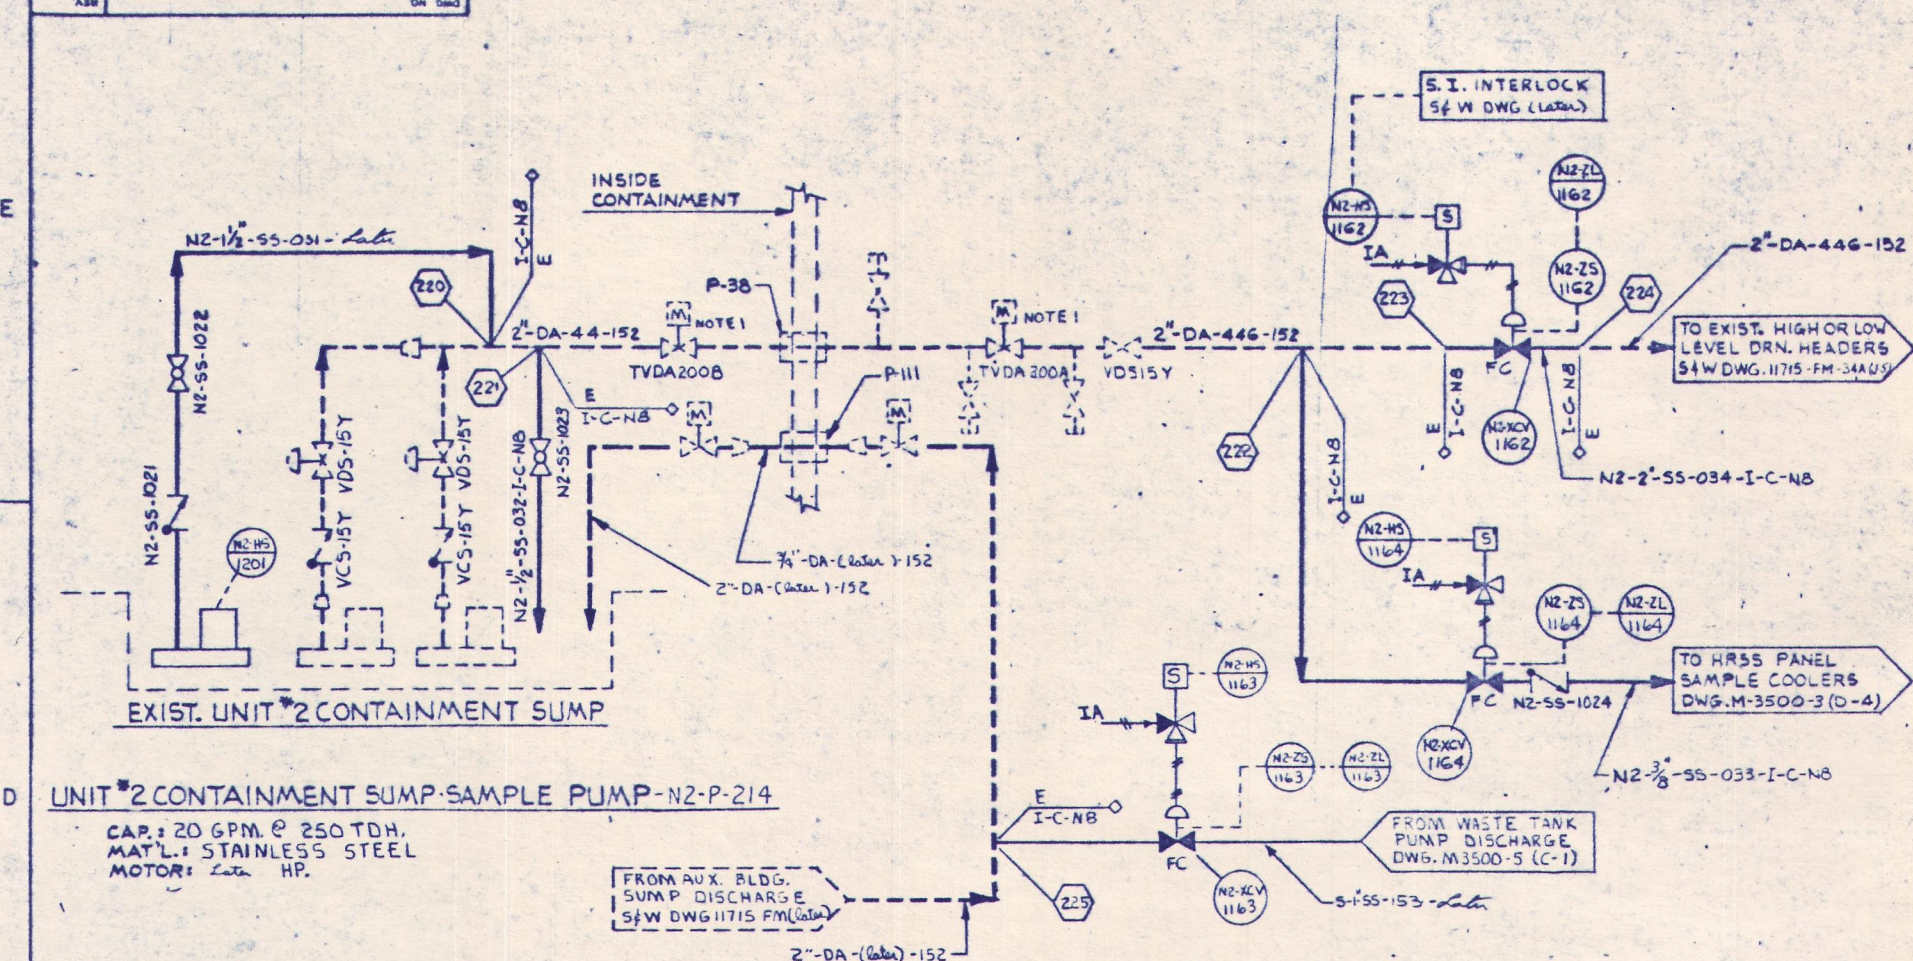


NOTE:

1. FOR GENERAL NOTES SEE
DWG. M-3500 SH. 1.

REVISIONS	
REV	DESCRIPTION
A	ISSUED FOR CLIENT REVIEW & INTERNAL REVIEW RBS Pmd R 4-10-80
B	RELEASED FOR ENGINEERING JEA RBS JF Pmd 5/5/80

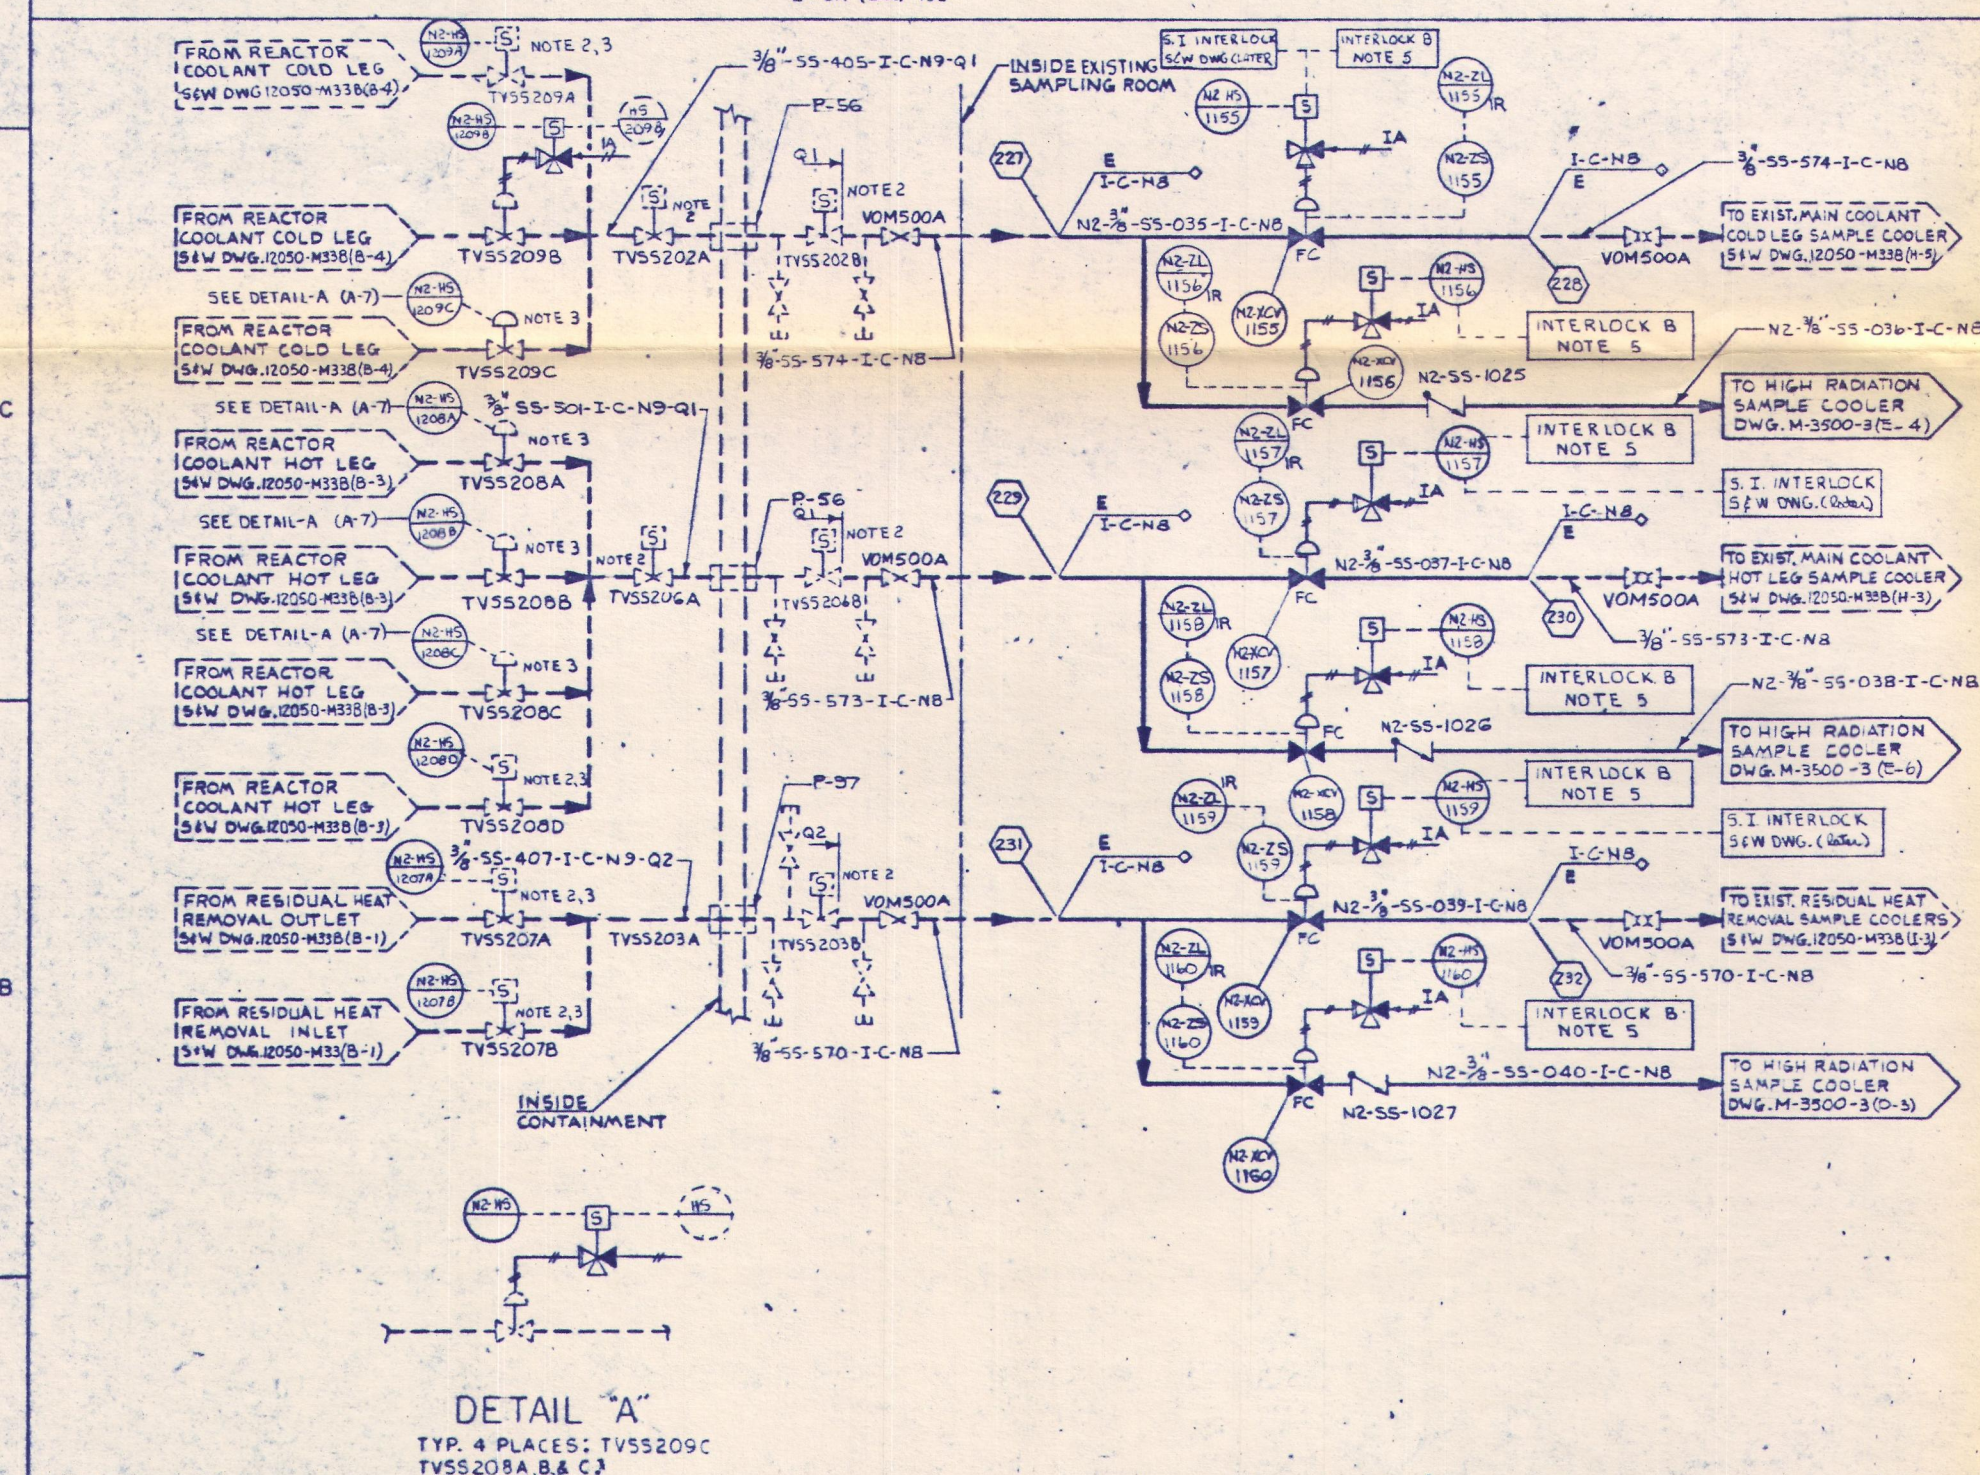

DETAIL "A"
TYP. 4 PLACES: TVSS209C
TVSS208A, B & C

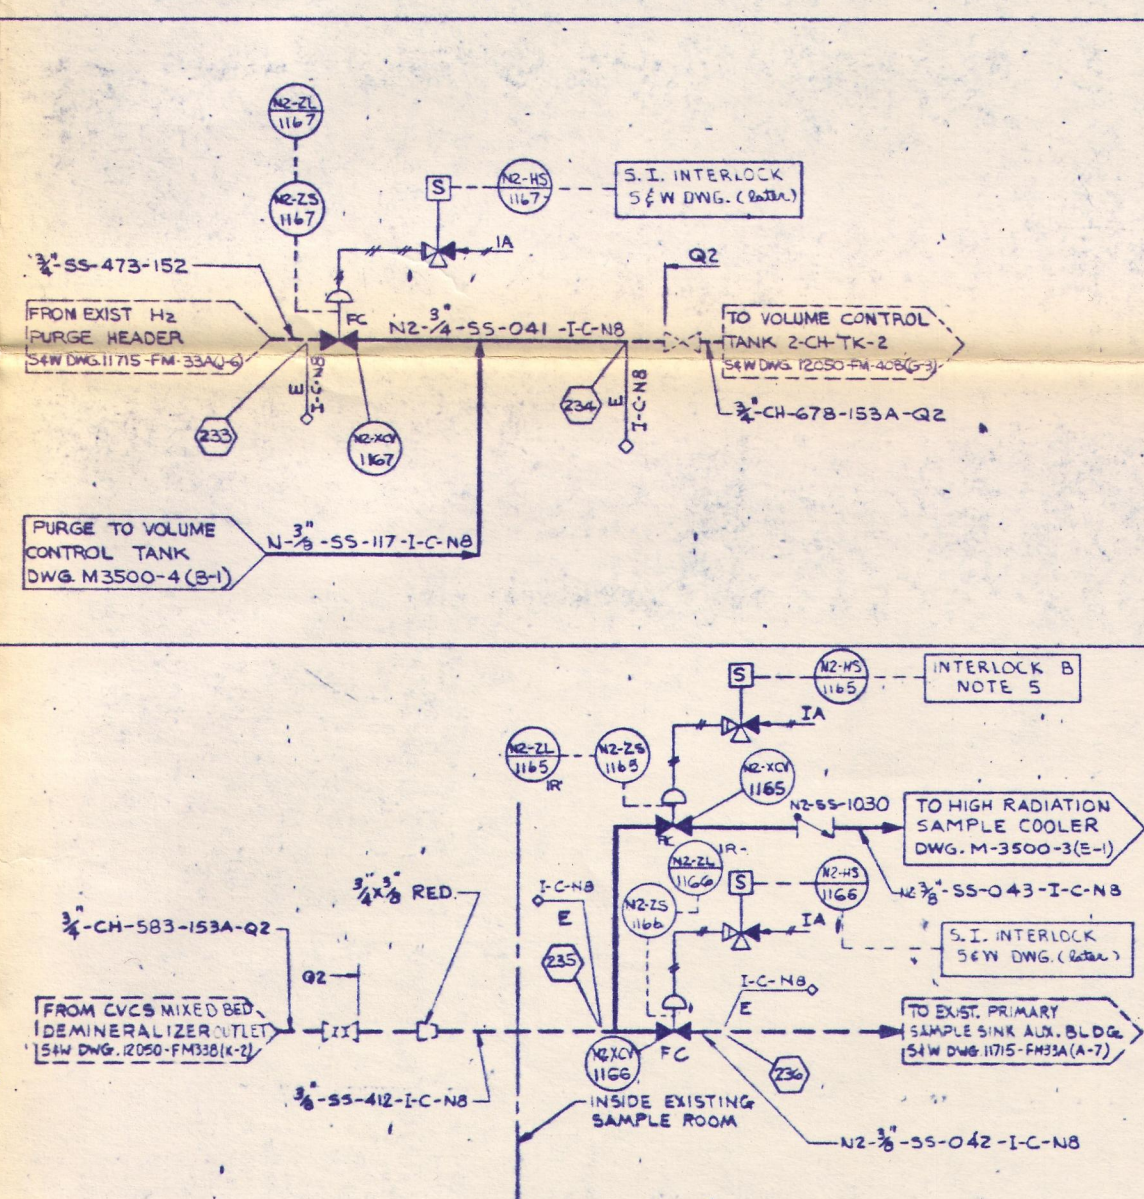

RELEASED FOR ENGINEERING

DATE	10/10	VIRGINIA ELECTRIC POWER COMPANY HIGH RADIATION SAMPLING SYSTEM NORTH ANNA UNIT 2 PIPING & INSTRUMENTATION DIAGRAM LIQUID SAMPLING
DRAWN BY	Robert D. Miller	
CHECKED BY	<i>[Signature]</i>	
DATE	10/10	
DESIGNED BY	COOL ENGINEER	
DISC NO.	10/10	
APPROVAL		5324-M-3500 SCALE: NONE SHEET 2 OF 5
APPROVAL		
APPROVAL PROJ.		
APPROVAL CLIENT		