


This drawing and the design it contains are the property of BECHTEL. They are loaned to you for your use only and are not to be reproduced, copied, loaned, or used in any way without express written permission of BECHTEL. They are to be returned to BECHTEL upon completion of your project.

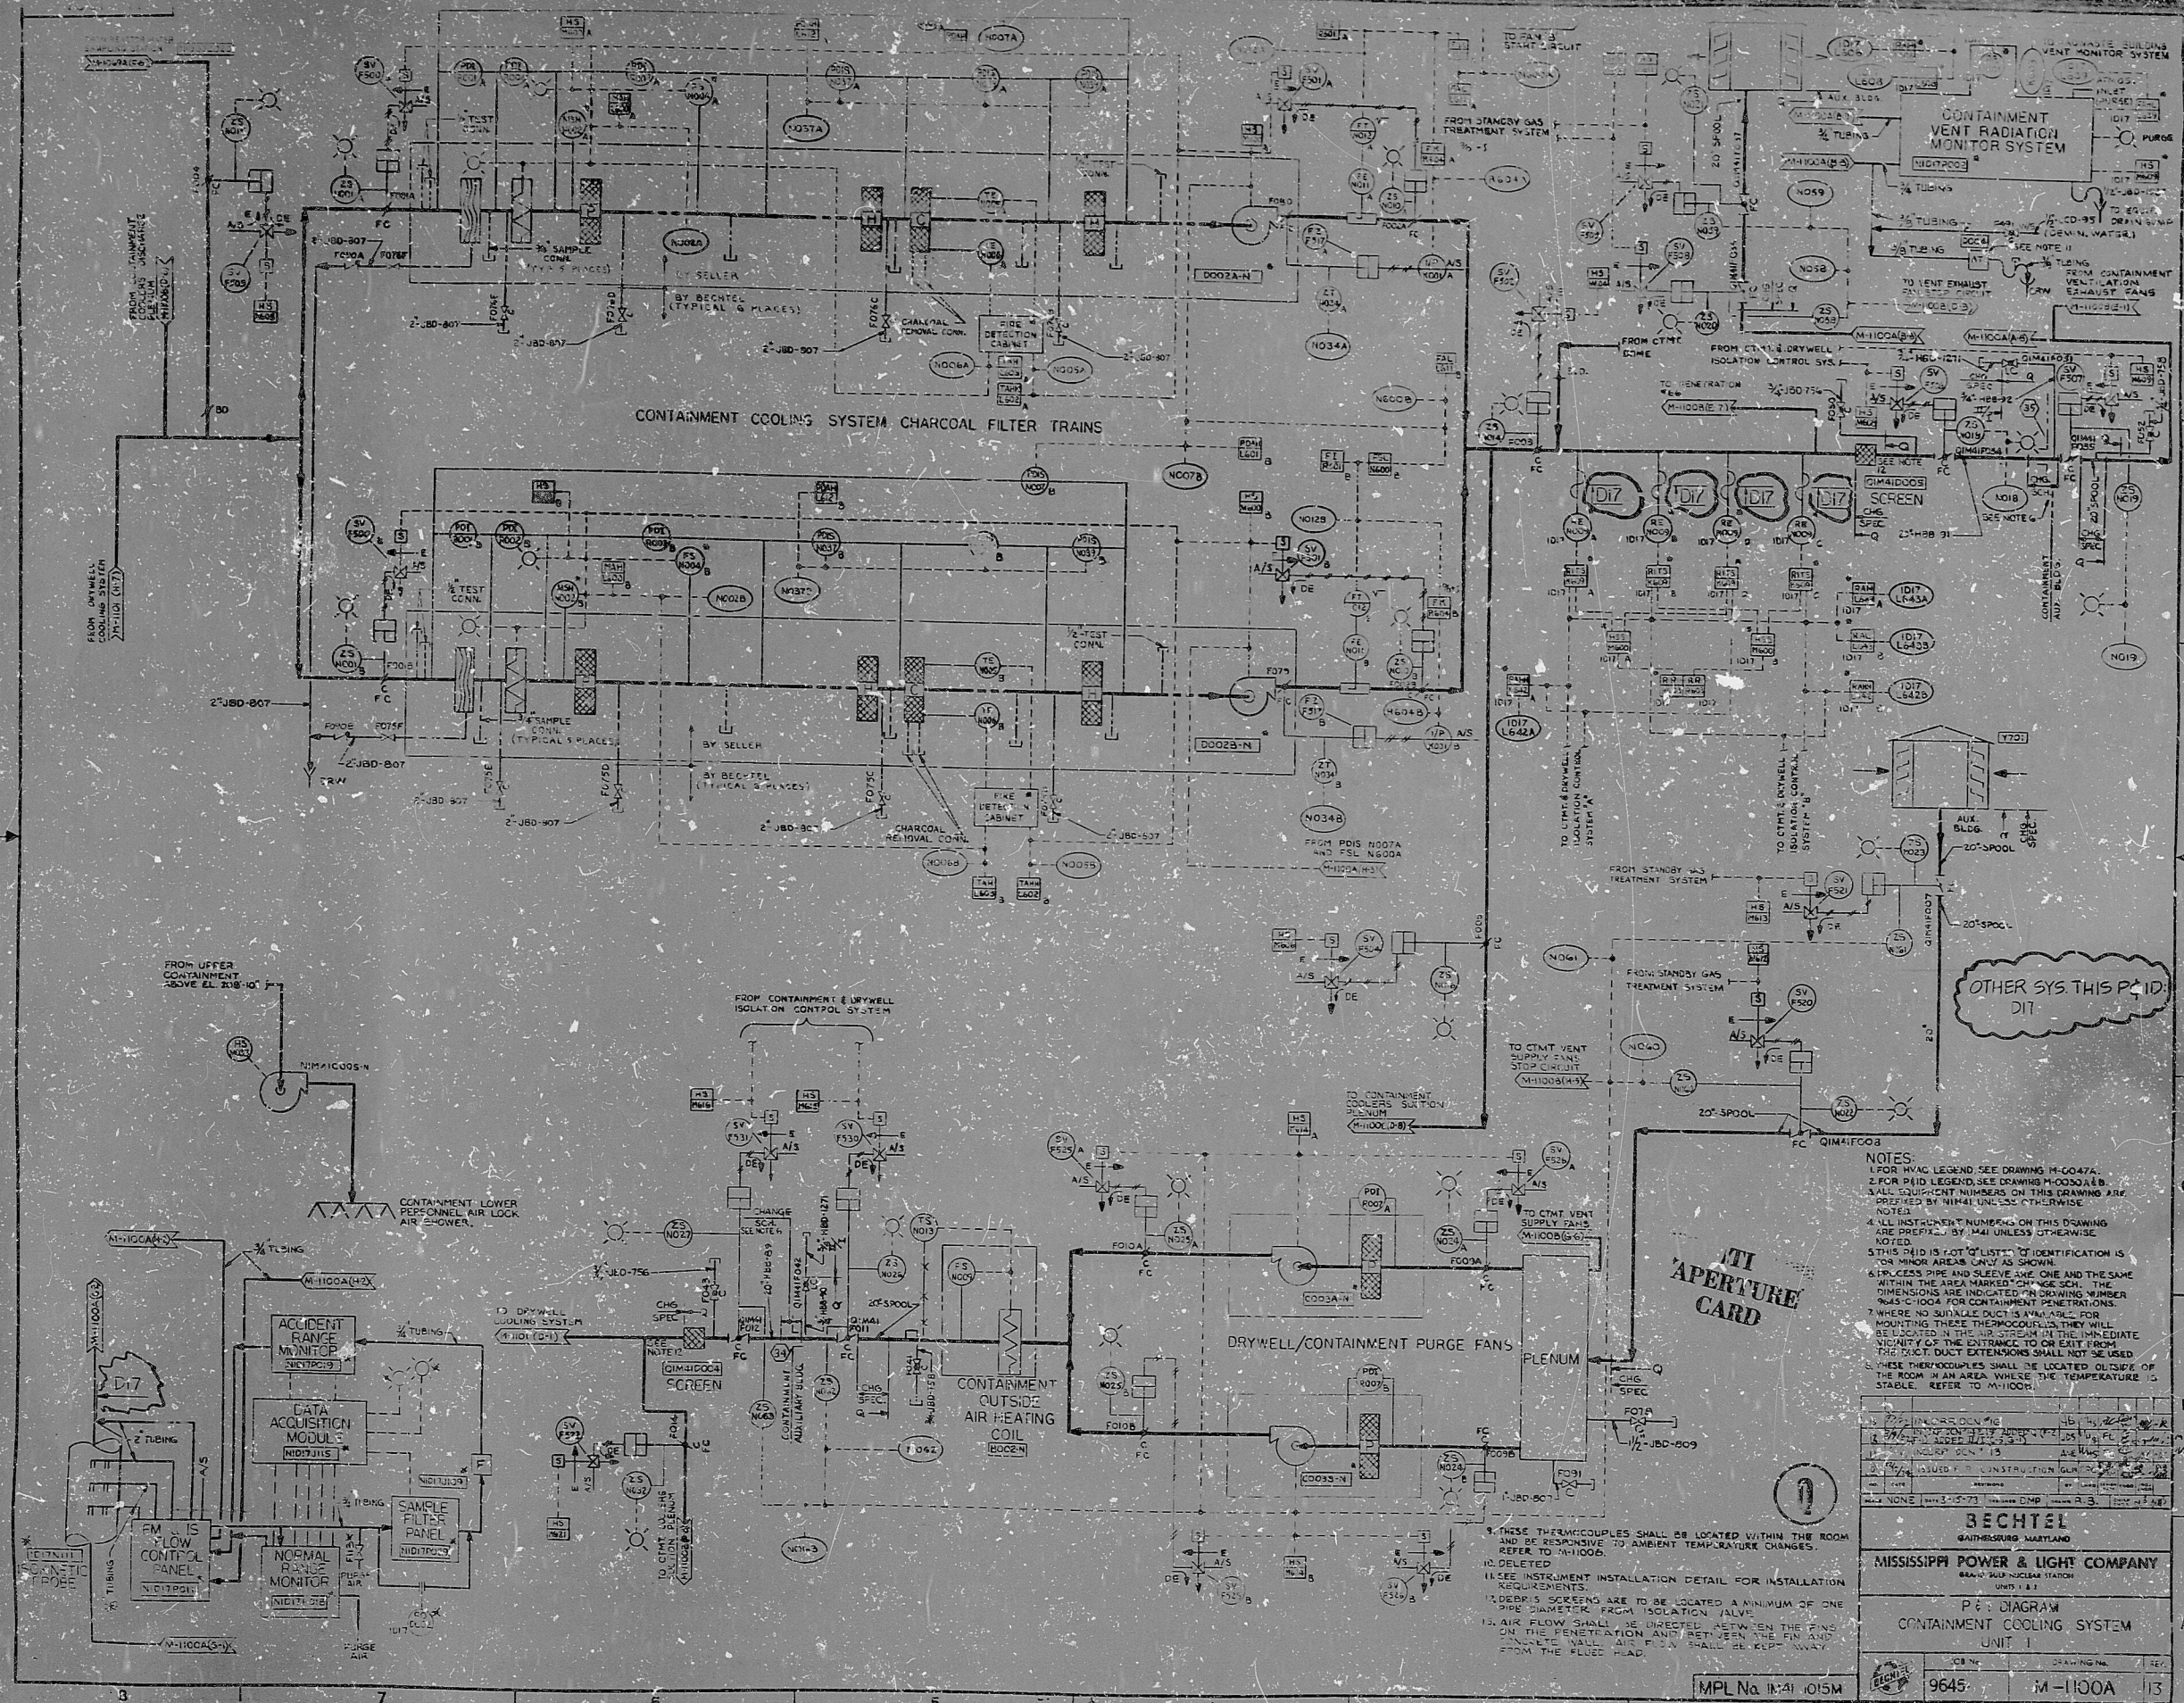

NOTES:
1. FOR WELD LEGEND SEE DRAWING M-1000A.
2. FOR P&ID LEGEND SEE DRAWING M-1000A.1.
3. ALL EQUIPMENT NUMBERS ON THIS DRAWING ARE PRELIMINARY. THEY WILL BE FINALIZED BY THE DESIGN TEAM.
4. ALL INSTRUMENT NUMBERS ON THIS DRAWING ARE PRELIMINARY. THEY WILL BE FINALIZED BY THE DESIGN TEAM.
5. THIS P&ID IS NOT TO BE USED FOR IDENTIFICATION OF MINOR AREAS ONLY AS SHOWN.
6. STRIPES PIPE AND SLEEVE ARE ONE AND THE SAME WITHIN THE AREA MARKED ON THE P&ID. THE DIMENSIONS ARE INDICATED IN DRAWING NUMBER M-1000A.1 FOR CONTAINMENT PENETRATION.
7. WHERE NO SUITABLE DUCT IS AVAILABLE FOR ROUTING THE DUCT THROUGH THE PENETRATION, THE DUCT DUCT EXTENSIONS SHALL NOT BE USED.
8. THESE THERMOCOUPLES SHALL BE LOCATED OUTSIDE OF THE ROOM, IN AN AREA WHERE THE TEMPERATURE IS STABLE. REFER TO M-1000A.1.

RECHTEL	
MISSISSIPPI POWER & LIGHT COMPANY	
BRAND NEW NUCLEAR STATION	
P&ID DIAGRAM	
CONTAINMENT COOLING SYSTEM	
UNIT 1	
DATE: 10/15/54	BY: J. L. B.
9645	M-1000A 13

8309220390

IRC

50-416

8309220390

