

34"

34"

22"

22"

17"

17"

11"

11"

8.5"

8.5"

8.5"

8.5"

11"

11"

17"


17"

22"

22"

34"

34"

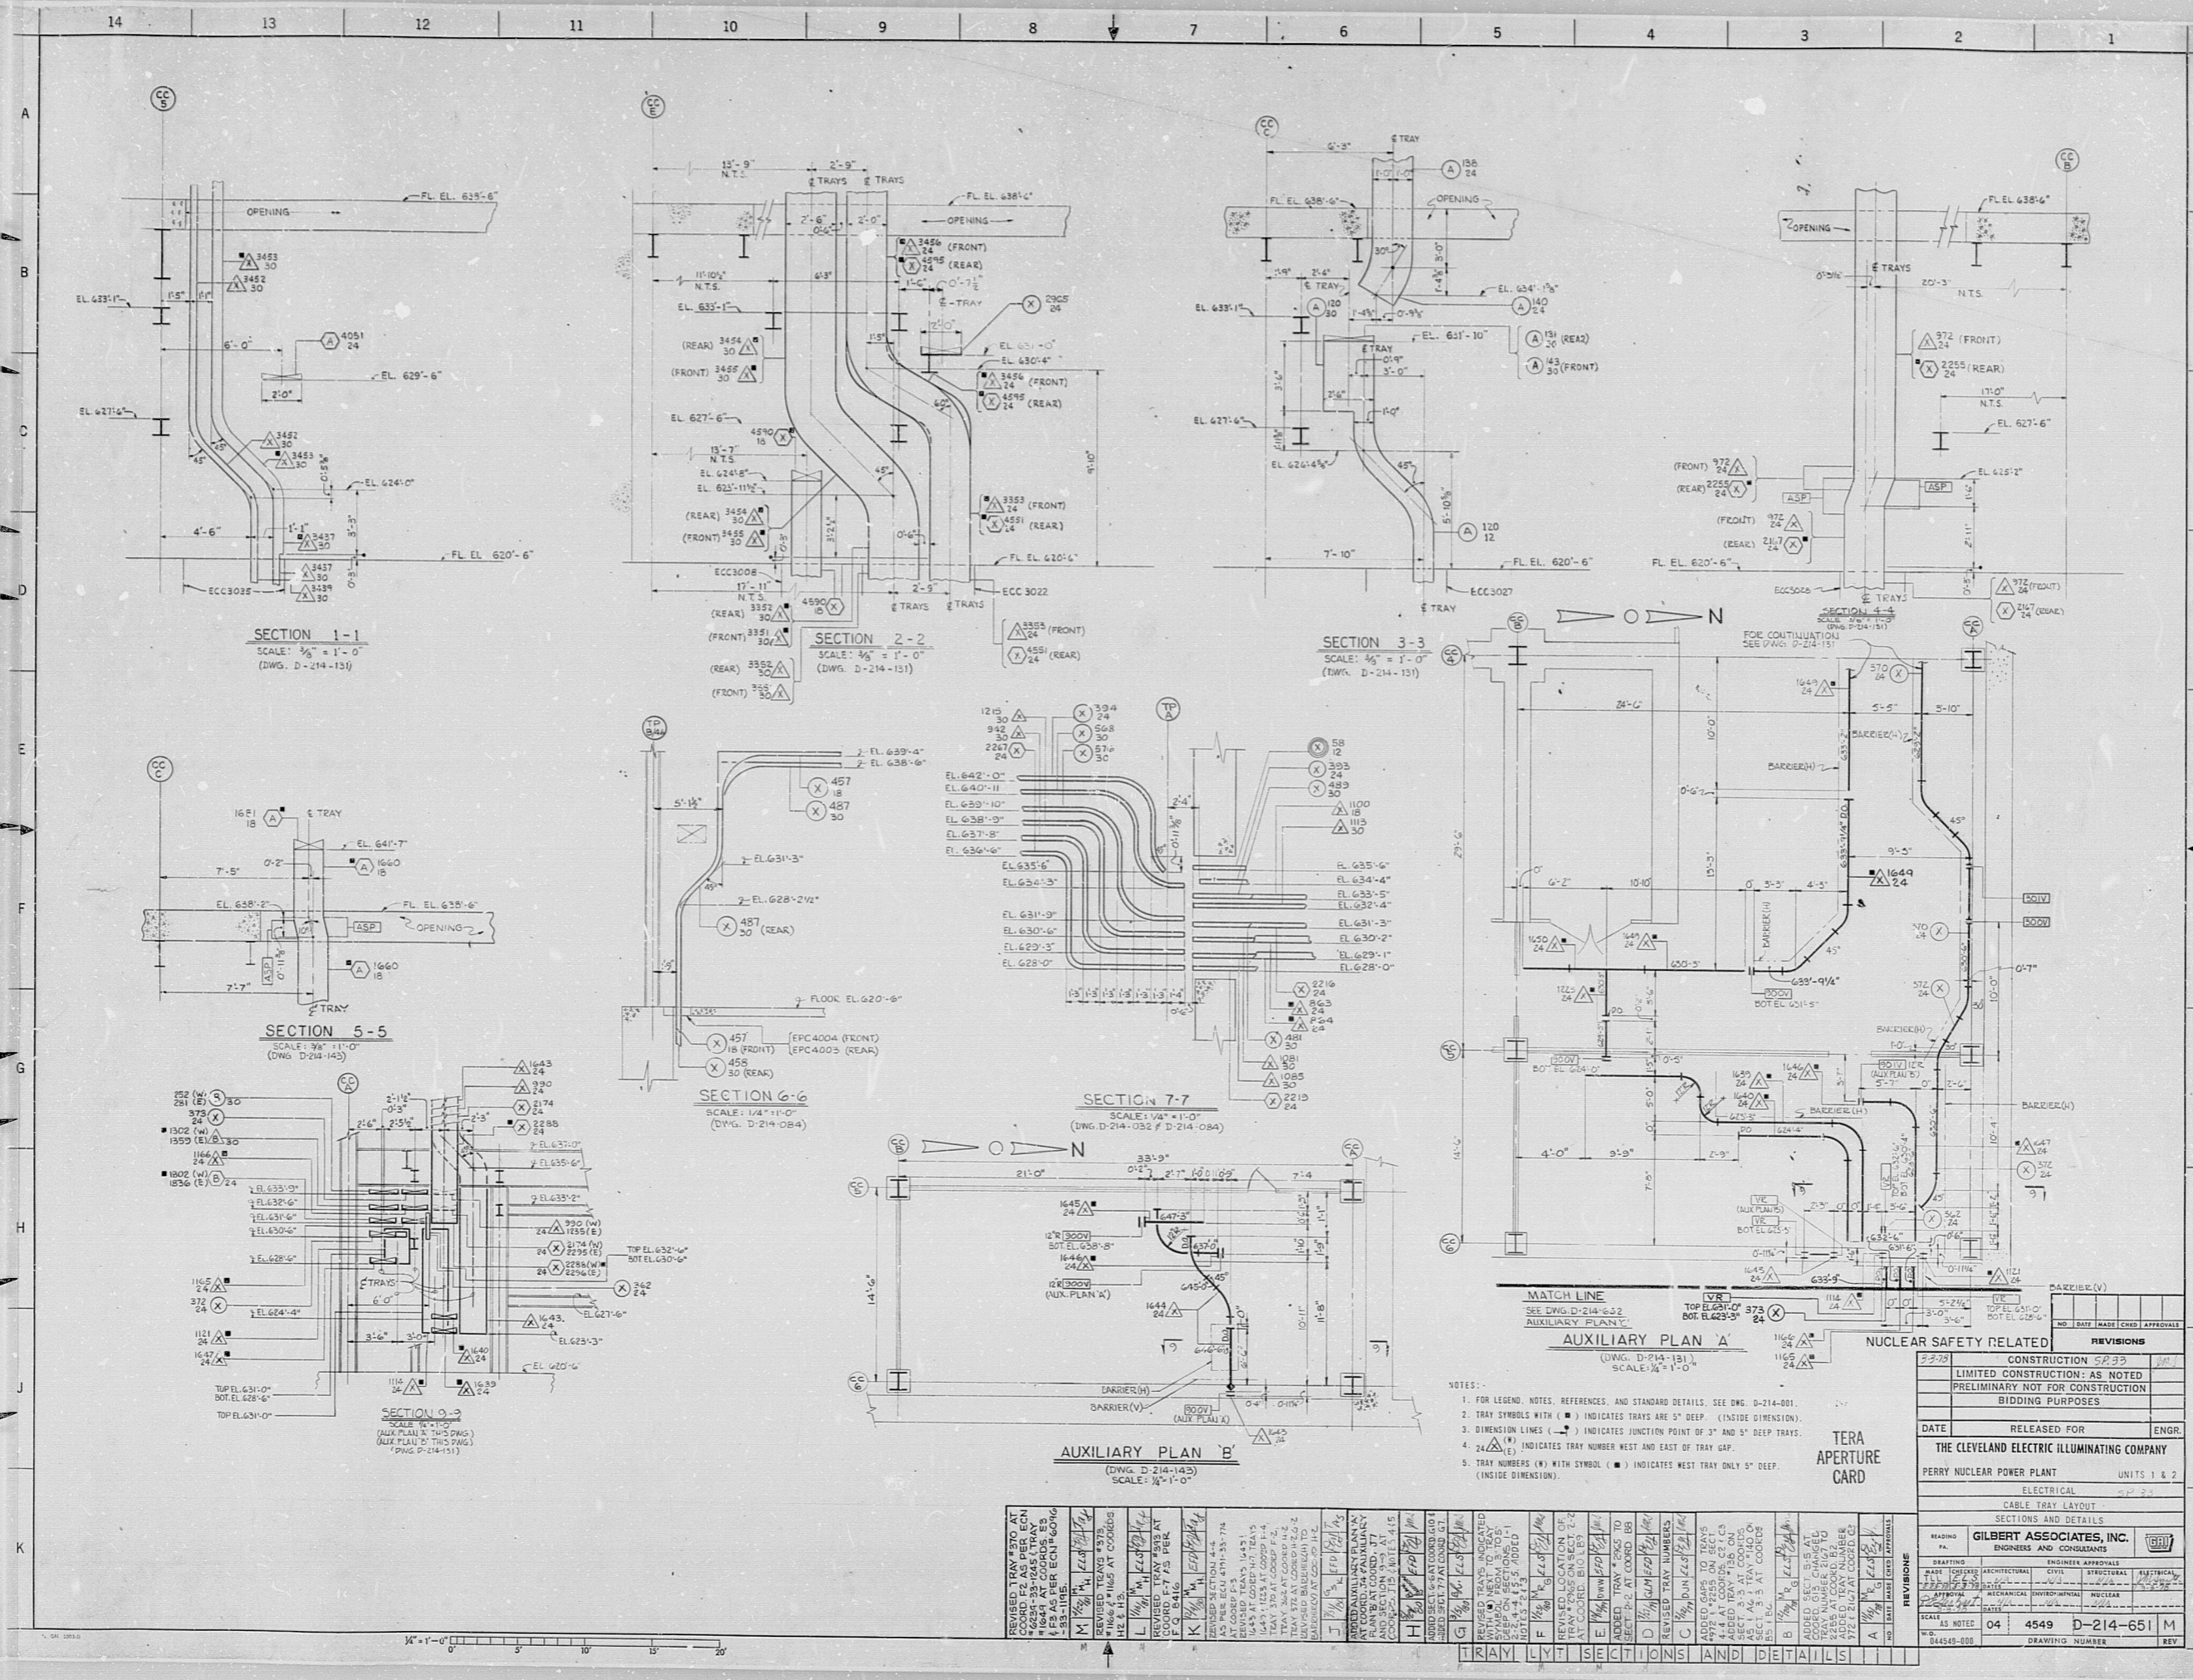

- NOTES:
- FOR LEGEND, NOTES, REFERENCES, AND STANDARD DETAILS, SEE DWG. D-214-001.
  - TRAY SYMBOLS WITH (●) INDICATES TRAYS ARE 5" DEEP. (INSIDE DIMENSION).
  - DIMENSION LINES (---) INDICATES JUNCTION POINT OF 3" AND 5" DEEP TRAYS.
  - 24 (E) INDICATES TRAY NUMBER WEST AND EAST OF TRAY GAP.
  - TRAY NUMBERS (●) WITH SYMBOL (●) INDICATES WEST TRAY ONLY 5" DEEP. (INSIDE DIMENSION).

NUCLEAR SAFETY RELATED

DATE	RELEASED FOR	ENGR.

THE CLEVELAND ELECTRIC ILLUMINATING COMPANY  
PERRY NUCLEAR POWER PLANT

ELECTRICAL  
CABLE TRAY LAYOUT  
SECTIONS AND DETAILS

GILBERT ASSOCIATES, INC.  
ENGINEERS AND CONSULTANTS

REVISIONS

NO.	DATE	BY	REVISION
1			
2			
3			
4			
5			
6			
7			
8			
9			
10			
11			
12			
13			
14			
15			
16			
17			
18			
19			
20			
21			
22			
23			
24			
25			
26			
27			
28			
29			
30			

REVISIONS

NO.	DATE	BY	REVISION
1			
2			
3			
4			
5			
6			
7			
8			
9			
10			
11			
12			
13			
14			
15			
16			
17			
18			
19			
20			
21			
22			
23			
24			
25			
26			
27			
28			
29			
30			

SCALE: AS NOTED

NO. 04 4549 D-214-651 M

DRAWING NUMBER

REV



RIDS

8112030190

