


14
13
12
11
10
9
8
7
6
5
4
3
2
1

A
B
C
D
E
F
G
H
I
J
K

22"
17"
11"
8.5"
11"
17"
22"
34"

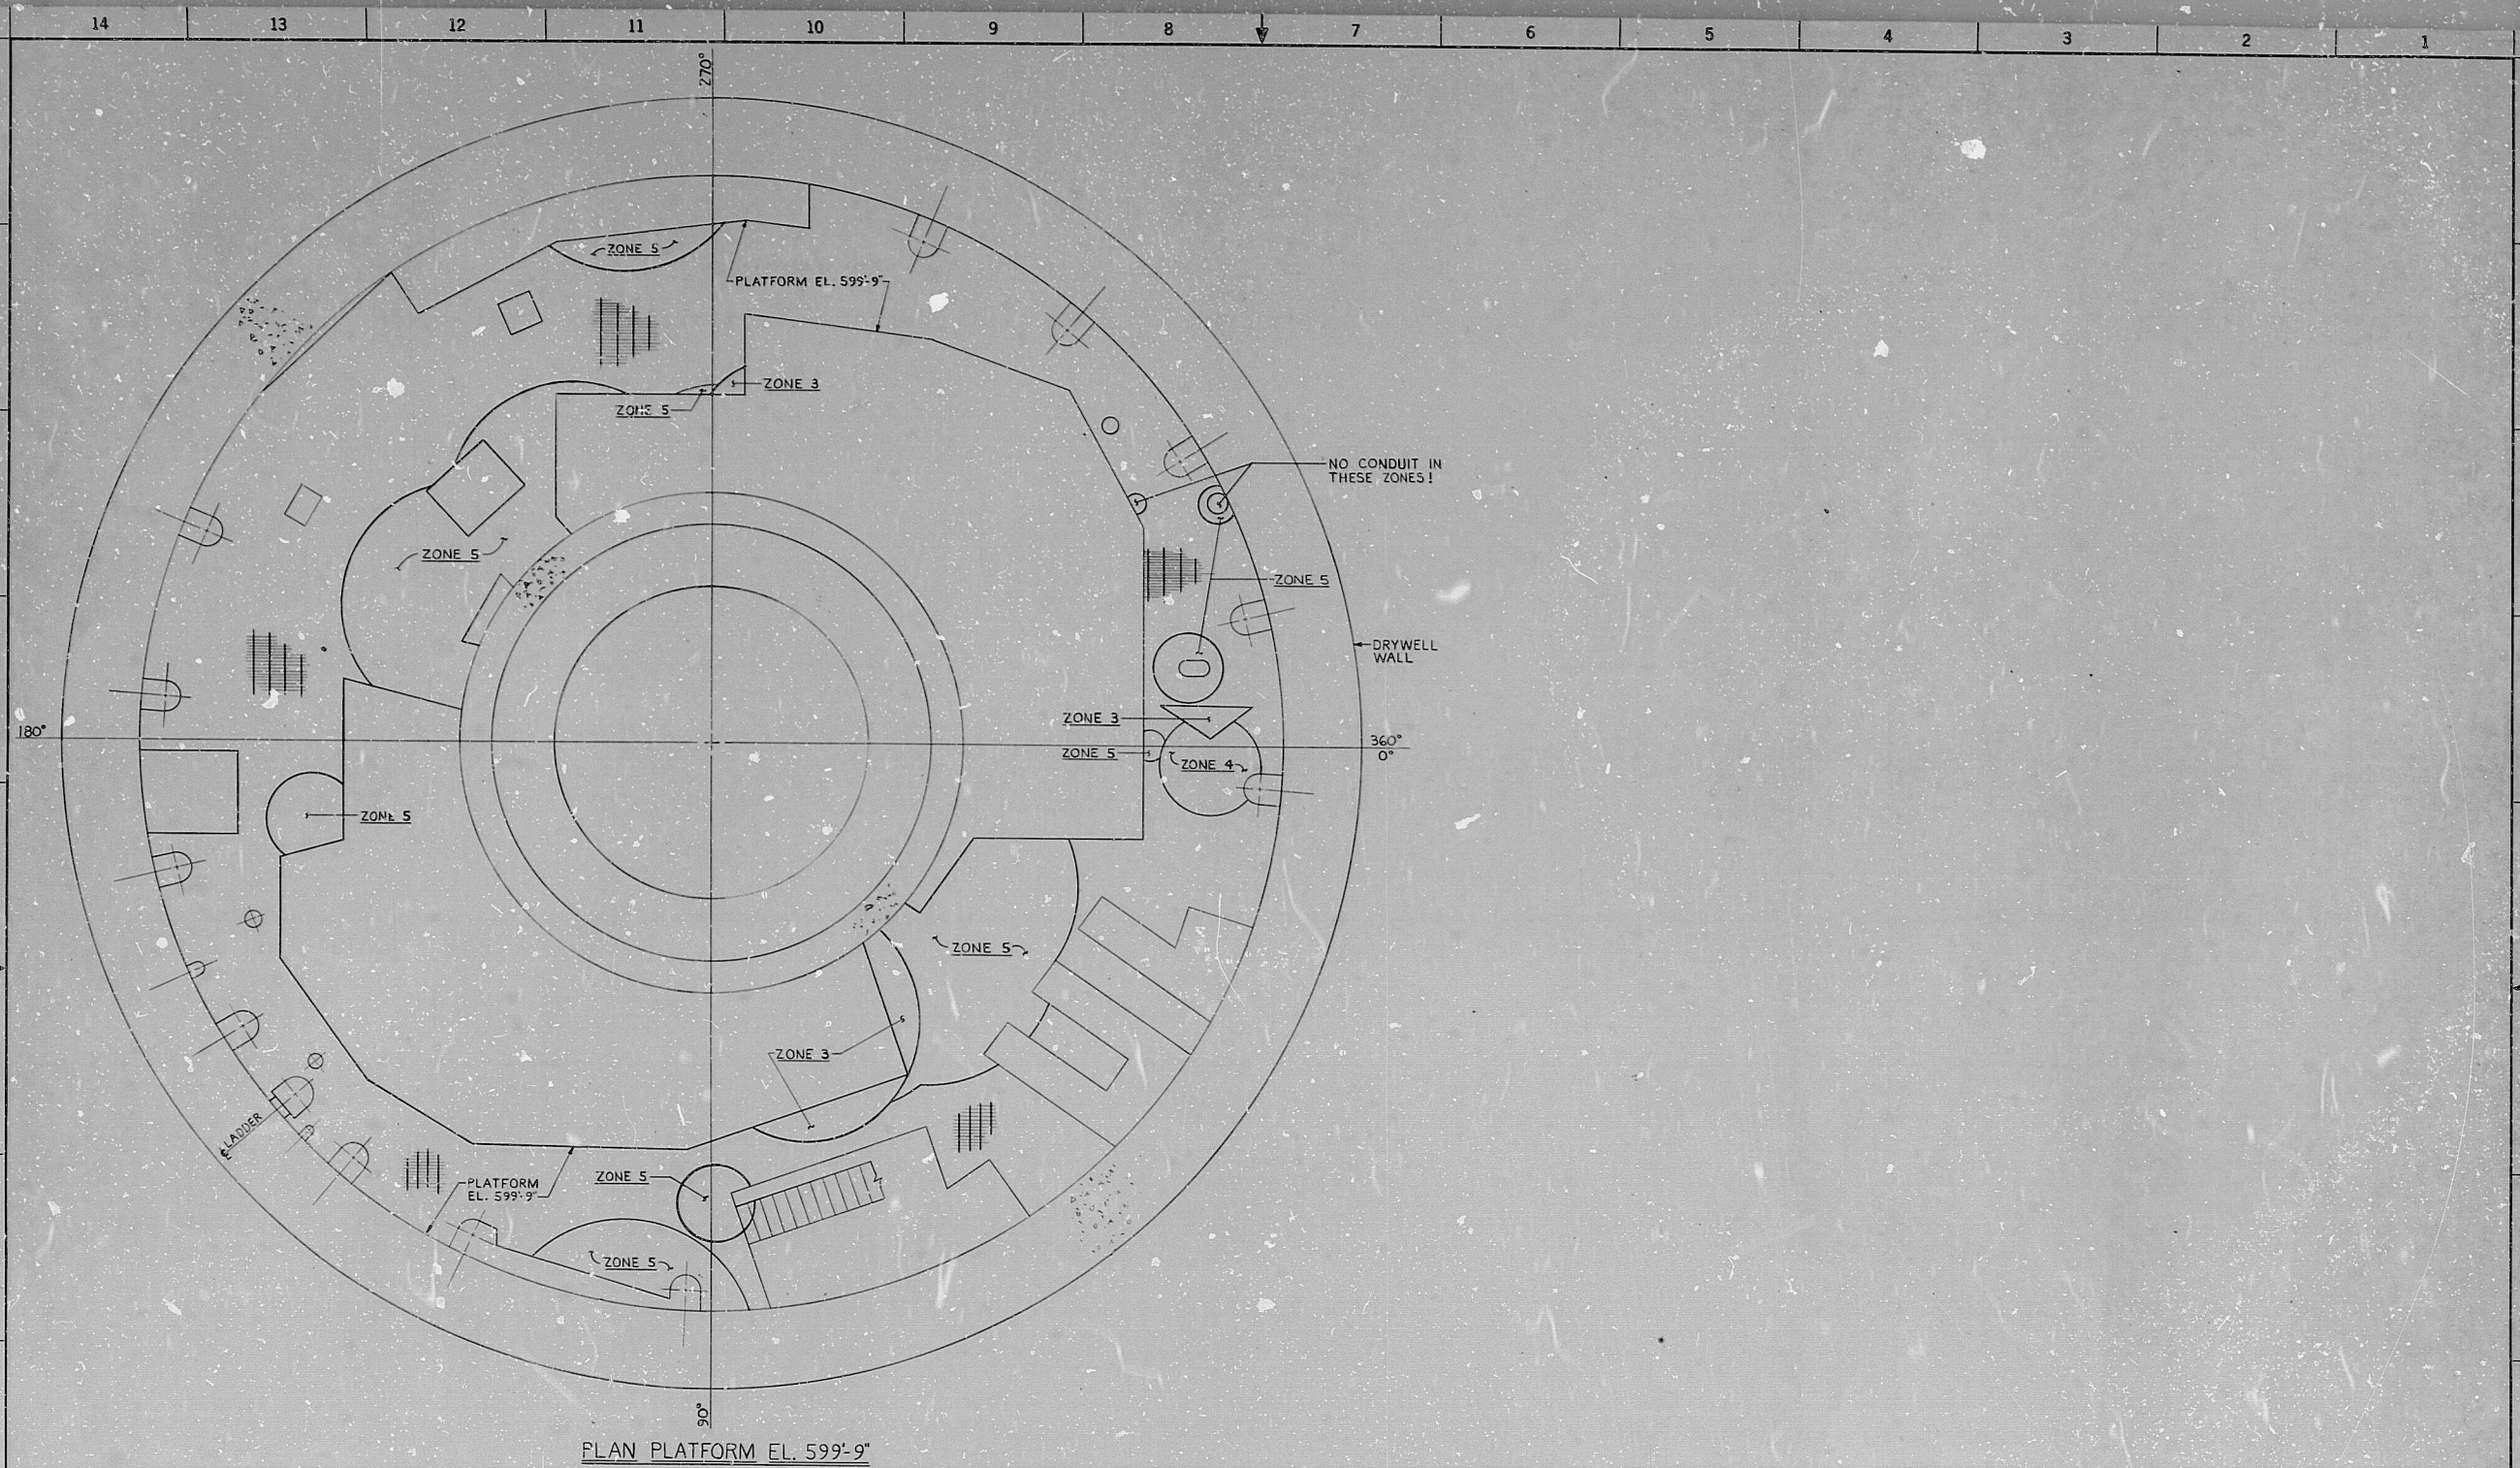

PLAN PLATFORM EL. 599'-9"

NOTES:
1. FOR ZONE REFERENCES, SEE DRAWING SS-215-005, SHEET 40.

NUCLEAR SAFETY RELATED

TERA
APERTURE
CARD

REVISIONS	
NO.	DATE MADE (CHKD) APPROVALS
1-16-57	CONSTRUCTION <i>SP-33</i>
	LIMITED CONSTRUCTION: AS NOTED
	PRELIMINARY NOT FOR CONSTRUCTION
	BIDDING PURPOSES
DATE	RELEASED FOR ENGR.
	THE CLEVELAND ELECTRIC ILLUMINATING COMPANY
	PERRY NUCLEAR POWER PLANT UNIT 1
	ELECTRICAL
	CONDUIT LAYOUT DETAILS AND REFERENCES
	ZONE MAP PLATFORM EL. 599'-9"
DRAWING BY	GILBERT ASSOCIATES, INC.
ENGINEERS AND CONSULTANTS	
ENGINEER APPROVALS	
CHIEF ENGINEER	<i>[Signature]</i>
CHECKED	<i>[Signature]</i>
DATE	04 4549 D-215-004 A
SCALE	1/4" = 1'-0"
DRAWING NUMBER	04549-000
REV	

CND D E T S B REF ZONE MAP 599'-9" SH 602

RIDS

812030219

