

34

34

22

22

11

11

11

11

8.5

8.5

11

11

17

17

22

22

17

17

22

22

17


17

22

22

34



34

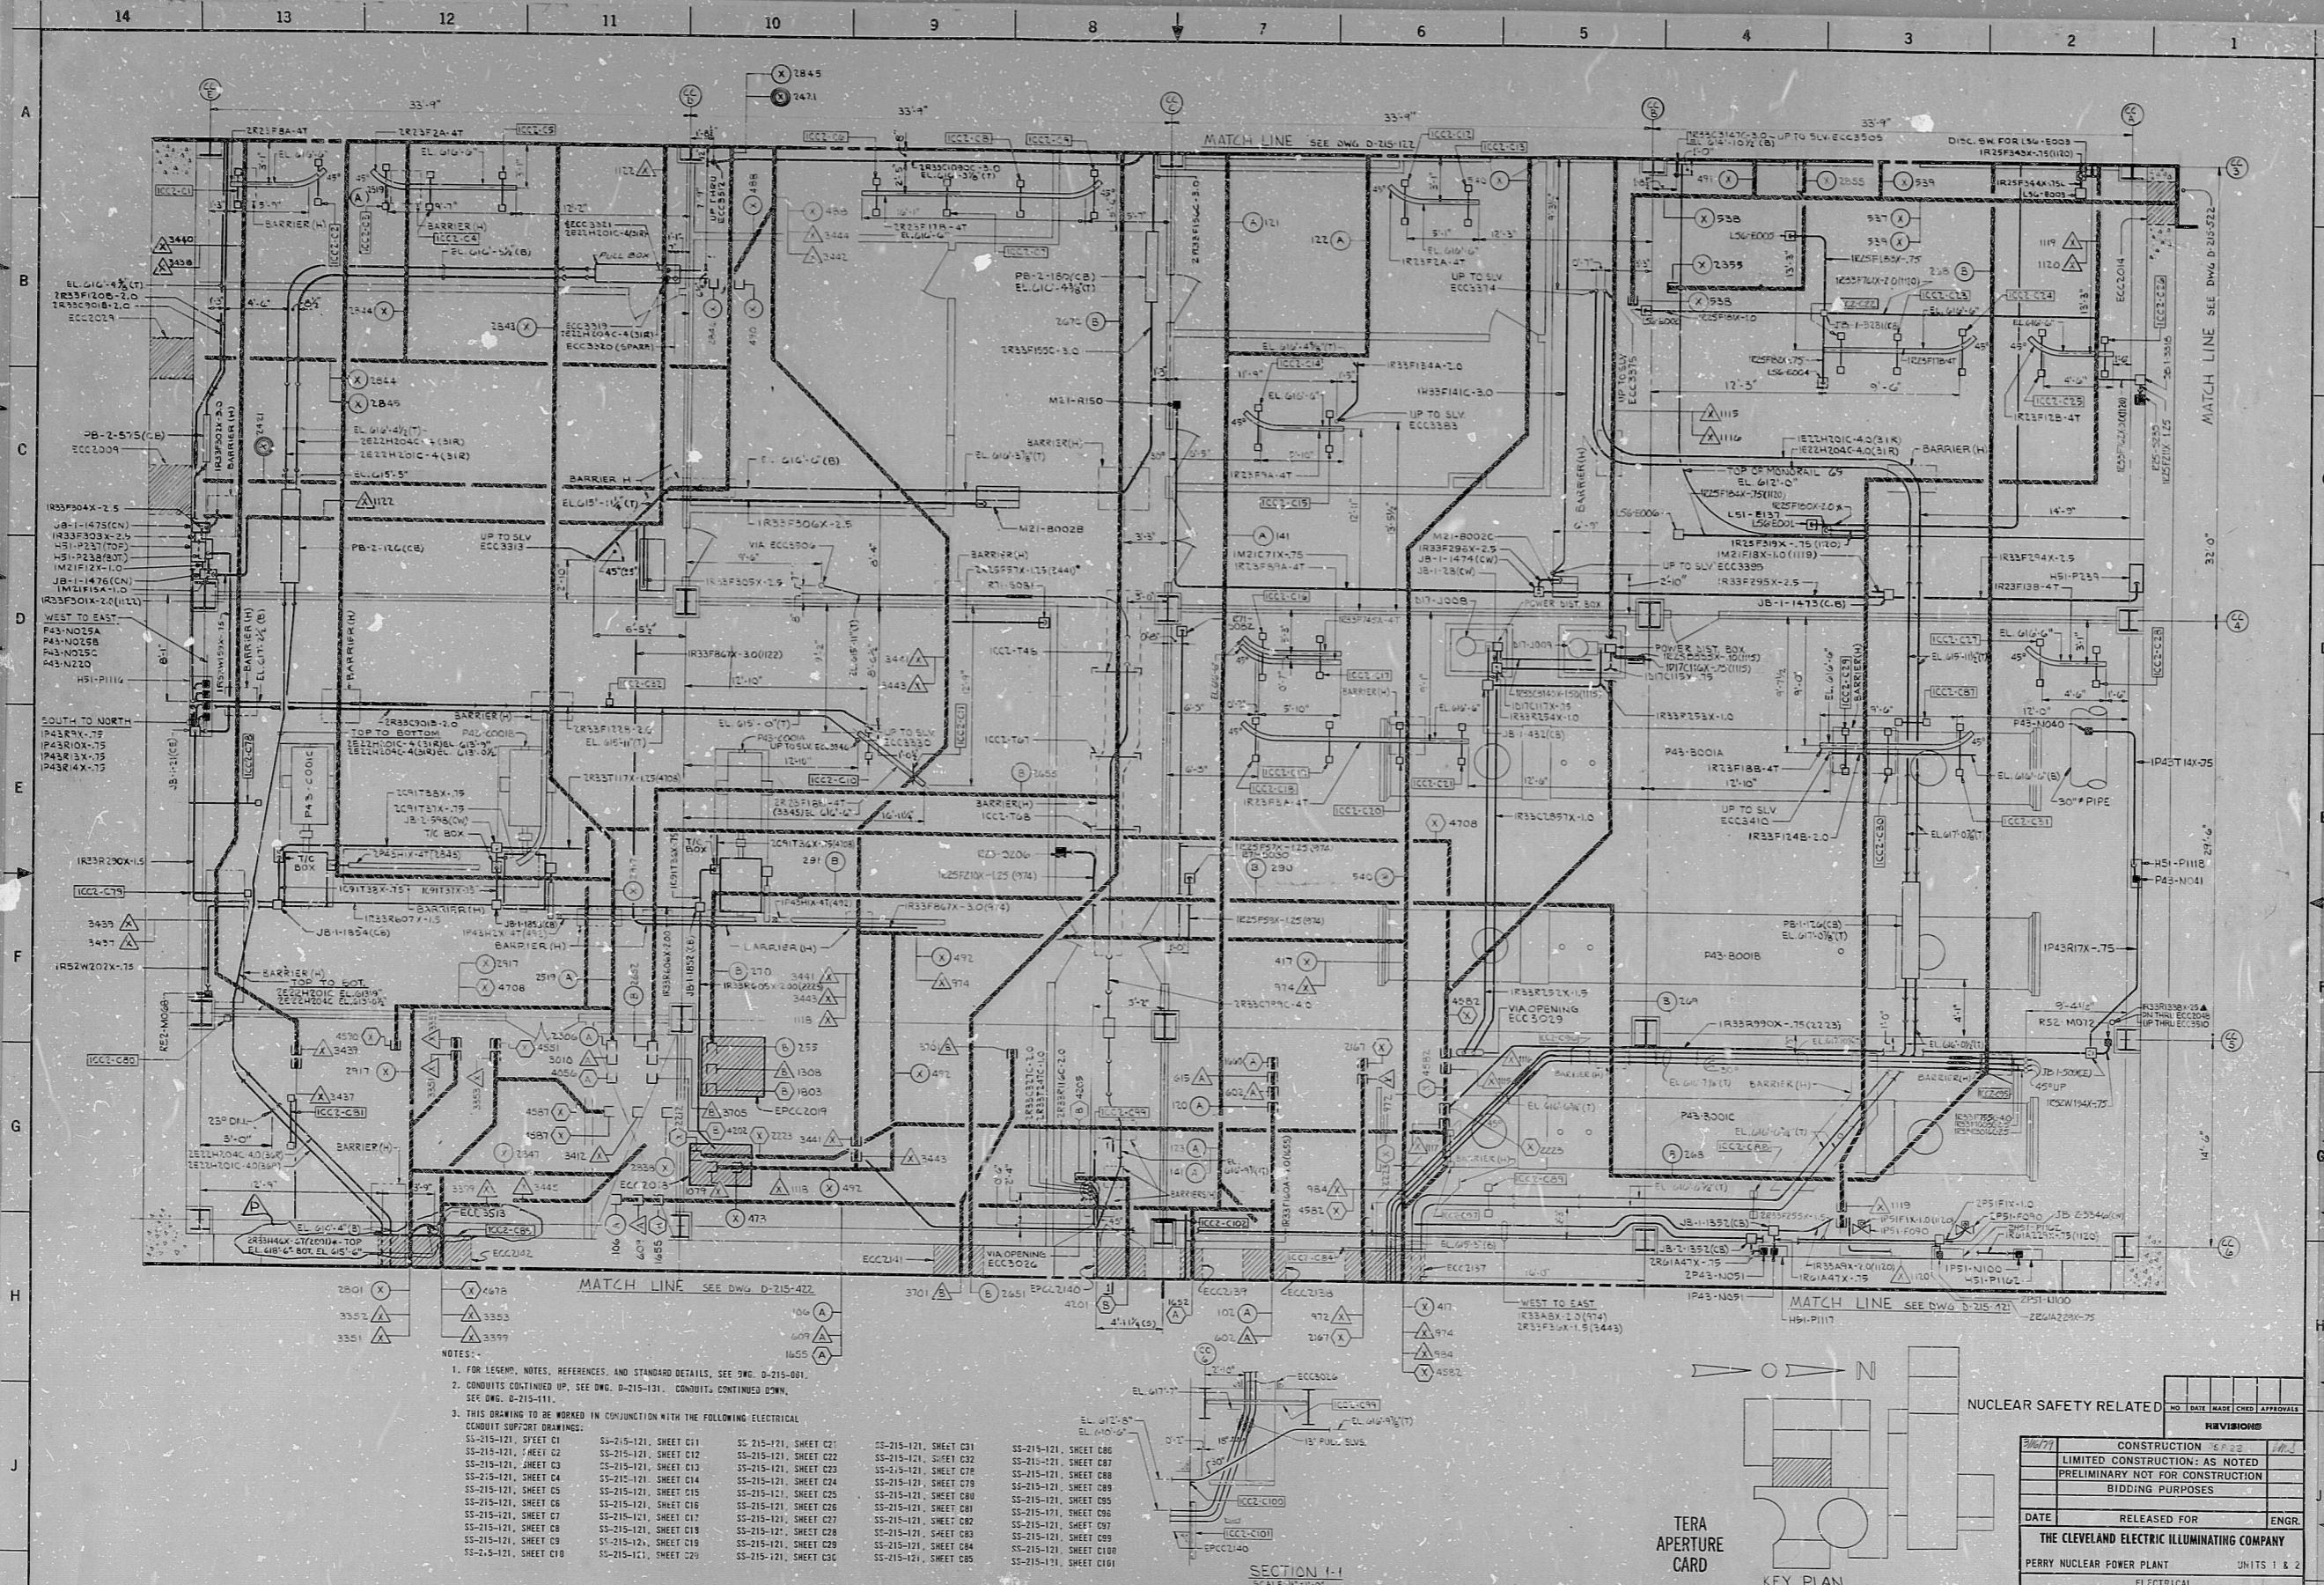

NOTES:

- FOR LEGEND, NOTES, REFERENCES, AND STANDARD DETAILS, SEE DWG. D-215-001.
- CONDUITS CONTINUED UP, SEE DWG. D-215-101. CONDUITS CONTINUED DOWN, SEE DWG. D-215-111.
- THIS DRAWING TO BE WORKED IN CONJUNCTION WITH THE FOLLOWING ELECTRICAL CONDUIT SUPPORT DRAWINGS:

SS-215-121, SHEET 01	SS-215-121, SHEET 02	SS-215-121, SHEET 03	SS-215-121, SHEET 04	SS-215-121, SHEET 05	SS-215-121, SHEET 06	SS-215-121, SHEET 07	SS-215-121, SHEET 08	SS-215-121, SHEET 09	SS-215-121, SHEET 10	SS-215-121, SHEET 11	SS-215-121, SHEET 12	SS-215-121, SHEET 13	SS-215-121, SHEET 14	SS-215-121, SHEET 15	SS-215-121, SHEET 16	SS-215-121, SHEET 17	SS-215-121, SHEET 18	SS-215-121, SHEET 19	SS-215-121, SHEET 20	SS-215-121, SHEET 21	SS-215-121, SHEET 22	SS-215-121, SHEET 23	SS-215-121, SHEET 24	SS-215-121, SHEET 25	SS-215-121, SHEET 26	SS-215-121, SHEET 27	SS-215-121, SHEET 28	SS-215-121, SHEET 29	SS-215-121, SHEET 30	SS-215-121, SHEET 31	SS-215-121, SHEET 32	SS-215-121, SHEET 33	SS-215-121, SHEET 34	SS-215-121, SHEET 35	SS-215-121, SHEET 36	SS-215-121, SHEET 37	SS-215-121, SHEET 38	SS-215-121, SHEET 39	SS-215-121, SHEET 40	SS-215-121, SHEET 41	SS-215-121, SHEET 42	SS-215-121, SHEET 43	SS-215-121, SHEET 44	SS-215-121, SHEET 45	SS-215-121, SHEET 46	SS-215-121, SHEET 47	SS-215-121, SHEET 48	SS-215-121, SHEET 49	SS-215-121, SHEET 50
----------------------	----------------------	
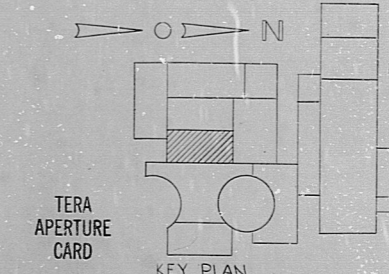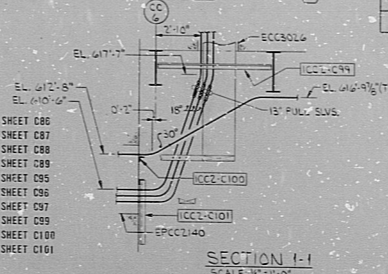

TERA APERTURE CARD KEY PLAN

REVISIONS		NO.	DATE	MADE	CHG.	APPROVAL
3/6/77	CONSTRUCTION	1				
	LIMITED CONSTRUCTION AS NOTED					
	PRELIMINARY NOT FOR CONSTRUCTION					
	BIDDING PURPOSES					
	RELEASED FOR	ENGR.				
THE CLEVELAND ELECTRIC ILLUMINATING COMPANY						
PERRY NUCLEAR POWER PLANT UNITS 1 & 2						
ELECTRICAL CONDUIT LAYOUT						
CONTROL COMPLEX - EAST EL. 50' 0"						
GILBERT ASSOCIATES, INC.						
ENGINEERS AND CONSULTANTS						
DRAFTING	ARCHITECTURAL	CIVIL	STRUCTURAL	ELECTRICAL		
DATE	DATE	DATE	DATE	DATE		
SCALE	DRAWING NUMBER					
1/8" = 1'-0"	04 4549 D-215-121 P					
044549-000						

RIDS

8112030349

