

34"

34"

22"

22"

17"

17"

11"

11"

8.5"

8.5"

8.5"

8.5"

11"

11"

17"


17"

22"

22"

34"

34"

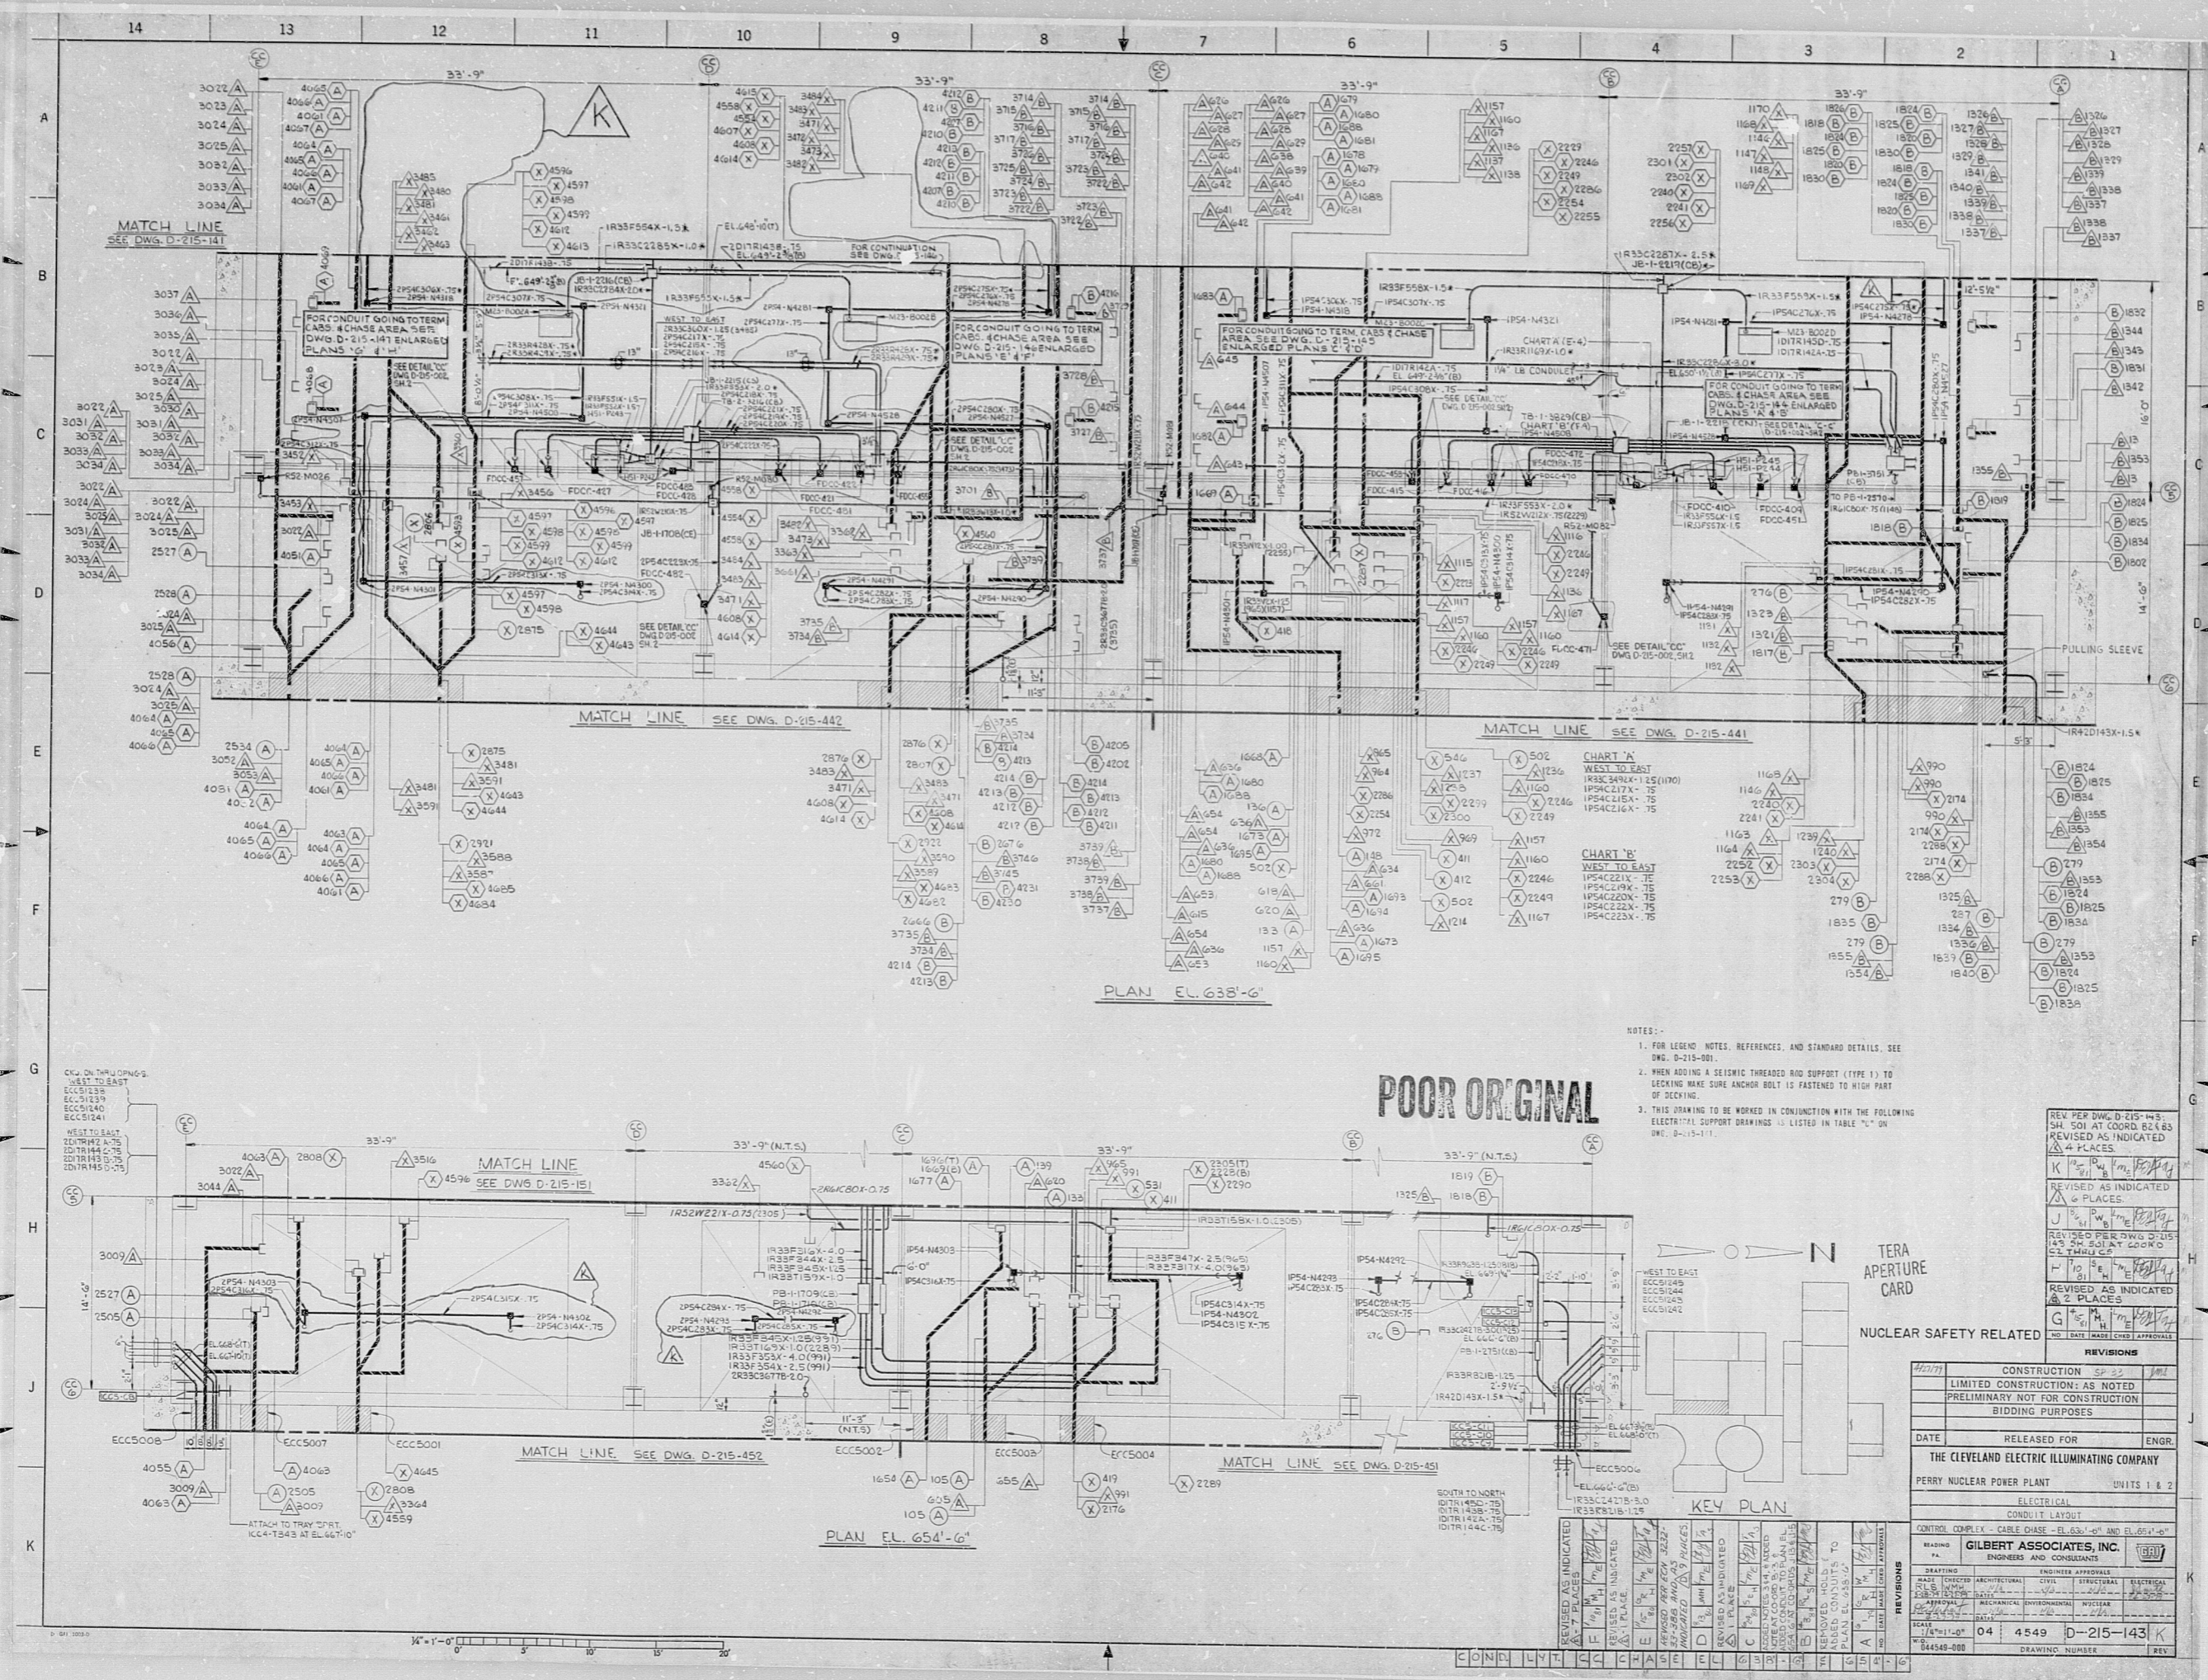

POOR ORIGINAL

- NOTES:
1. FOR LEGEND, NOTES, REFERENCES, AND STANDARD DETAILS, SEE DWG. D-215-001.
 2. WHEN ADDING A HELIXIC THREADED ROD SUPPORT (TYPE 1) TO EXISTING MAKE SURE ANCHOR BOLT IS FASTENED TO HIGH PART OF DECKING.
 3. THIS DRAWING TO BE WORKED IN CONJUNCTION WITH THE FOLLOWING ELECTRICAL SUPPORT DRAWINGS IS LISTED IN TABLE "L" ON DWG. D-215-111.

REV	DATE	DESCRIPTION
K	10/15/83	REVISED AS INDICATED IN 2 PLACES
J	10/15/83	REVISED AS INDICATED IN 2 PLACES
I	10/15/83	REVISED AS INDICATED IN 2 PLACES
H	10/15/83	REVISED AS INDICATED IN 2 PLACES
G	10/15/83	REVISED AS INDICATED IN 2 PLACES

NO.	DATE	DESCRIPTION
1	10/15/83	CONSTRUCTION
2	10/15/83	LIMITED CONSTRUCTION: AS NOTED
3	10/15/83	PRELIMINARY NOT FOR CONSTRUCTION BIDDING PURPOSES

DATE RELEASED FOR ENGR.

THE CLEVELAND ELECTRIC ILLUMINATING COMPANY

PERRY NUCLEAR POWER PLANT UNITS 1 & 2

ELECTRICAL CONDUIT LAYOUT

REVISIONS	DATE	DESCRIPTION
1	10/15/83	CONSTRUCTION
2	10/15/83	LIMITED CONSTRUCTION: AS NOTED
3	10/15/83	PRELIMINARY NOT FOR CONSTRUCTION BIDDING PURPOSES

SCALE: 1/4" = 1'-0"

04 4549 D-215-143 K

34548-008 DRAWING NUMBER

RIDS

8112030366

