


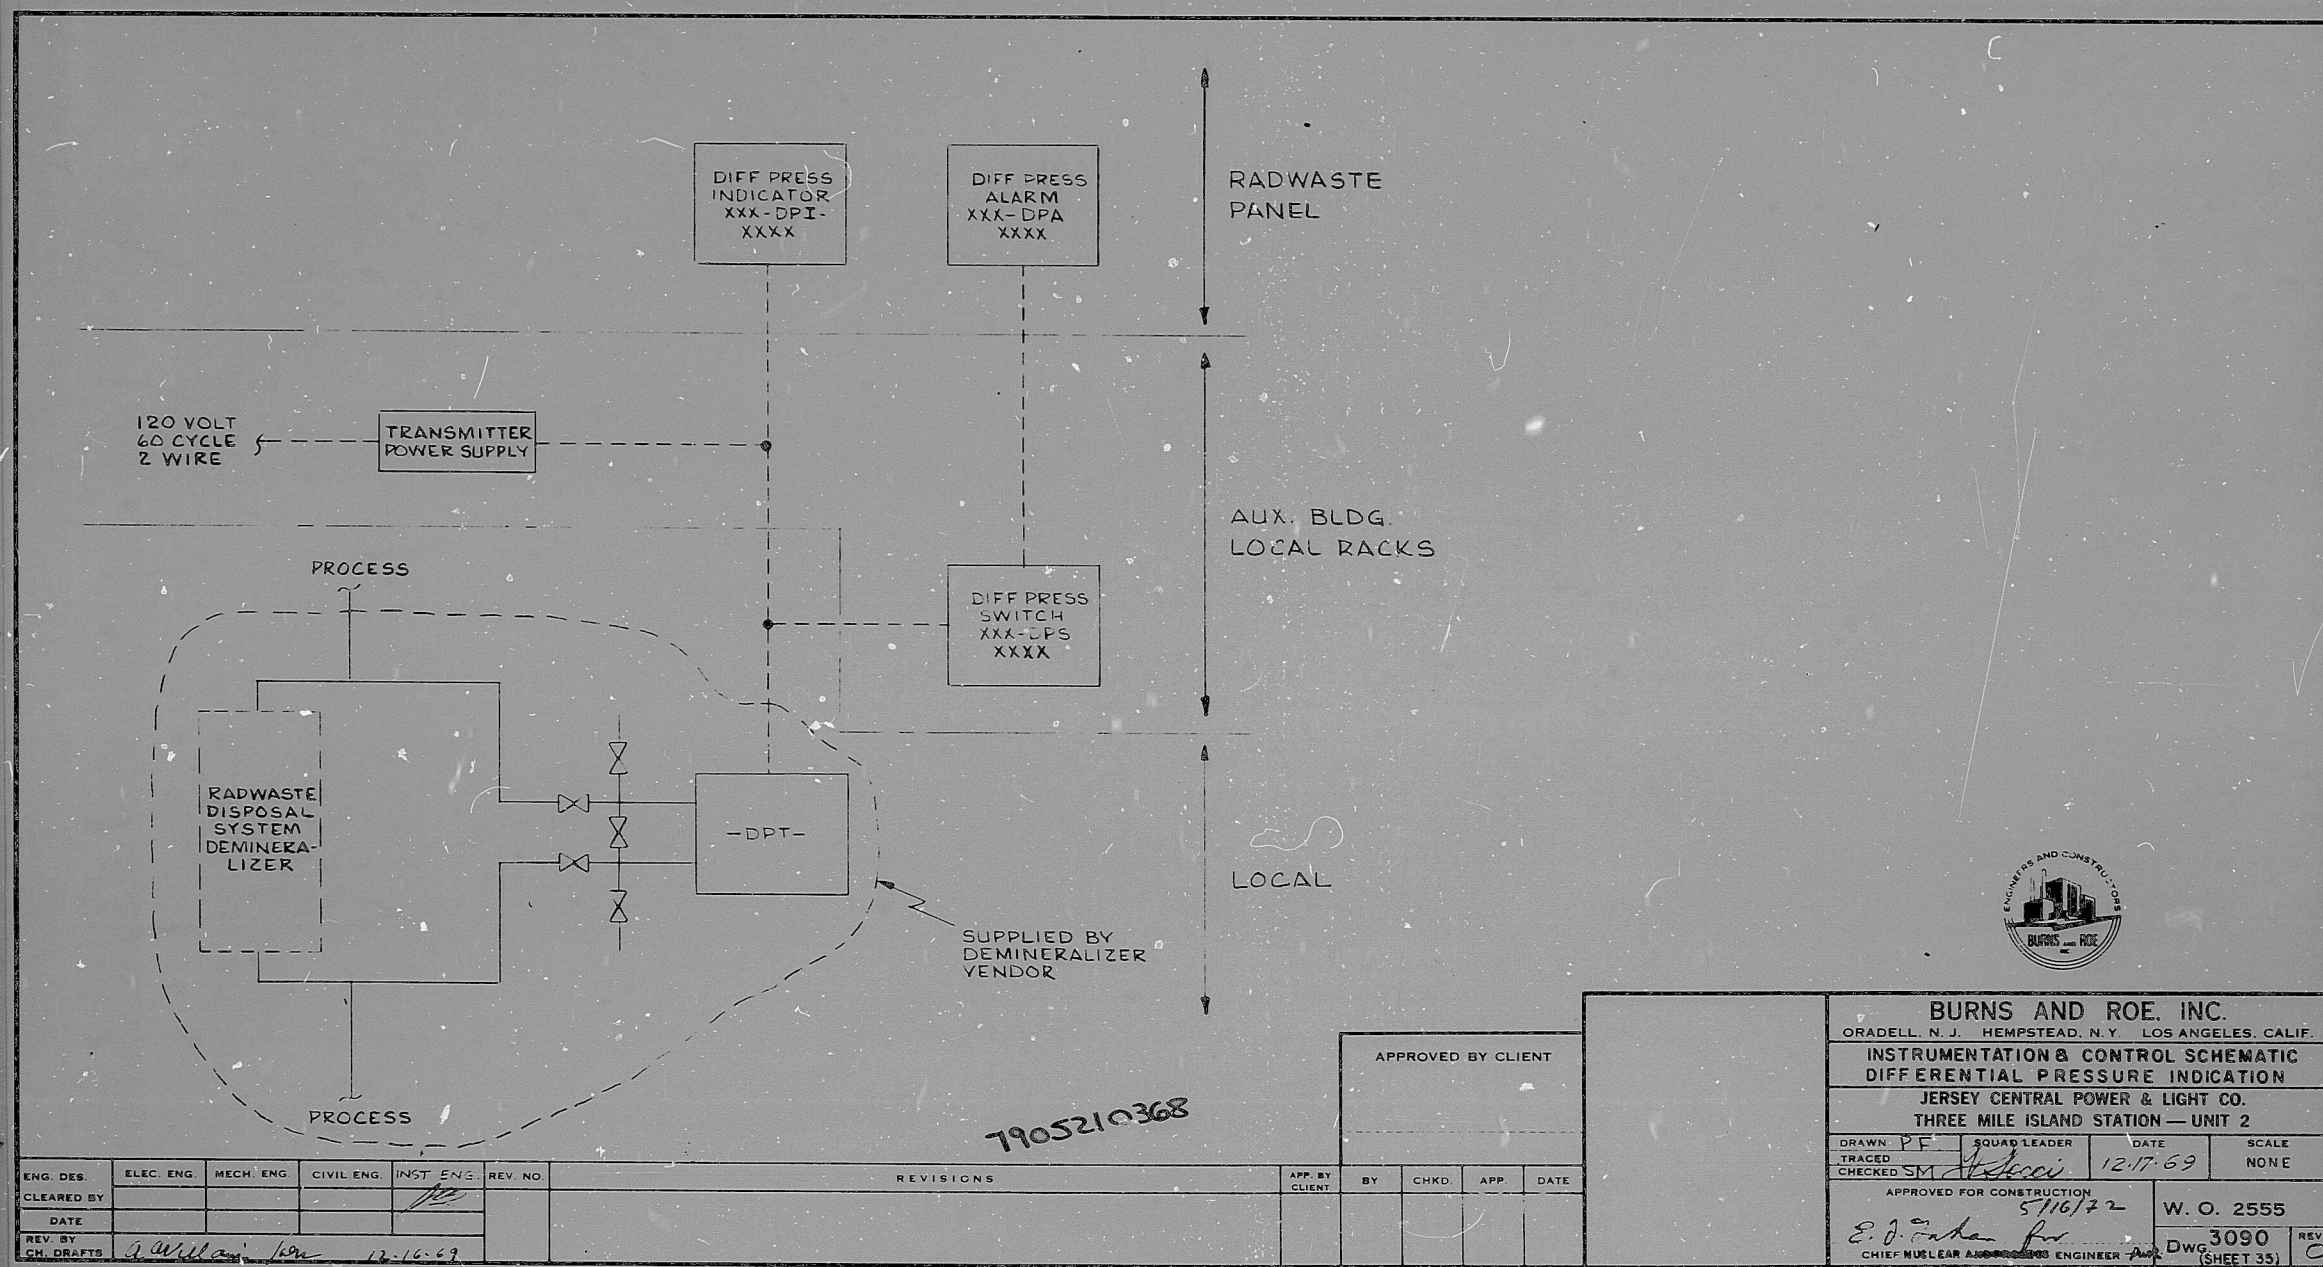

BURNS AND ROE, INC.			
ORADELL, N. J. HEMPSTEAD, N. Y. LOS ANGELES, CALIF.			
INSTRUMENTATION & CONTROL SCHEMATIC			
DIFFERENTIAL PRESSURE INDICATION			
JERSEY CENTRAL POWER & LIGHT CO.			
THREE MILE ISLAND STATION — UNIT 2			
DRAWN: PE	SQUAD LEADER	DATE	SCALE
TRACED: SM	12-17-69		NONE
CHECKED: SM			
APPROVED FOR CONSTRUCTION		W. O. 2555	
5/16/72		Dwg 3090	
E. J. Cohen for		(SHEET 33)	
CHIEF NUCLEAR ASSISTANT ENGINEER		REV 0	

7905210368

7905210368

