


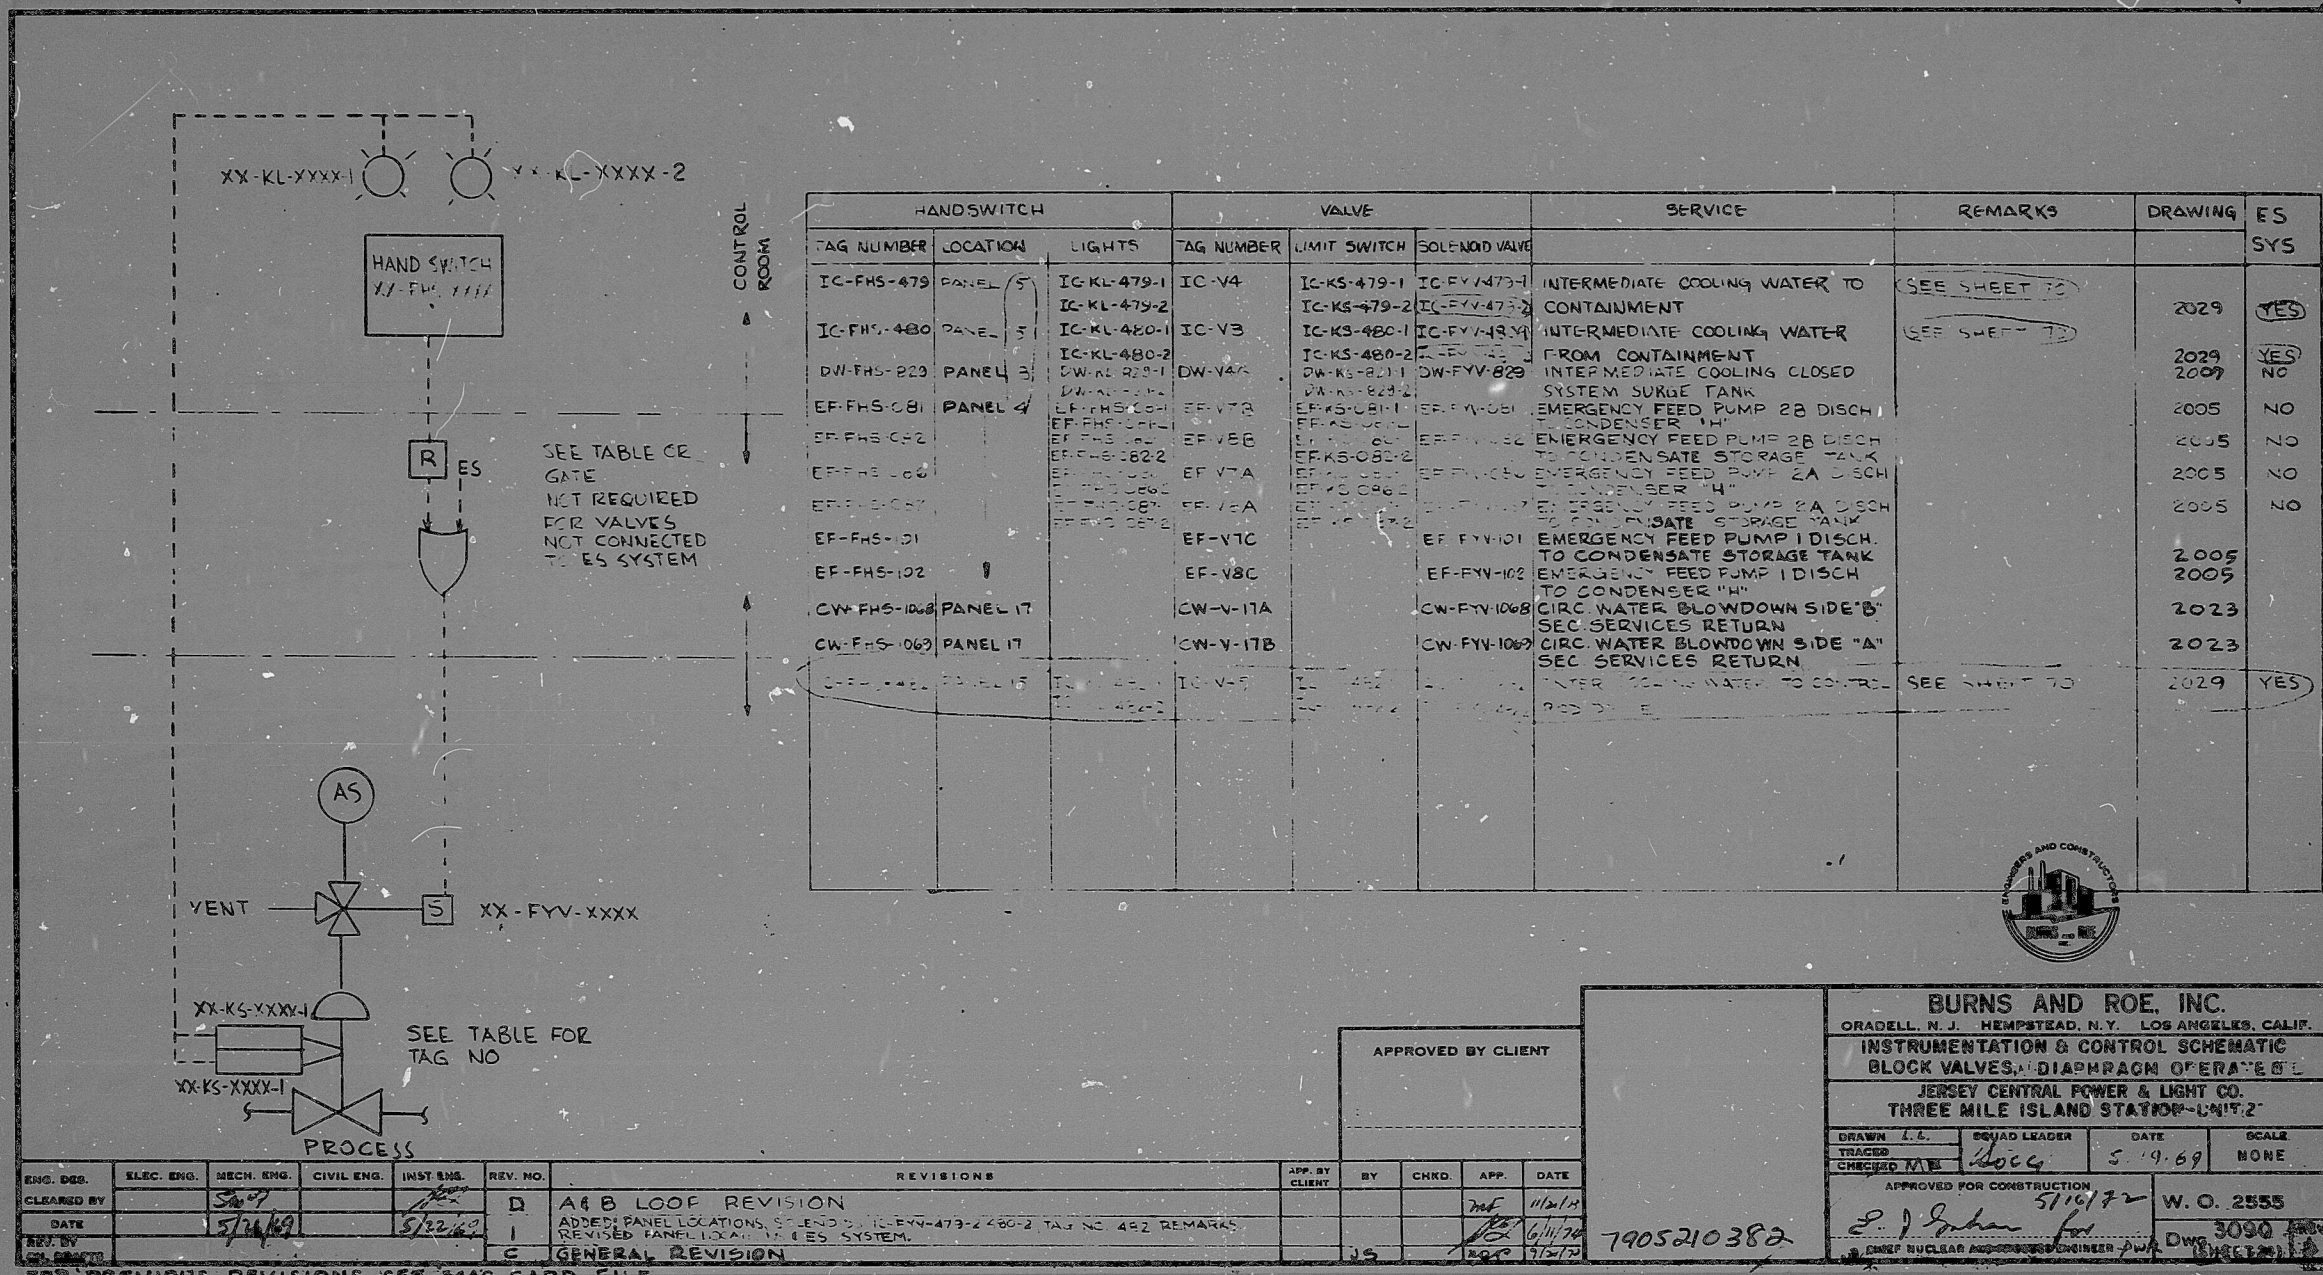

ENG. DES.	ELEC. ENG.	MECH. ENG.	CIVIL ENG.	INST. ENG.	REV. NO.

REVISIONS
D A4B LOOP REVISION
ADDED: PANEL LOCATIONS, SCHEMATIC, IC-FV-479-2, IC-FV-480-2, TAG NO. 482 REMARKS
REVISED: PANEL LOCATIONS, VALVES SYSTEM
C GENERAL REVISION

APP. BY	BY	CHKD.	APP.	DATE

DATE	SCALE
5/19/69	NONE
5/19/72	W. O. 2555
6/14/70	3090
7/15/72	3090

BURNS AND ROE, INC.
ORADELL, N.J. HEMPSTEAD, N.Y. LOS ANGELES, CALIF.
INSTRUMENTATION & CONTROL SCHEMATIC
BLOCK VALVES, DIAPHRAGM OPERATED
JERSEY CENTRAL POWER & LIGHT CO.
THREE MILE ISLAND STATION-UNIT 2
DRAWN: L.L. TRACED: M.B. CHECKED: M.B.
APPROVED FOR CONSTRUCTION: P.J. Spahan
CHIEF NUCLEAR APPROPRIATE ENGINEER

7905210382

7905210382

