


34"

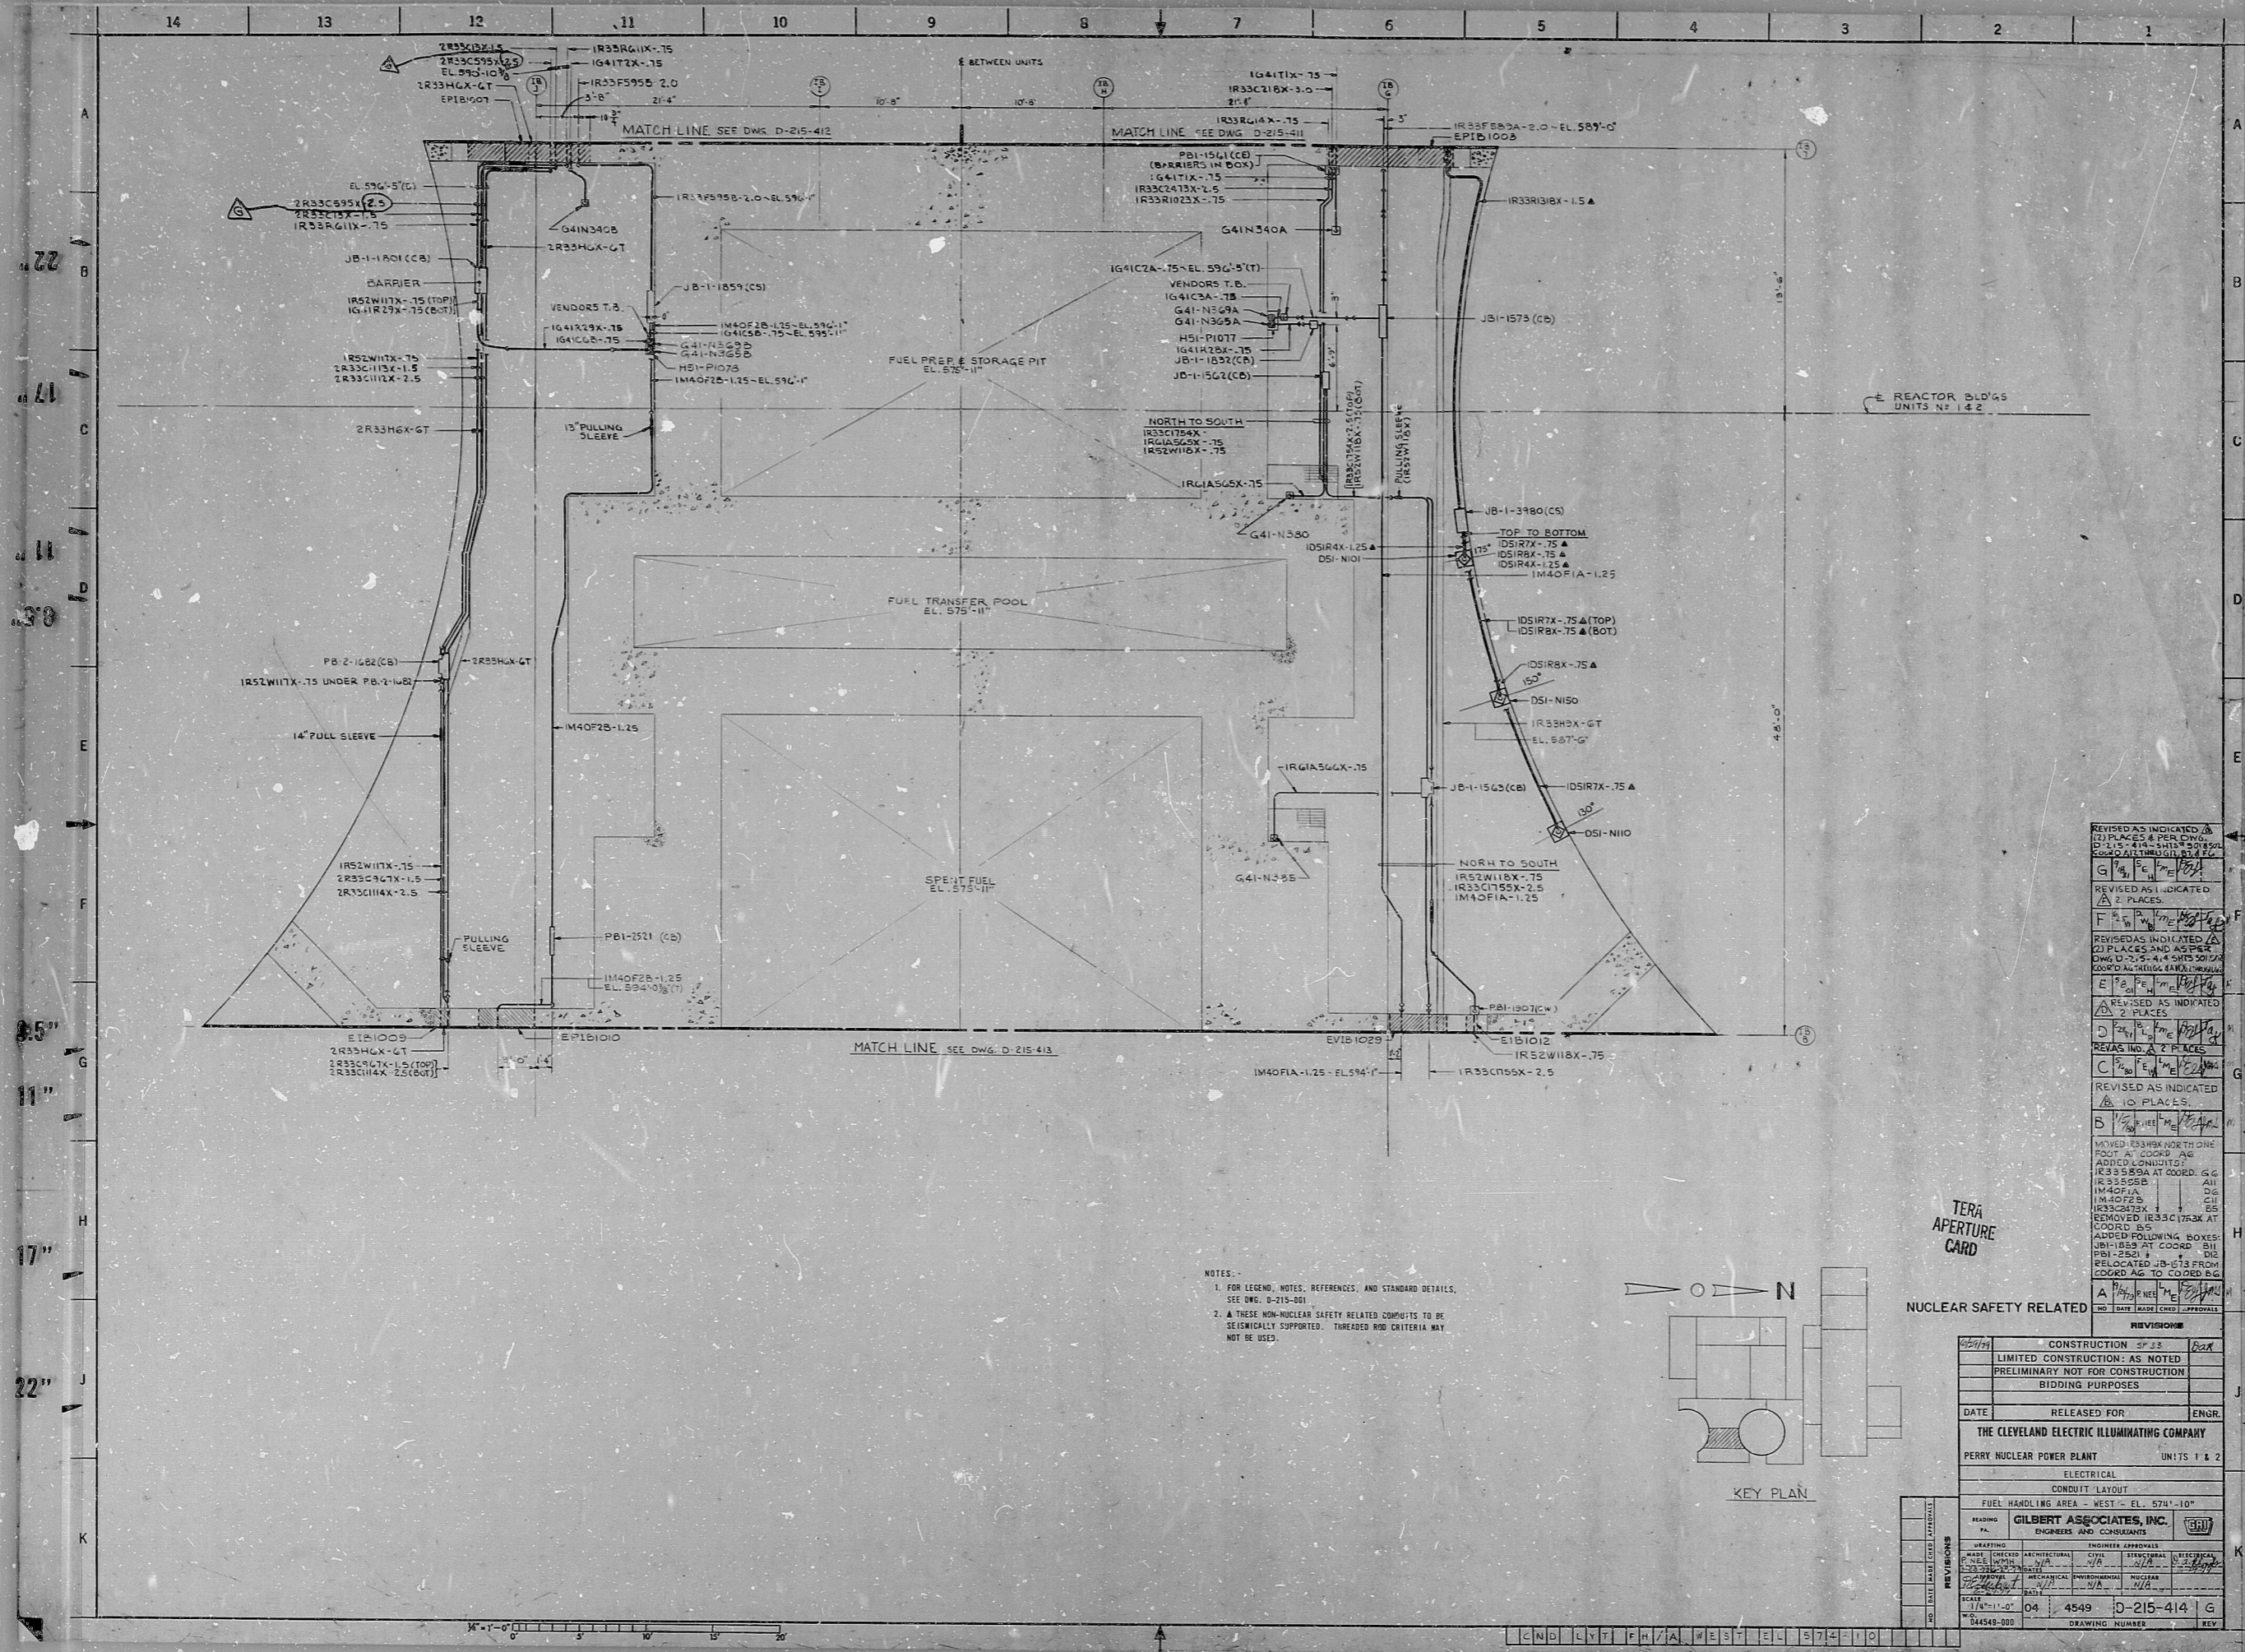


A
B
C
D
E
F
G
H
J
K

34"

14
13
12
11
10
9
8
7
6
5
4
3
2
1

REVISED AS INDICATED
 (1) PLACES & PER DIMS.
 (2) PLACES & PER DIMS.
 (3) PLACES & PER DIMS.
 (4) PLACES & PER DIMS.
 (5) PLACES & PER DIMS.
 (6) PLACES & PER DIMS.
 (7) PLACES & PER DIMS.
 (8) PLACES & PER DIMS.
 (9) PLACES & PER DIMS.
 (10) PLACES & PER DIMS.
 (11) PLACES & PER DIMS.
 (12) PLACES & PER DIMS.
 (13) PLACES & PER DIMS.
 (14) PLACES & PER DIMS.
 (15) PLACES & PER DIMS.
 (16) PLACES & PER DIMS.
 (17) PLACES & PER DIMS.
 (18) PLACES & PER DIMS.
 (19) PLACES & PER DIMS.
 (20) PLACES & PER DIMS.

NOTES:
 1. FOR LEGEND, NOTES, REFERENCES, AND STANDARD DETAILS, SEE DWG. D-215-001.
 2. THESE NON-NUCLEAR SAFETY RELATED COMPONENTS TO BE SEVERALLY SUPPORTED. THREADED ROD CRITERIA MAY NOT BE USED.

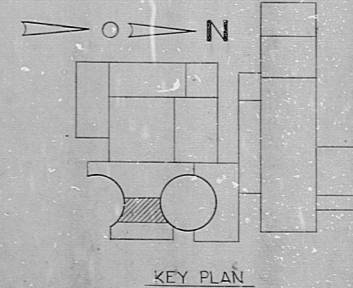

TERA APERTURE CARD

NUCLEAR SAFETY RELATED

| | | | |
|---------------------------------------------|----|---------------------------------------------------|-----------|
| CONSTRUCTION OF 23 | | DATE | ENGR. |
| LIMITED CONSTRUCTION: AS NOTED | | PRELIMINARY NOT FOR CONSTRUCTION BIDDING PURPOSES | |
| DATE RELEASED FOR: | | ENGR. | |
| THE CLEVELAND ELECTRIC ILLUMINATING COMPANY | | | |
| PERRY NUCLEAR POWER PLANT | | UNITS 1 & 2 | |
| ELECTRICAL | | | |
| CONDUIT LAYOUT | | | |
| FUEL HANDLING AREA - WEST - EL. 574'-10" | | | |
| DRAWING NO. GILBERT ASSOCIATES, INC. | | | |
| ENGINEERS AND CONSULTANTS | | | |
| DRAWING APPROVALS | | ENGINEER APPROVALS | |
| DATE | BY | DATE | BY |
| 1/8/71 | 04 | 4549 | D-215-414 |
| DRAWING NUMBER | | REV | |
| 04548-000 | | G | |

34"

34"

RIDS

8112030769

