

NOTE: 1. 120V RECEIPTS ARE FOR UNDERWATER LIGHTING - SEE DWG. D-220-434. 480V RECEIPTS ARE FOR JIB CRANES, FIH-EDTB & FIH-EDTC.

VALVE	BOX	SOLENOID NO.	LIM. SW. NO.
MPL. NO.	NO.	CND. NO.	CND. NO. (OPEN) CND. NO. (CLOSED)
G41-F045	TB-1-35	G41-F047	G41-N044
		IG41C23X	IG41C22X

NOTES:
 1. FOR LEGEND, NOTES, REFERENCES, AND DETAILS, SEE DWG. D-215-061.
 2. CONDUITS CONTINUED DOWN, SEE DWG. D-215-424.



TERA APERTURE CARD

NUCLEAR SAFETY RELATED

NO.	DATE	ISSUED	BY	APPROVED
1	5-7-58	CONSTRUCTION	SP-23	
2		LIMITED CONSTRUCTION: AS NOTED		
3		PRELIMINARY NOT FOR CONSTRUCTION		
4		BIDDING PURPOSES		

DATE: RELEASED FOR ENGR.

THE CLEVELAND ELECTRIC ILLUMINATING COMPANY

PERRY NUCLEAR POWER PLANT UNITS 1 & 2

ELECTRICAL

CONDUIT LAYOUT

FUEL HANDLING AREA - WEST - EL. 620'-6"

GILBERT ASSOCIATES, INC.



ENGINEERS AND CONSULTANTS

REVISIONS

NO.	DATE	DESCRIPTION
1	5-7-58	CONSTRUCTION
2		LIMITED CONSTRUCTION: AS NOTED
3		PRELIMINARY NOT FOR CONSTRUCTION
4		BIDDING PURPOSES

DATE: 04 4549 D-215-434 F

DRAWING NUMBER: 844549-000

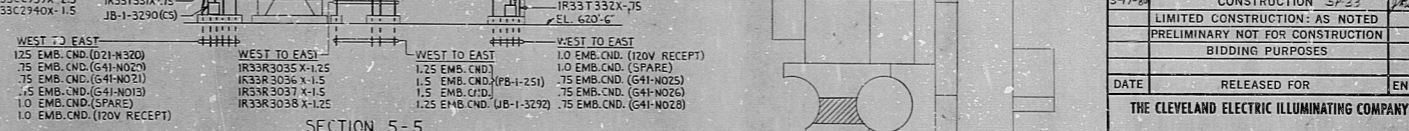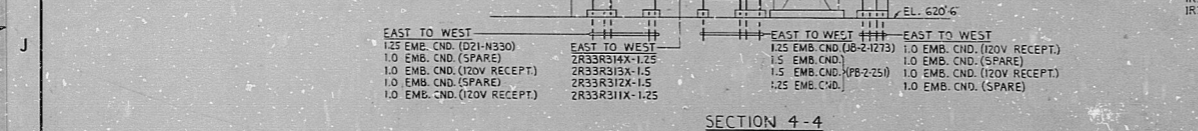

NO.	DATE	DESCRIPTION
1	5-7-58	CONSTRUCTION
2		LIMITED CONSTRUCTION: AS NOTED
3		PRELIMINARY NOT FOR CONSTRUCTION
4		BIDDING PURPOSES

DATE: 04 4549 D-215-434 F

DRAWING NUMBER: 844549-000

RIDS

8112040088

