


NOTES:
 1. FOR LEGEND, NOTES, REFERENCES, AND STANDARD DETAILS, SEE DWG. D-215-001.
 2. FOR CONDUITS CONTINUED DOWN, SEE DWG. D-215-441. FOR CONDUITS CONTINUED UP, SEE DWG. D-215-471.

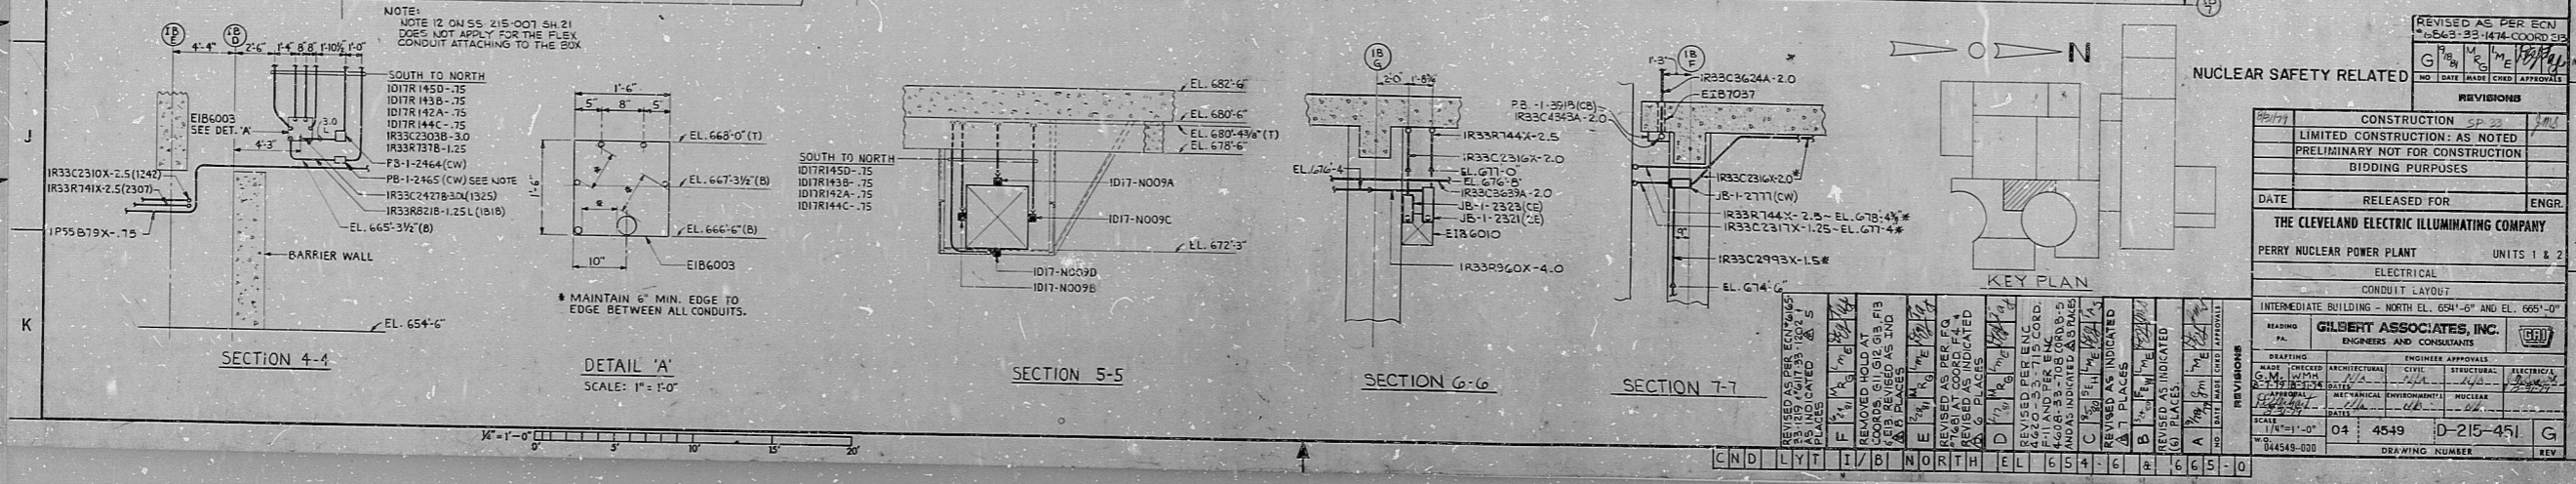

REVISIONS

NO.	DATE	DESCRIPTION
1	04/25/54	ISSUED FOR CONSTRUCTION
2	05/10/54	REVISED AS PER ECN 6563-83-1474-COORD EIP

DATE RELEASED FOR ENGR. _____

THE CLEVELAND ELECTRIC ILLUMINATING COMPANY
 PERRY NUCLEAR POWER PLANT UNITS 1 & 2
 ELECTRICAL
 CONDUIT LAYOUT
 INTERMEDIATE BUILDING - NORTH EL. 654'-0" AND EL. 665'-0"

READING: GILBERT ASSOCIATES, INC. ENGINEERS AND CONSULTANTS

DATE: 04/25/54
 DWG. NO.: D-215-451
 DRAWING NUMBER: 044548-000

14
13
12
11
10
9
8
7
6
5
4
3
2
1

A
B
C
D
E
F
G
H
J
K

8.5"
11"
17"
22"
34"

14
13
12
11
10
9
8
7
6
5
4
3
2
1

A
B
C
D
E
F
G
H
J
K

8.5"
11"
17"
22"
34"

RIDS

8112049108

