



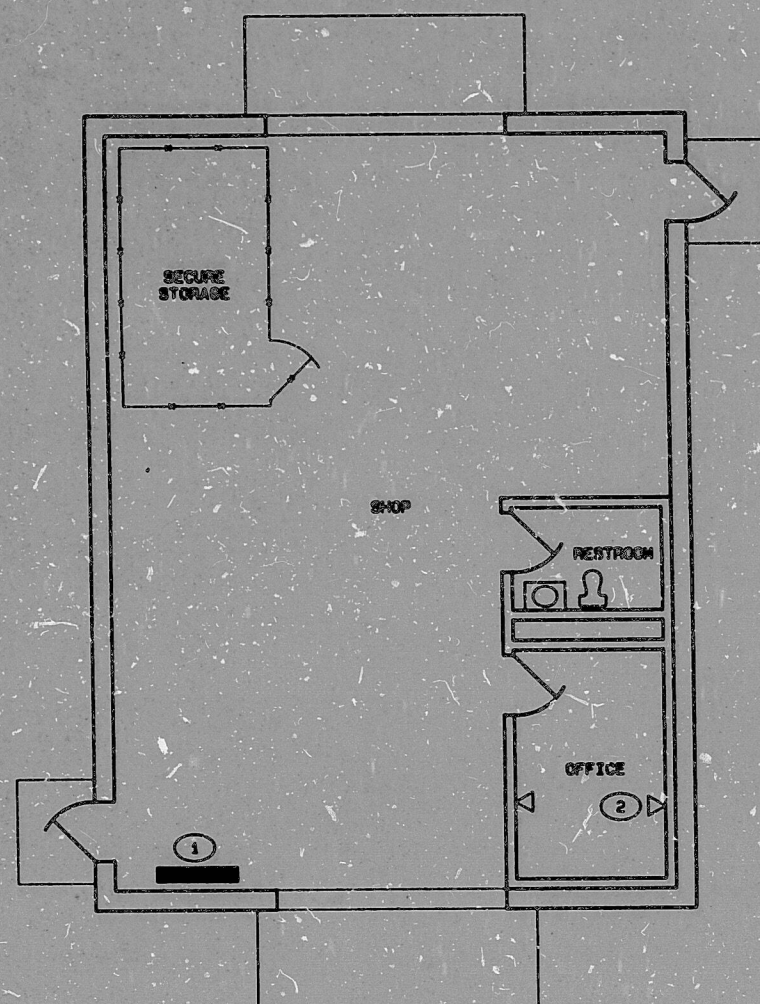

COMMUNICATIONS PLAN
SCALE: 1/4" = 1'-0"

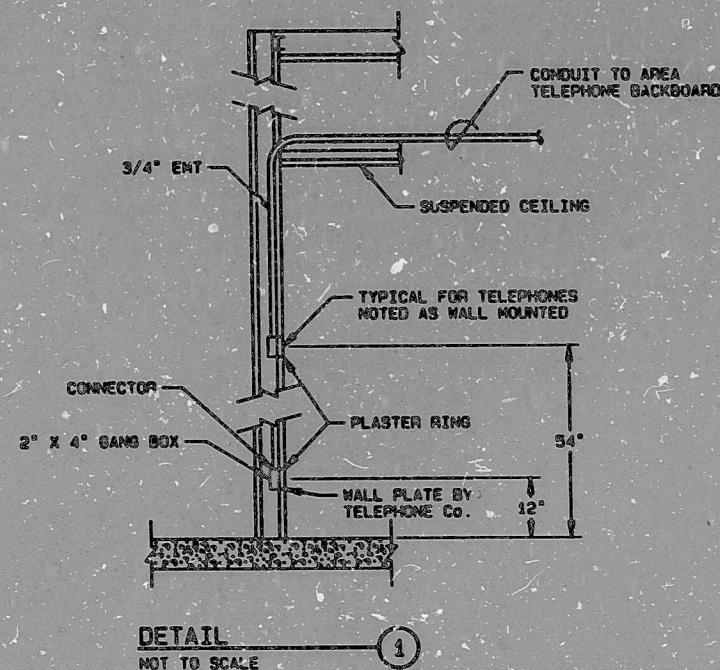

DETAIL 1
NOT TO SCALE



TITLE I

GENERAL NOTES:

1. THIS TITLE I DRAWING DEPICTS ONLY THE MAJOR DESIGN FEATURES OF THIS PROJECT. ALL DETAILS, EQUIPMENT DESCRIPTIONS, AND SPECIAL INSTRUCTIONS SHALL BE DEVELOPED DURING THE TITLE II EFFORT.
2. FOR SYMBOLS AND ABBREVIATIONS SEE DRAWING JS-025-ESF-T4.
3. FOR DRAWING INDEX SEE DRAWING JS-025-ESF-T2.
4. FOR QUALITY ASSURANCE LEVEL ASSIGNMENT SEE QALAS NO. 6.2.2-0006.
5. PAGING SPEAKERS SHALL BE INSTALLED INSIDE EACH BUILDING/TRAILER. SEE DRAWING JS-025-ESF-FPS FOR PA SYSTEM.

KEYED NOTES:

1. NEW 2' X 2' X 3/4" FIRE RETARDANT PLYWOOD TELEPHONE BACKBOARD, UL/FM KOPPERS NEX NON LEACHING PAINT.
2. TELEPHONE OUTLETS, TYPICAL SEE DETAIL 1.

REFERENCE DRAWINGS

CIVIL	JS-025-ESF-C4
STRUCTURAL	NOT USED IN TITLE I
ARCHITECTURAL	JS-025-6000-A2
MECHANICAL	JS-025-6000-M
FIRE PROTECTION	JS-025-6000-FP
ELECTRICAL	JS-025-6000-E1

SI
APERTURE
CARD

Also Available On
Aperture Card

NO.	DATE	REVISIONS		BY	CHK	DATE	BY	CHK	DATE
U.S. DEPARTMENT OF ENERGY									
NEVADA OPERATIONS OFFICE LAS VEGAS, NEVADA									
DESIGNED BY: JJJ MCCAMISH NEVADA NUCLEAR WASTE STORAGE INVESTIGATION									
CHECKED BY: G.S. EXPLORATORY SHAFT FACILITY									
SAFETY: G.S. SHOP BLDG. 6000									
PROJECT ENGINEER COMMUNICATIONS PLAN									
QUANTITY: 1000									
APPROVAL: [Signature]									
DATE: [Date]									
HOLMES & HARVEY INC. 50021E DRAWING NUMBER									
ARCHITECTS-ENGINEERS 0004526-6 JS-025-6000-W1.8									
DESIGN SUPPORT DIVISION 1000 E. PLANTING ROAD LAS VEGAS, NEVADA 89115 1 2 3 2 5 SHEET									

PDR RIDS

8811150420

