

71


11

58

8.5"

11"

17"

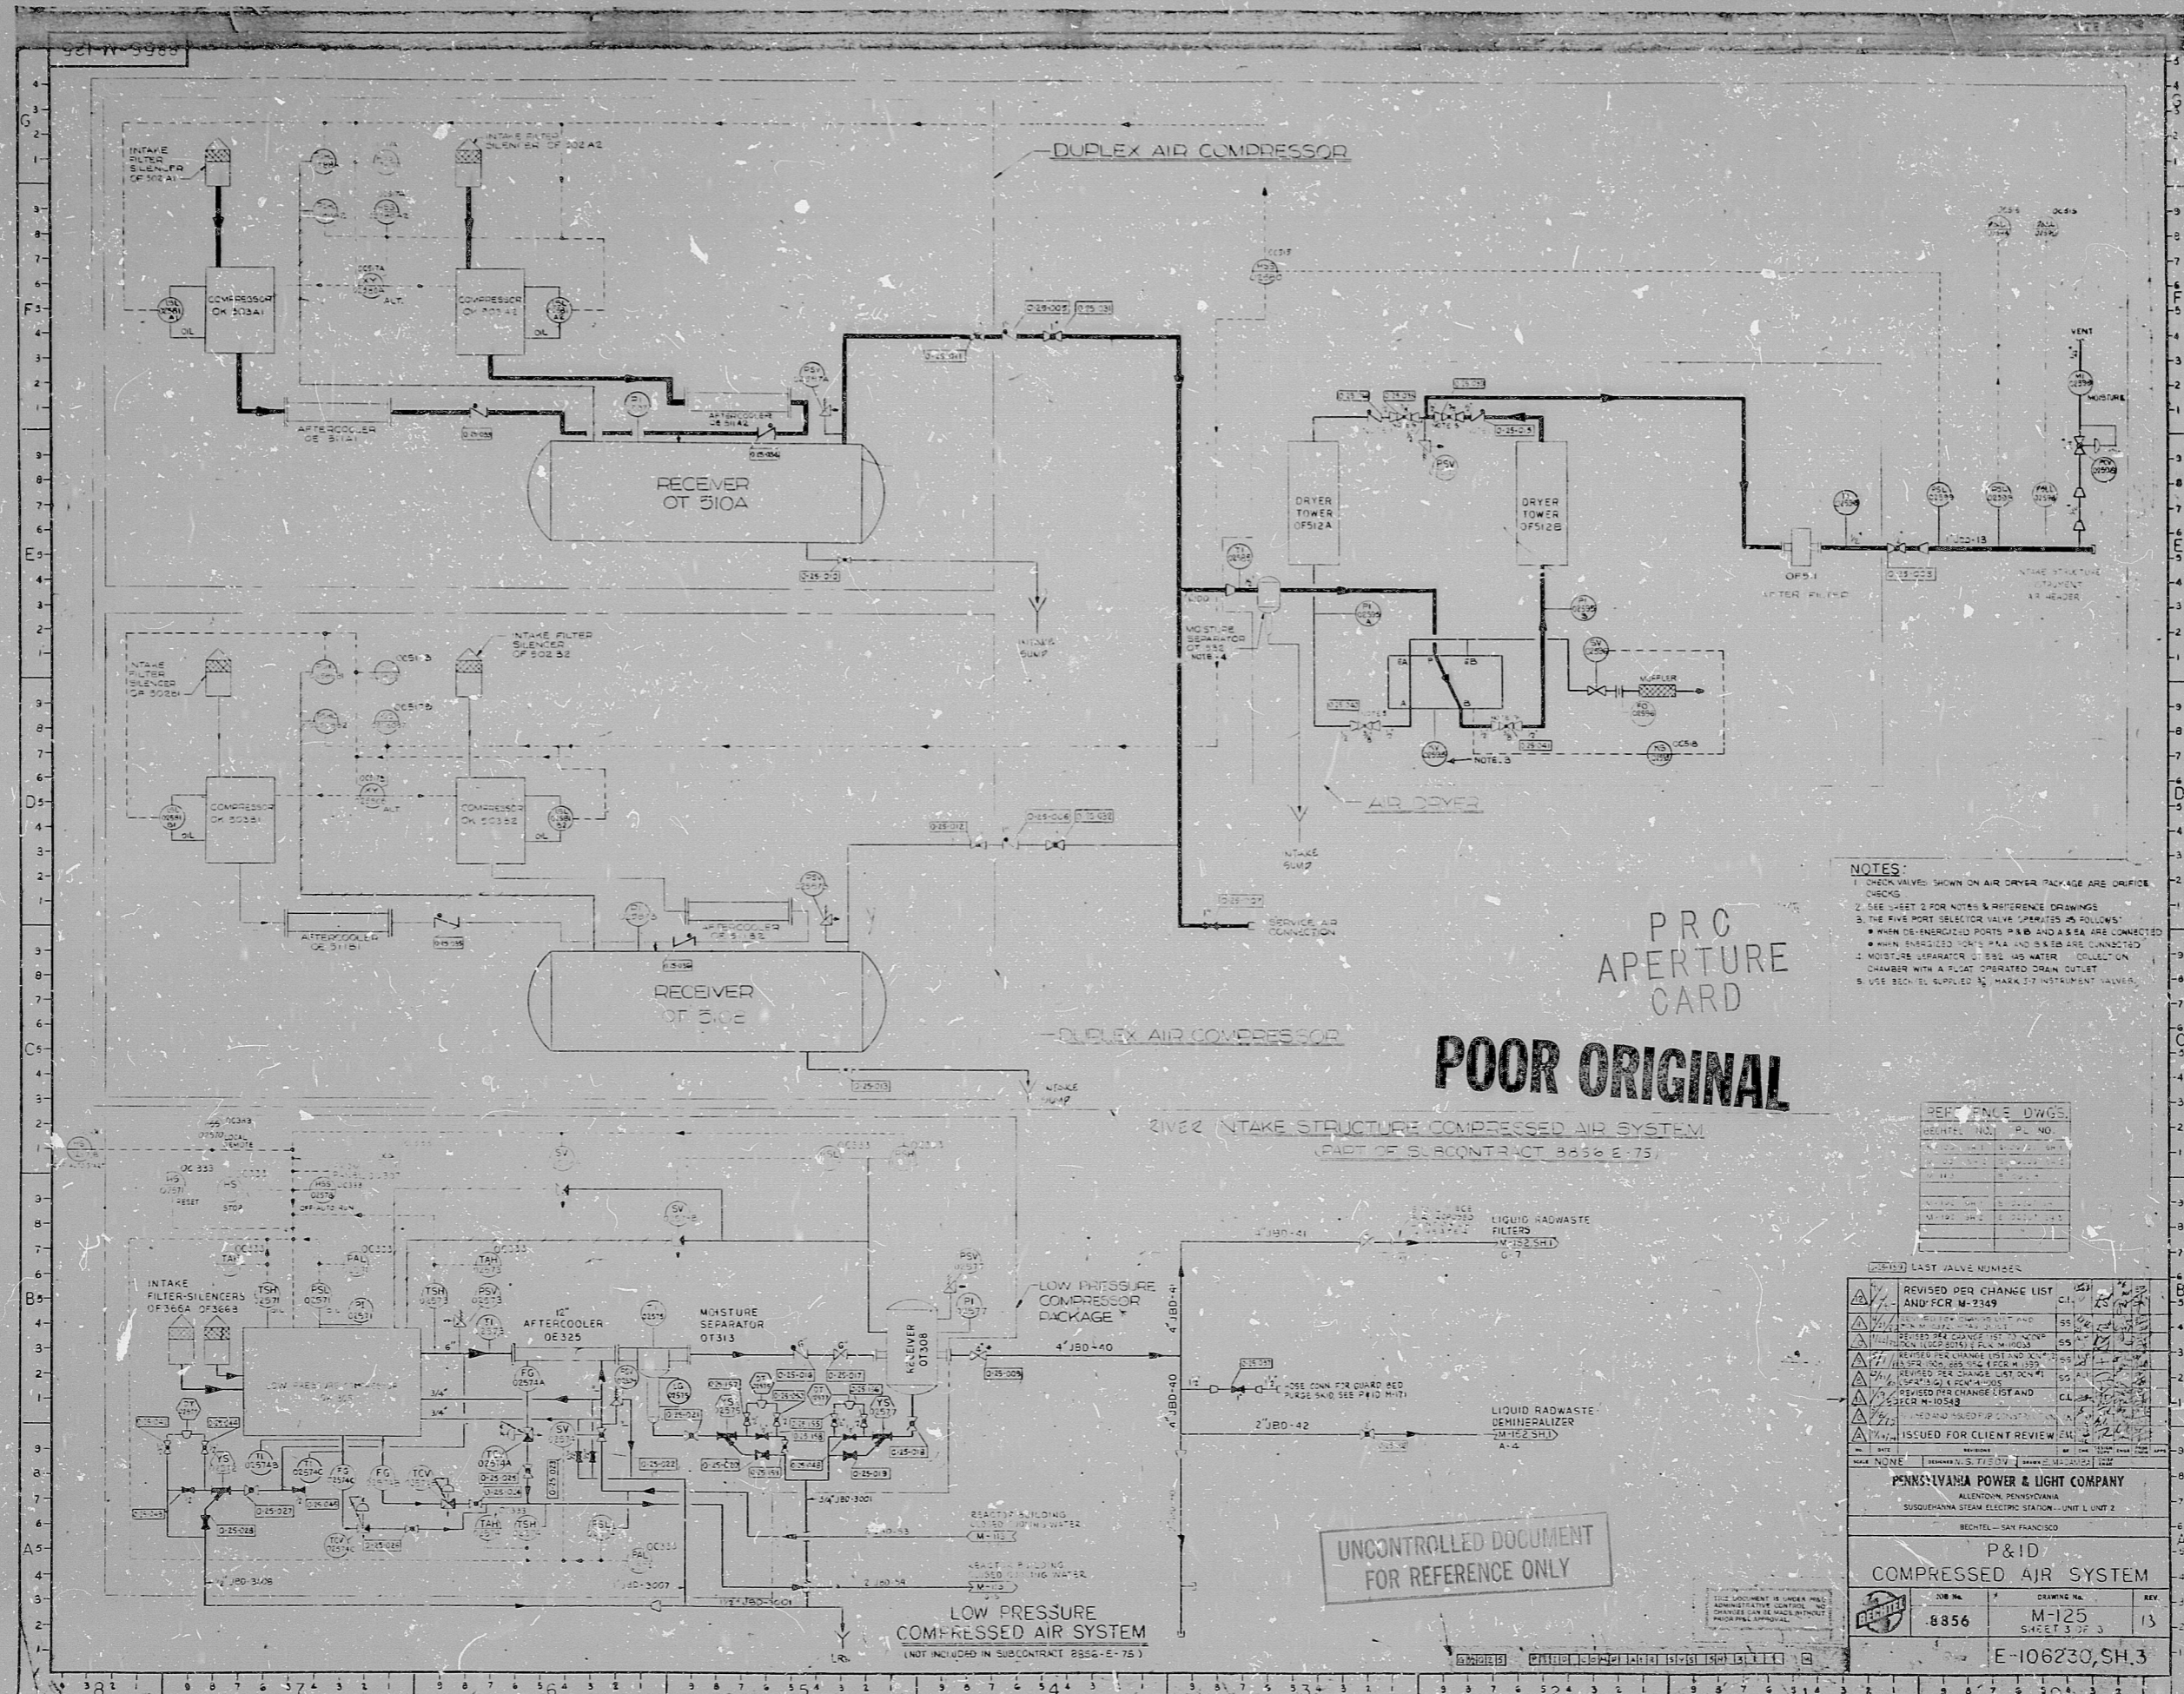

PRO  
APERTURE  
CARD  
**POOR ORIGINAL**

- NOTES:
1. CHECK VALVES SHOWN ON AIR DRYER PACKAGE ARE DRIFFER CHECKS.
  2. SEE SHEET 2 FOR NOTES & REFERENCE DRAWINGS.
  3. THE FIVE PORT SELECTOR VALVE OPERATES AS FOLLOWS:
    - WHEN DEENERGIZED PORTS A & B AND A & B ARE CONNECTED
    - WHEN ENERGIZED PORTS A & B AND B & B ARE CONNECTED
  4. MOISTURE SEPARATOR OT 311 HAS WATER COLLECTOR CHAMBER WITH A PLUG OPERATED DRAIN OUTLET.
  5. USE BECHTEL SUPPLIED 3/4" MARK 37 INSTRUMENT VALVES.

PER FACE DWGS.

REVISION NO.	PL. NO.
1	1
2	2
3	3
4	4
5	5
6	6
7	7
8	8
9	9
10	10

(LSD) LAST VALVE NUMBERS

REVISION	DATE	BY	CHKD
1	11/21/52	W. J. ...	...
2	12/1/52	...	...
3	12/1/52	...	...
4	12/1/52	...	...
5	12/1/52	...	...
6	12/1/52	...	...
7	12/1/52	...	...
8	12/1/52	...	...
9	12/1/52	...	...
10	12/1/52	...	...

PENNSYLVANIA POWER & LIGHT COMPANY  
ALLENTOWN, PENNSYLVANIA  
SUSQUEHANNA STEAM ELECTRIC STATION - UNIT 1, UNIT 2  
BECHTEL - SAN FRANCISCO

P&ID  
COMPRESSED AIR SYSTEM

DWG. NO.	DRAWING NO.	REV.
8856	M-125	13

E-106230, SH.3

UNCONTROLLED DOCUMENT  
FOR REFERENCE ONLY

30X

I certify that the information shown on this drawing was taken from the original and regular course of business. This is a true, full, correct and complete reproduction and replacement for and/or in lieu of original documents furnished by the Bechtel group of companies.  
Signed: \_\_\_\_\_ Date: 1/26/53  
Career Division

RIDS

8305250318

