



SECTION 1-1
DWG. D-215-142 (CO-ORD. C-13 THRU 4-15)
SCALE: 1/8"=1'-0"

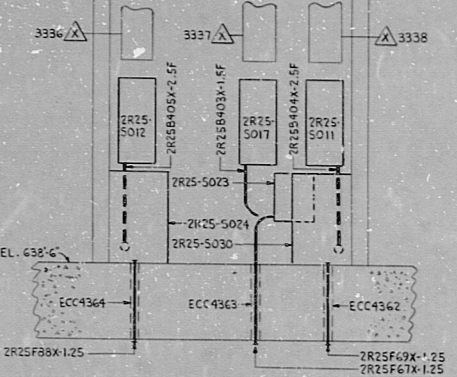

SECTION 3-3
DWG. D-215-142 (CO-ORD. B-13)
SCALE: 1/2"=1'-0"

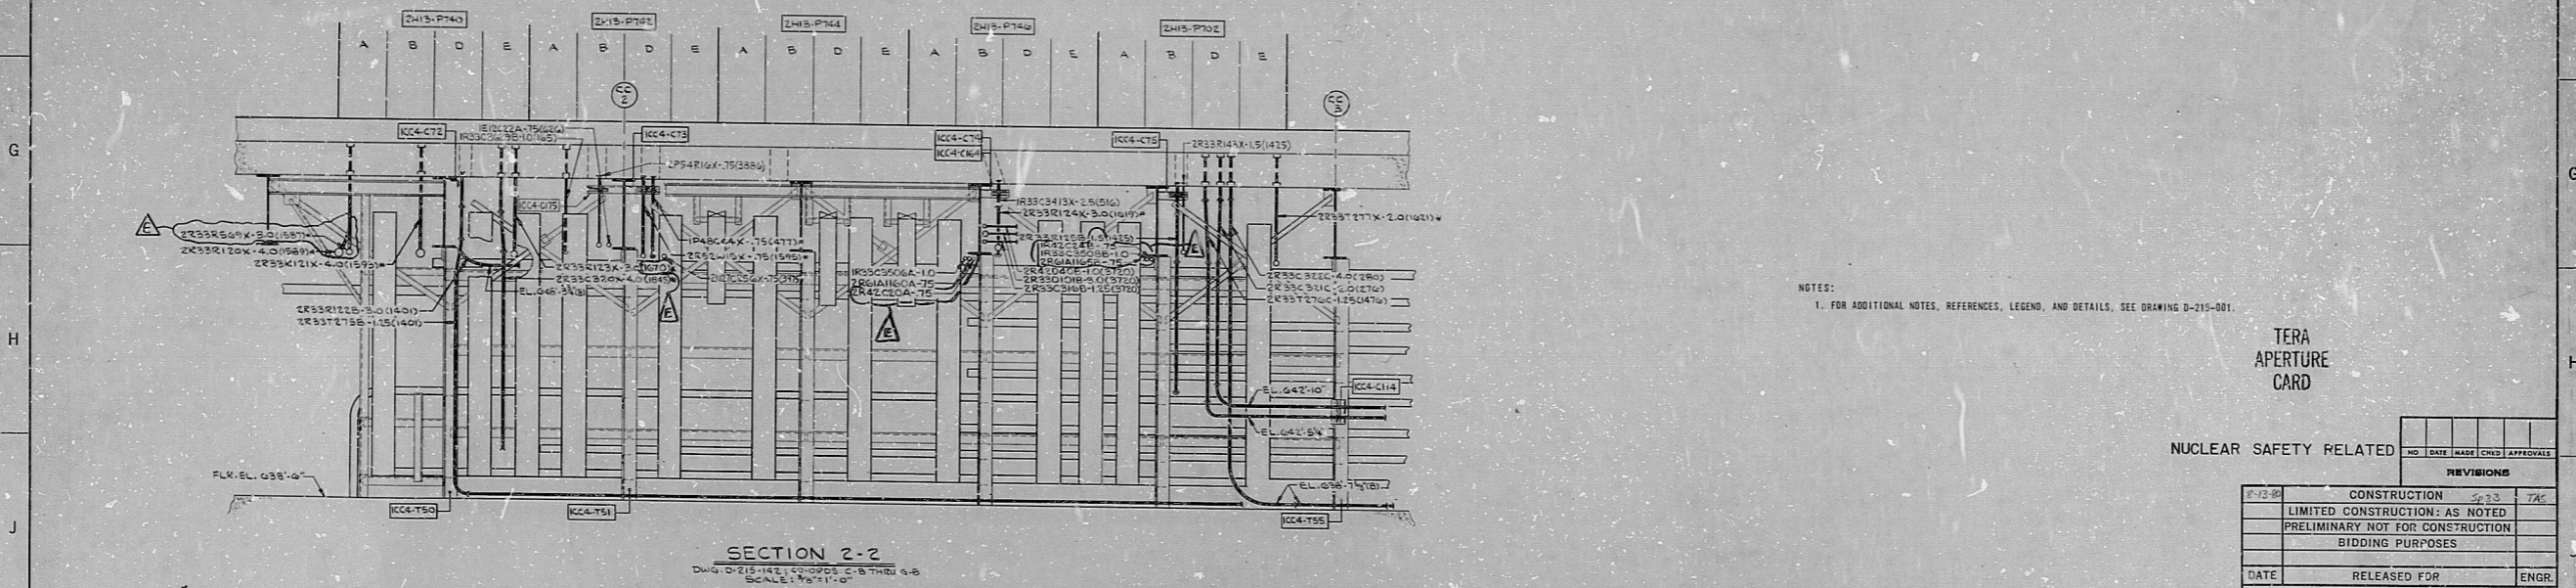

SECTION 2-2
DWG. D-215-142 (CO-ORD. C-13 THRU 4-15)
SCALE: 1/8"=1'-0"

NOTES:
1. FOR ADDITIONAL NOTES, REFERENCES, LEGEND, AND DETAILS, SEE DRAWING D-215-001.

TERA
APERTURE
CARD

NUCLEAR SAFETY RELATED

REVISIONS	
NO.	DATE / MADE / CHECK / APPROVALS
1	CONSTRUCTION 5/2/33 TAC
LIMITED CONSTRUCTION: AS NOTED	
PRELIMINARY NOT FOR CONSTRUCTION	
BIDDING PURPOSES	
DATE	RELEASED FOR ENGR.
THE CLEVELAND ELECTRIC ILLUMINATING COMPANY	
PERRY NUCLEAR POWER PLANT UNITS 1 & 2	
ELECTRICAL	
CONDUIT LAYOUT	

REVISIONS			
DATE	BY	REVISIONS	APPROVALS

NO. 04 4545 D-215-663 E

CND LYT CONTROL CMPLX SECS & DETS

RIDS

8112040174

