


8856-M-153



UNCONTROLLED DOCUMENT FOR REFERENCE ONLY

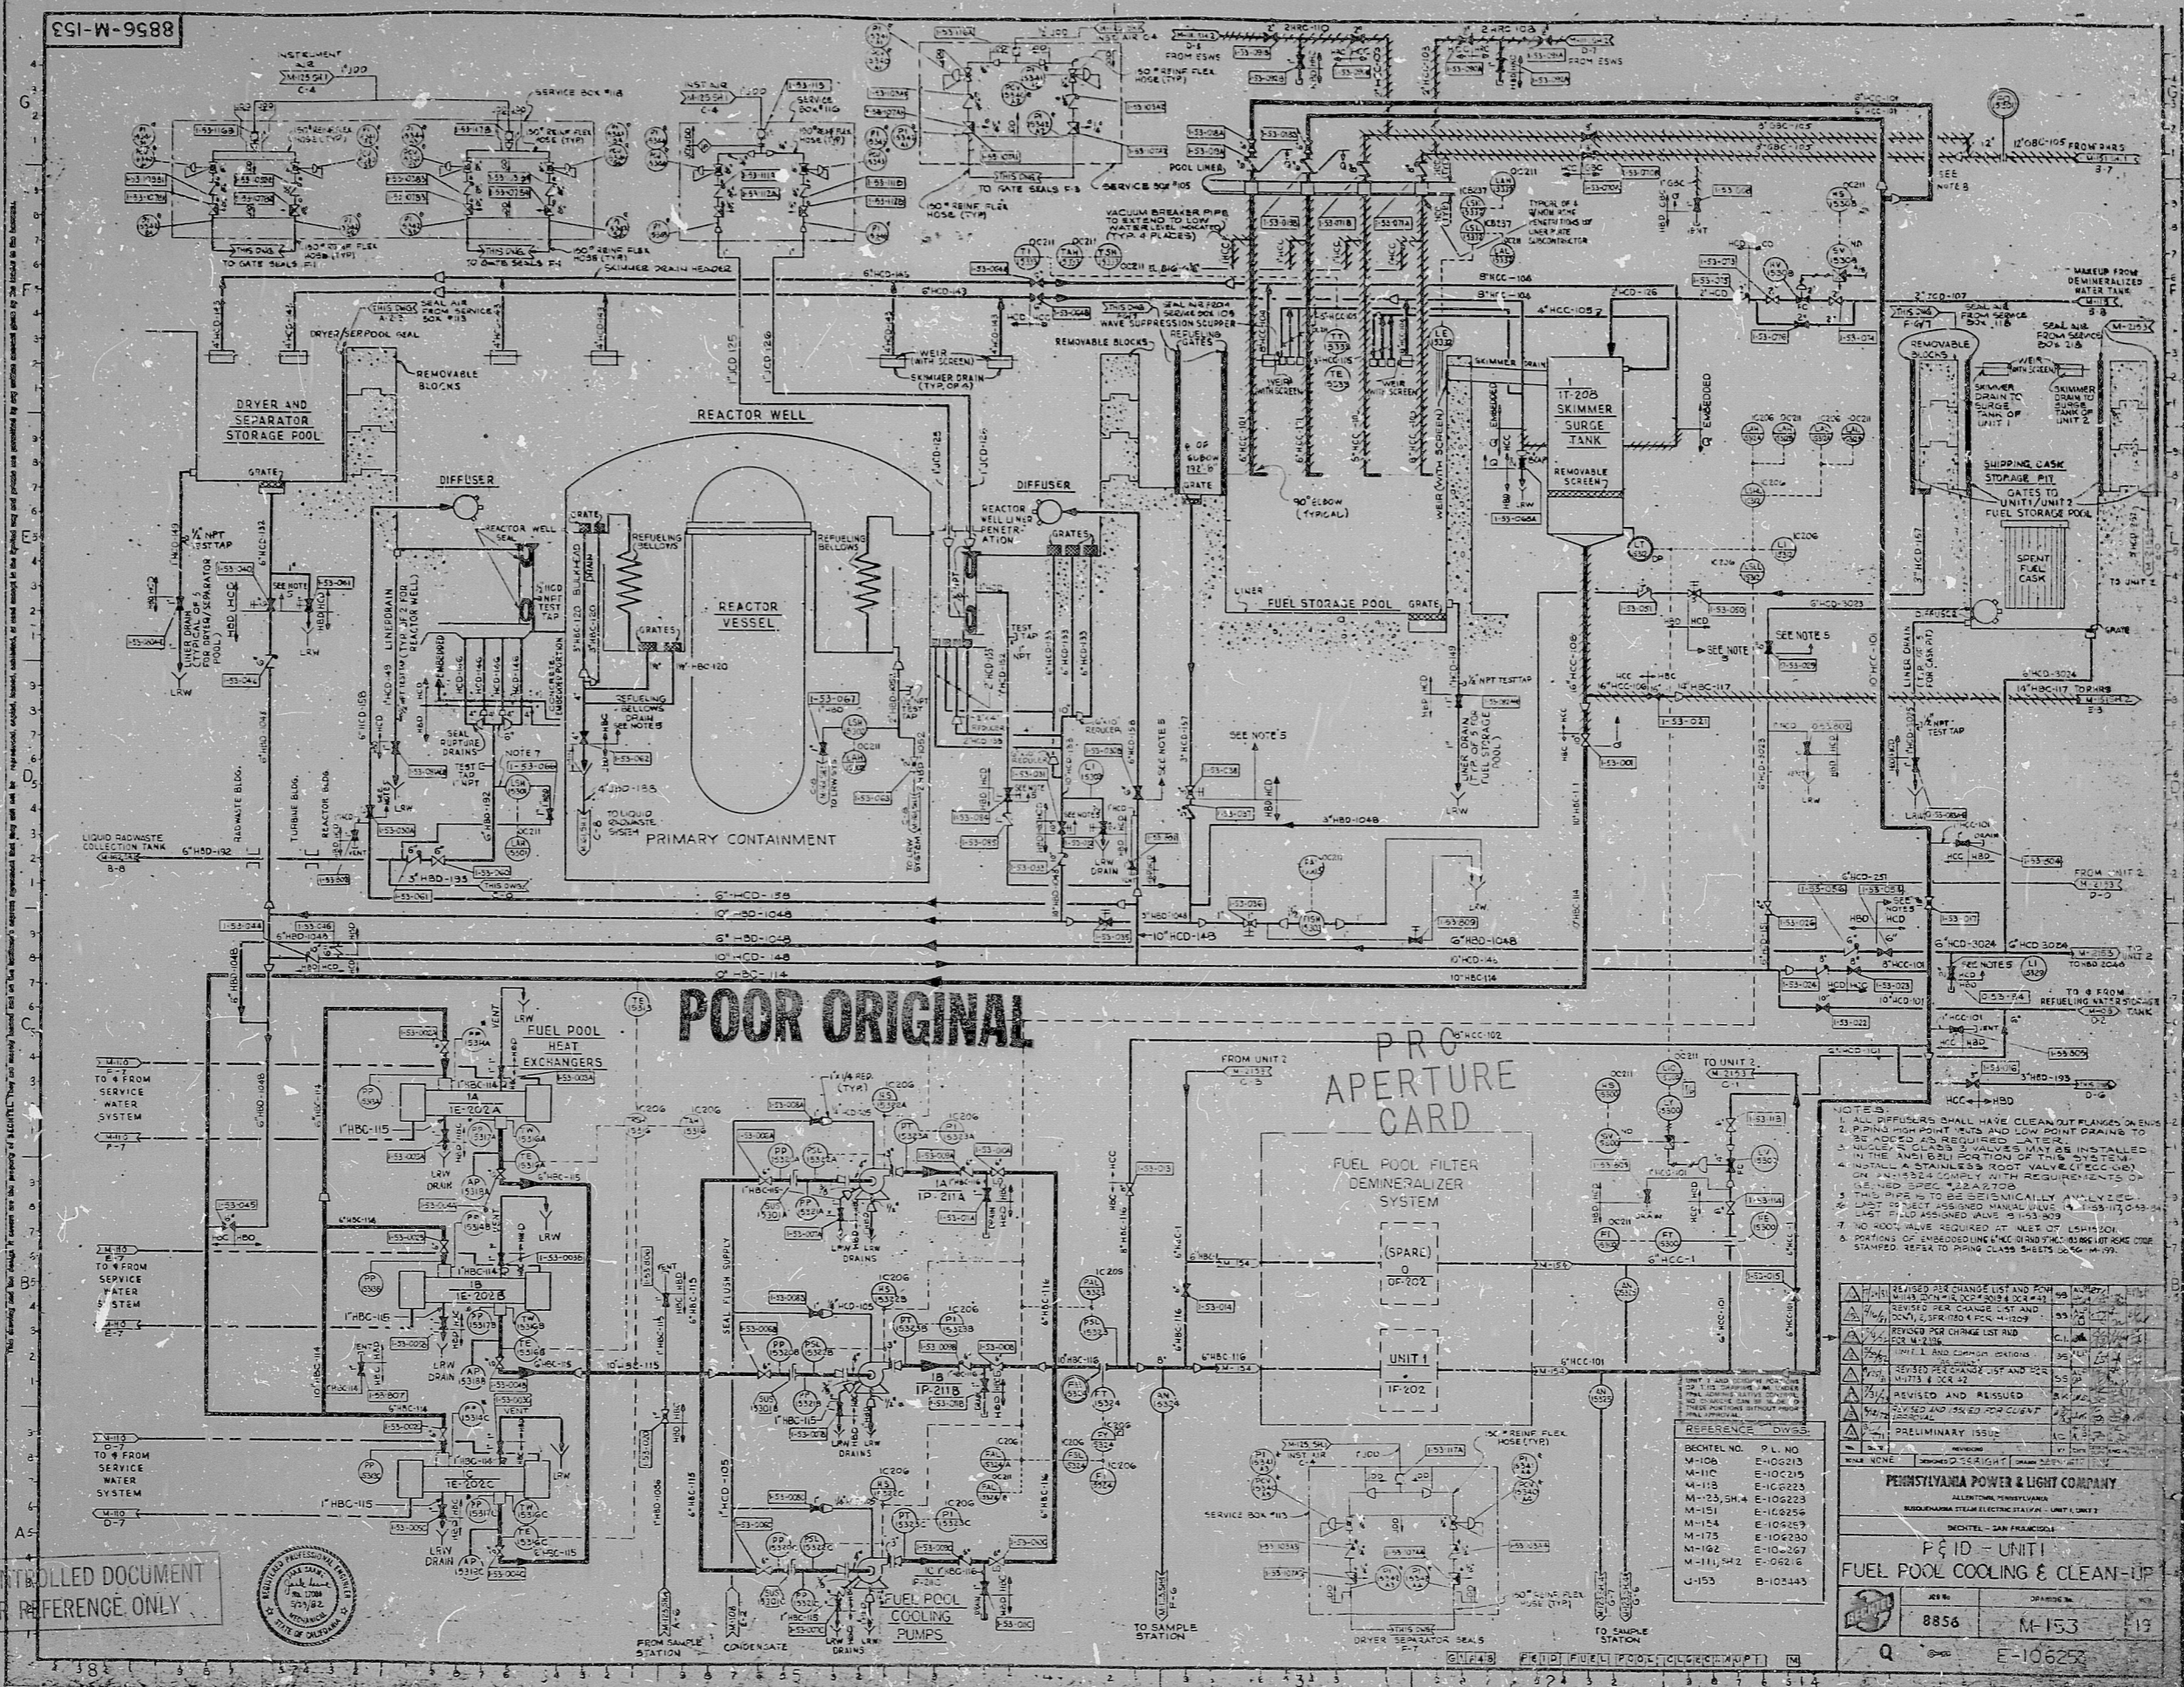

- NOTES:
1. ALL REFERENCES SHALL HAVE CLEAN OUT PLUGS AND BE ADDED AS REQUIRED LATER.
  2. PIPING HIGH POINT TRAPS AND LOW POINT DRAINS TO BE INSTALLED IN THE AMBIBL POSITION OF THIS SYSTEM.
  3. INSTALL A STAINLESS STEEL FILTER SCREEN ON EACH OF THE 1" NPT TEST TAP AS SHOWN ON THE DRAWING TO COMPLY WITH REQUIREMENTS OF THE NRC SPEC. 10.2.8.2.7.2.
  4. THIS PIPE IS TO BE PERMANENTLY ANALYZED.
  5. LISTED IS NOT ASSIGNED MATERIAL CLASSIFICATION.
  6. LAST PIPING ASSIGNED CLASS IS 10.2.8.2.7.2.
  7. NO ROOT WAVE REQUIRED AT AREA OF 1.5" DIA. 10' HUB.
  8. PORTIONS OF UNBIDDED LINES AND/OR EQUIPMENT SHALL BE STAMPED REFER TO DRAWING CLASS SHOWN ON DRAWING.

REVISION	DATE	BY	CHKD
1	10/27/82	...	...
2	...	...	...
3	...	...	...
4	...	...	...
5	...	...	...
6	...	...	...
7	...	...	...
8	...	...	...
9	...	...	...
10	...	...	...

PENNSYLVANIA POWER & LIGHT COMPANY

P&ID - UNIT 1 FUEL POOL COOLING & CLEAN-UP

REV. NO.	DRAWING NO.	DATE
8856	M-153	1/17
E-106253		

17"

8.5"

8.5"

11"

17"

17"

8.5"

8.5"

11"

17"

I certify that the information contained on this document was made available to the public in accordance with the provisions of the Freedom of Information Act, 5 U.S.C. 552.

RIDS

8305250366

