

26

26

22

22

21

21

11

11

20

20

8.5"

8.5"

11"

11"

17"


17"

22"

22"

34"

34"

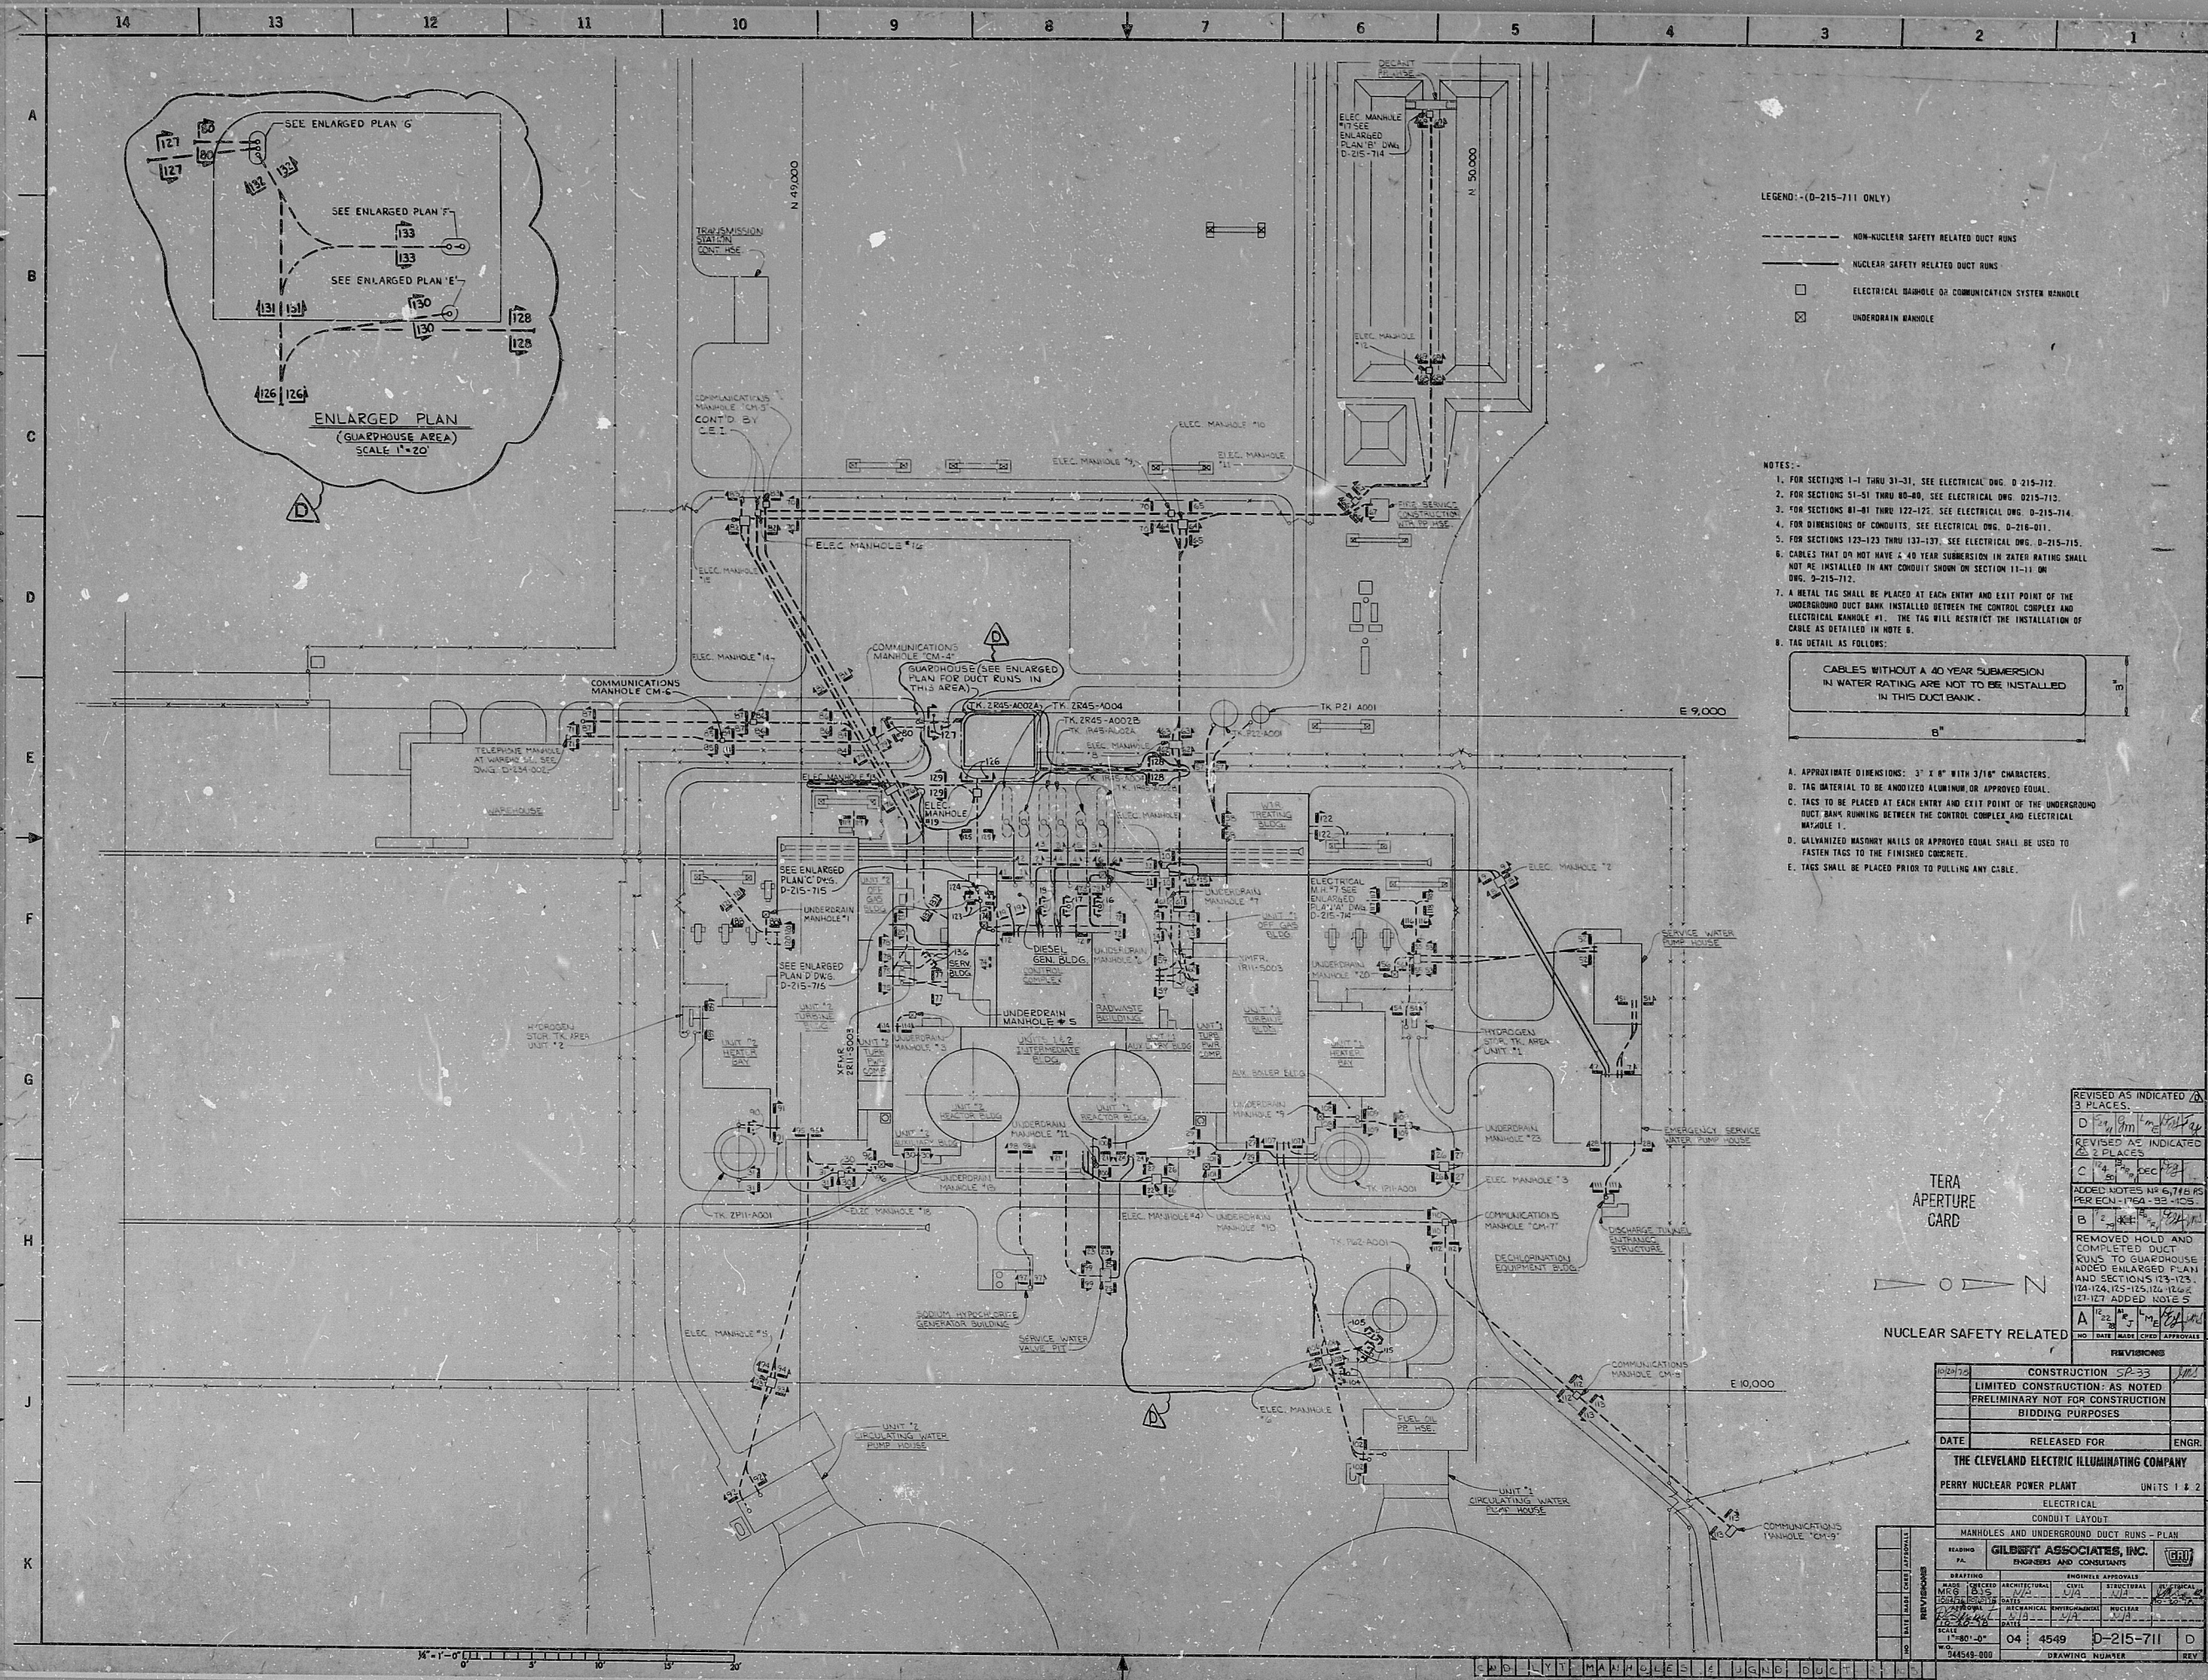


LEGEND (D-215-711 ONLY)

- NON-NUCLEAR SAFETY RELATED DUCT RUNS
- NUCLEAR SAFETY RELATED DUCT RUNS
- ELECTRICAL MANHOLE OR COMMUNICATION SYSTEM MANHOLE
- UNDERDRAIN MANHOLE

NOTES:

 1. FOR SECTIONS 1-1 THRU 31-31, SEE ELECTRICAL DWG. D-215-712.
2. FOR SECTIONS 31-31 THRU 40-40, SEE ELECTRICAL DWG. D-215-713.
3. FOR SECTIONS 40-40 THRU 122-122, SEE ELECTRICAL DWG. D-215-714.
4. FOR DIMENSIONS OF CONDUITS, SEE ELECTRICAL DWG. D-215-711.
5. FOR SECTIONS 122-122 THRU 132-132, SEE ELECTRICAL DWG. D-215-715.
6. CABLES THAT DO NOT HAVE A 40 YEAR SUBMERSION IN WATER RATING SHALL NOT BE INSTALLED IN ANY CONDUIT SHOWN ON SECTION 11-11 OR DWG. D-215-712.
7. A RETAIL TAG SHALL BE PLACED AT EACH ENTRY AND EXIT POINT OF THE UNDERGROUND DUCT BANK INSTALLED BETWEEN THE CONTROL COMPLEX AND ELECTRICAL MANHOLE #1. THE TAG WILL RESTRICT THE INSTALLATION OF CABLE AS DETAILED IN NOTE 6.
8. TAG DETAIL AS FOLLOWS:



- A. APPROXIMATE DIMENSIONS: 3" x 6" WITH 3/16" CHARACTERS.
- B. TAG MATERIAL TO BE ANODIZED ALUMINUM OR APPROVED EQUAL.
- C. TAGS TO BE PLACED AT EACH ENTRY AND EXIT POINT OF THE UNDERGROUND DUCT BANK RUNNING BETWEEN THE CONTROL COMPLEX AND ELECTRICAL MANHOLE #1.
- D. GALVANIZED MASONRY WALLS OR APPROVED EQUAL SHALL BE USED TO FASTEN TAGS TO THE FINISHED CONCRETE.
- E. TAGS SHALL BE PLACED PRIOR TO PULLING ANY CABLE.

TERA  
APERTURE  
CARD

NUCLEAR SAFETY RELATED

REVISED AS INDICATED		3 PLACES		
REVISED AS INDICATED		2 PLACES		
ADDED NOTES NR 6, 7, 8, 999, 1000		DATE	RELEASED FOR	ENGR.
THE CLEVELAND ELECTRIC ILLUMINATING COMPANY				
PERRY NUCLEAR POWER PLANT				
ELECTRICAL				
CONDUIT LAYOUT				
MANHOLES AND UNDERGROUND DUCT RUNS - PLAN				
DRAWING NO. 04 4549 D-215-711 D				
DRAWING NUMBER				
REV				



RDS

8/12040/99

