

11

58

8.5"

11"

17"

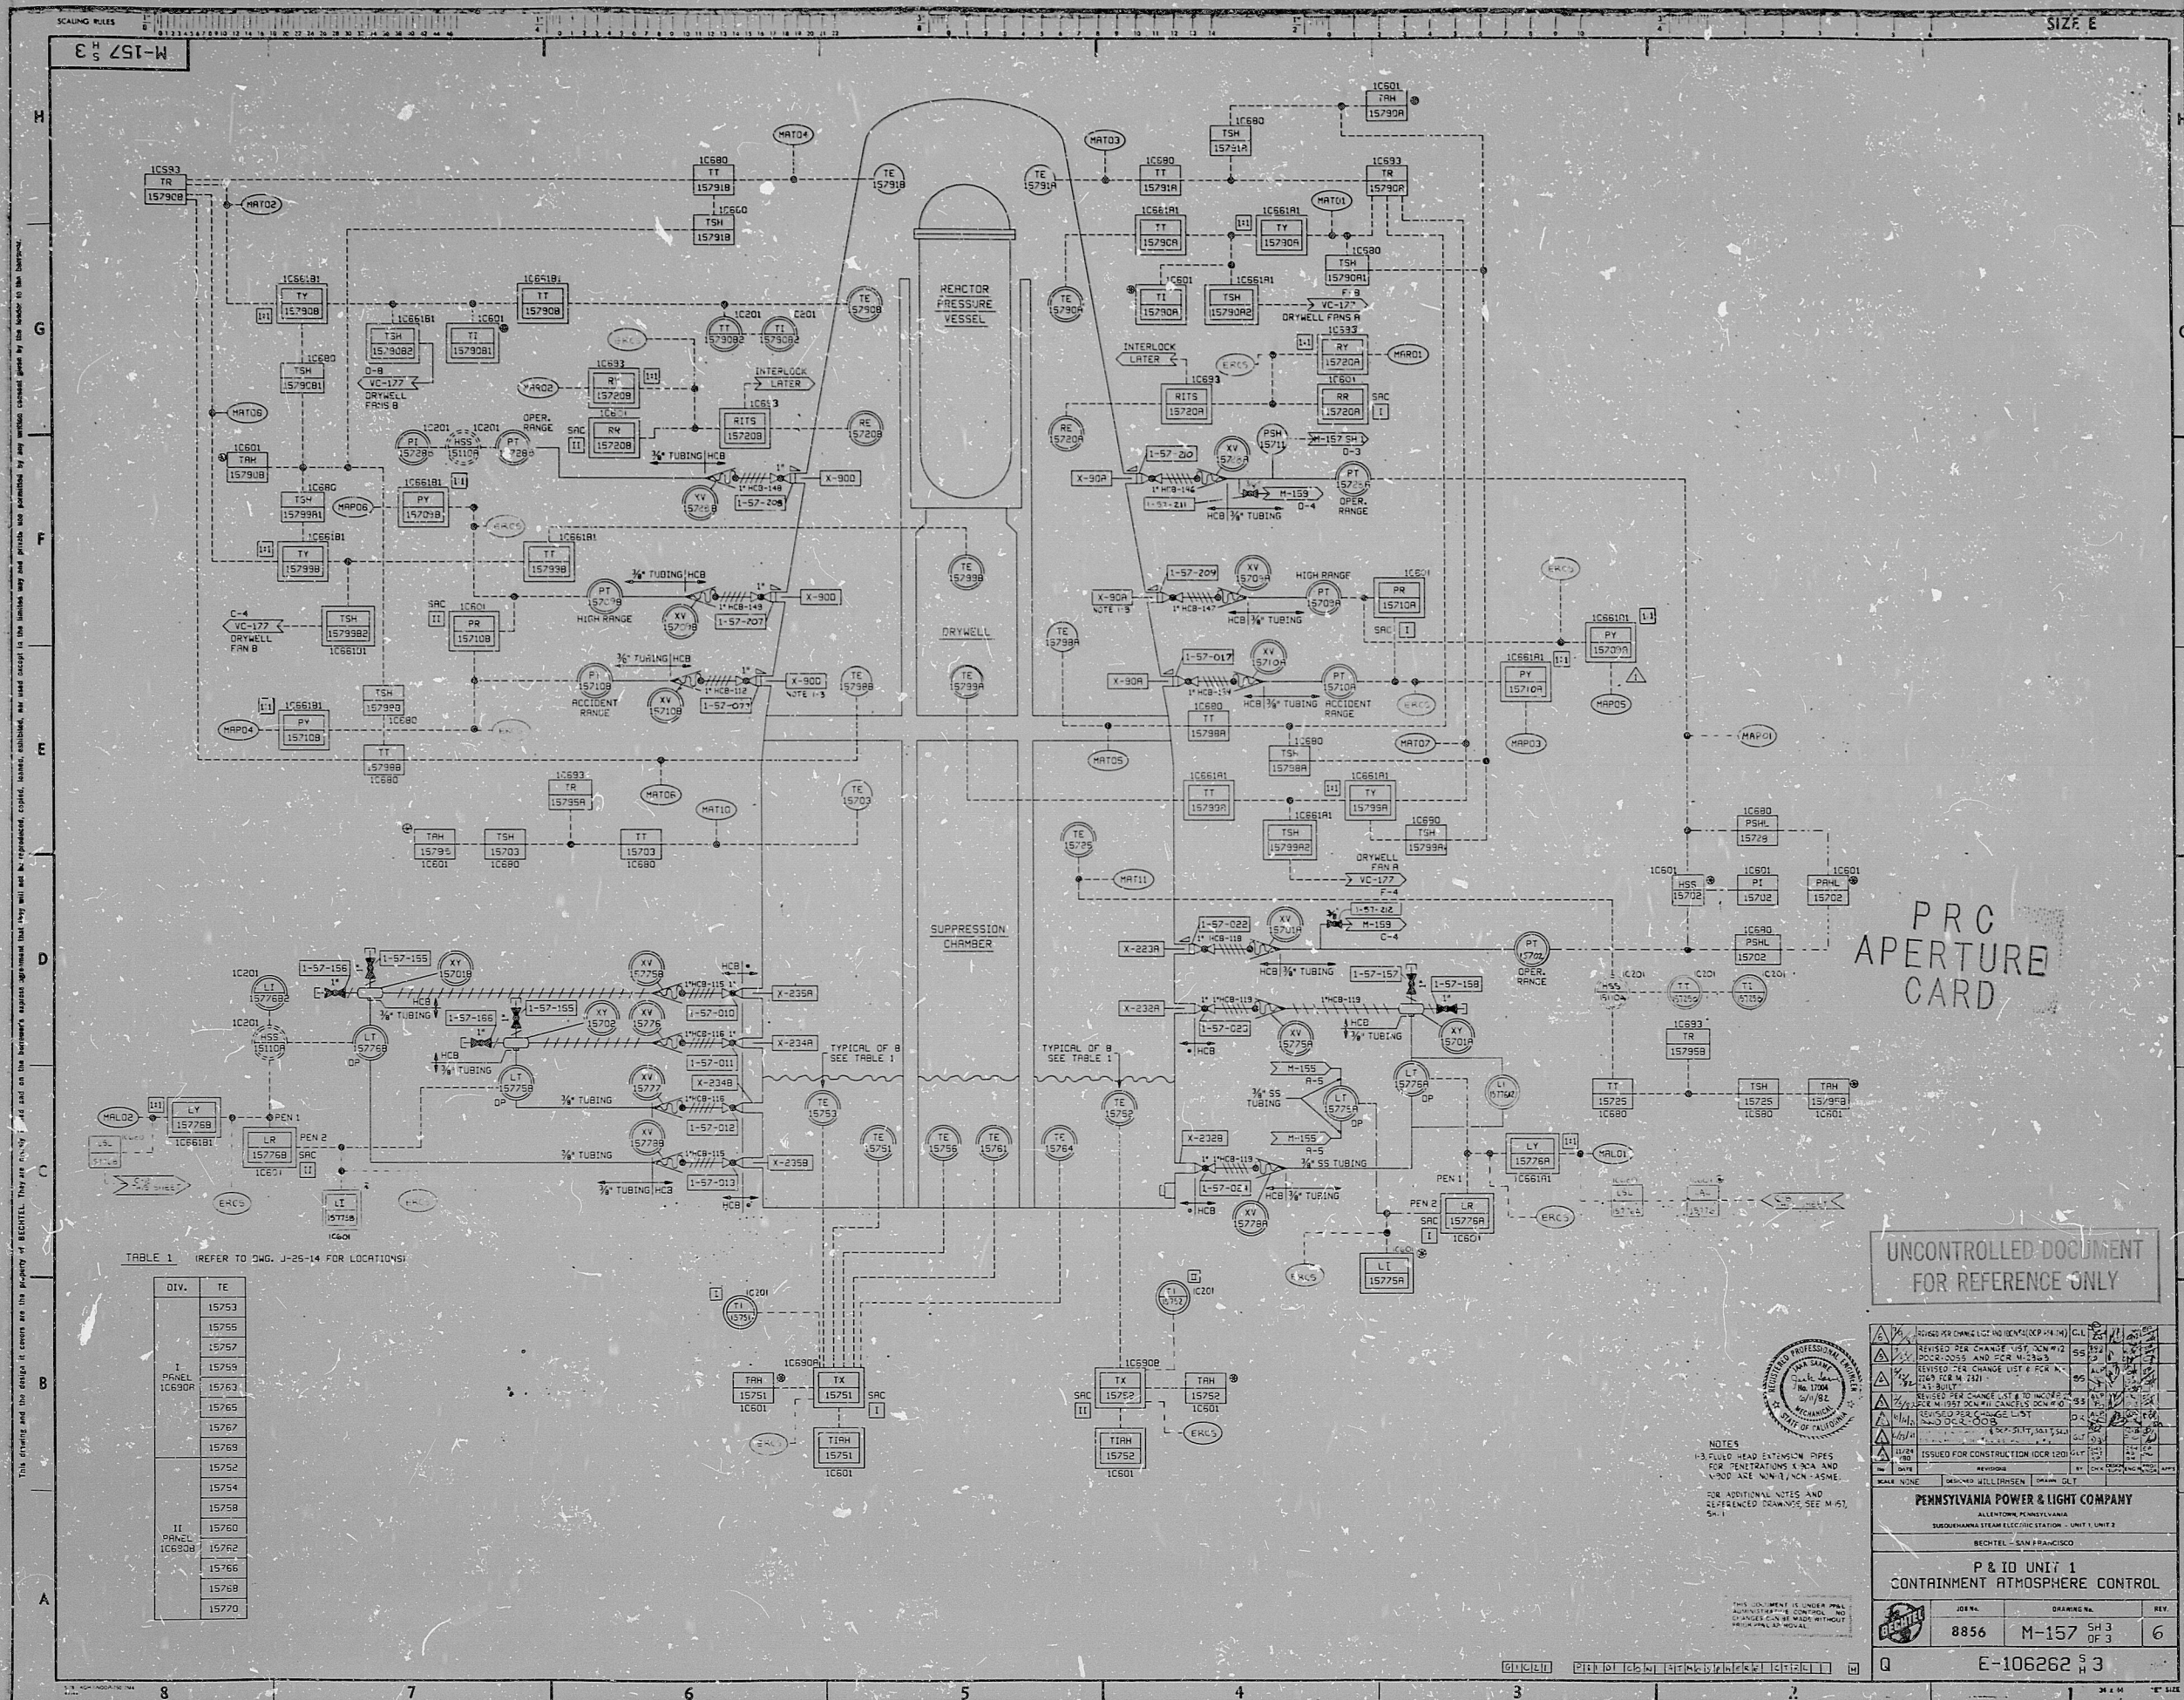


TABLE 1 REFER TO DWG. J-25-14 FOR LOCATIONS:

DIV.	TE
I	15753
I	15755
I	15757
I	15759
I	15763
I	15765
I	15767
I	15769
I	15772
I	15774
I	15778
II	15760
II	15762
II	15766
II	15768
II	15770

PRC APERTURE CARD

UNCONTROLLED DOCUMENT FOR REFERENCE ONLY

REVISION	DATE	BY	CHKD
1	10/1/82	J. J. ...	...
2	...	...	...
3	...	...	...
4	...	...	...
5	...	...	...
6	...	...	...
7	...	...	...
8	...	...	...
9	...	...	...
10	...	...	...

PENNSYLVANIA POWER & LIGHT COMPANY  
ALLENTOWN, PENNSYLVANIA  
SUBOHAMA STEAM ELECTRIC STATION - UNIT 1, UNIT 2  
BECHTEL - SAN FRANCISCO

P & ID UNIT 1  
CONTAINMENT ATMOSPHERE CONTROL

JOB NO.	DRAWING NO.	REV.
8856	M-157	5H 3 OF 3
E-106262		3



NOTES:  
1. FLUID HEAD EXHIBITION PIPES FOR THERMISTORS, SCA AND VAPOR ARE NOT TO BE INSTALLED.  
2. FOR ADDITIONAL NOTES AND REVISIONS SEE M-157, 5H 1.

3 0 X



**RIDS**

8305250379

