


SECTION A-A
(D-226-511)

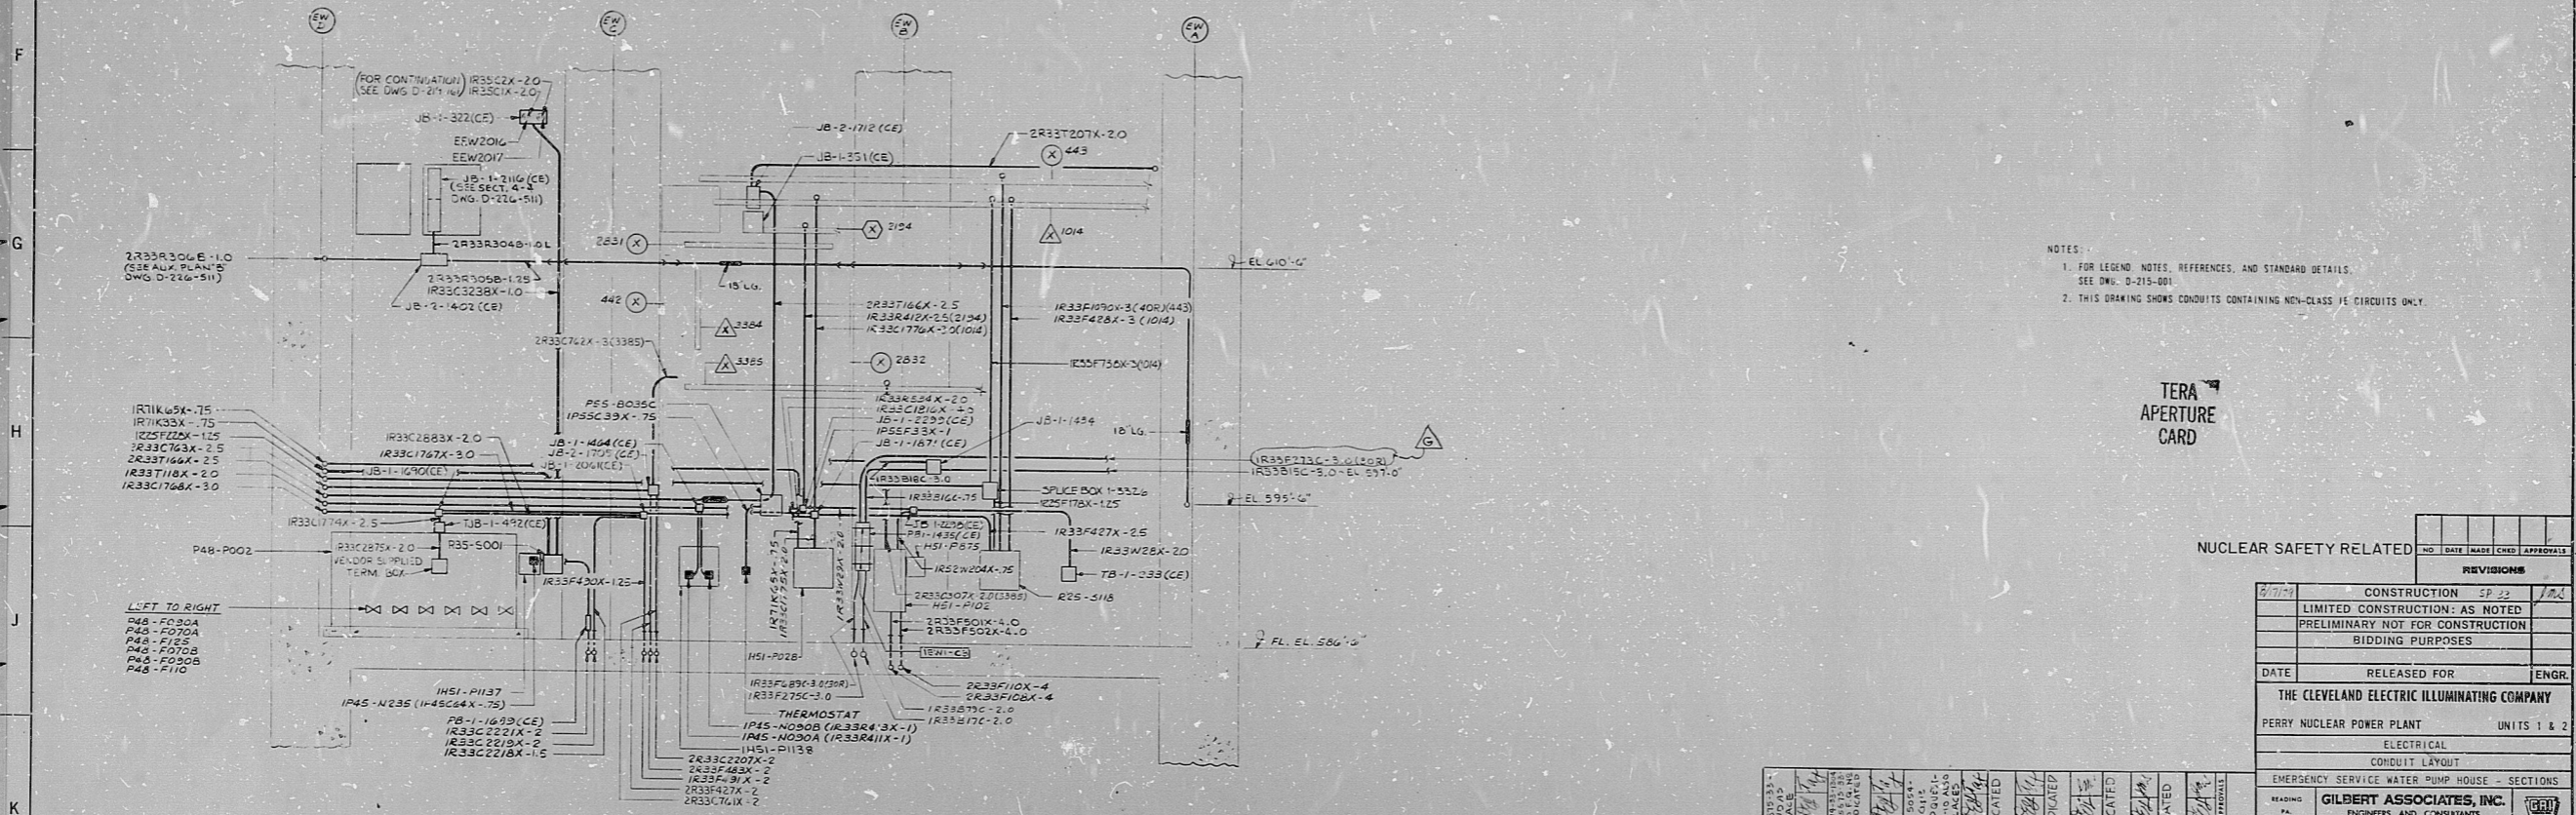

SECTION B-B
(D-226-511)

NOTES:
1. FOR LEGEND, NOTES, REFERENCES, AND STANDARD DETAILS, SEE DWG. D-215-001.
2. THIS DRAWING SHOWS CONDUITS CONTAINING NON-CLASS IFC CIRCUITS ONLY.

TERA
APERTURE
CARD

NUCLEAR SAFETY RELATED

REVISIONS	
NO.	DESCRIPTION
1	CONSTRUCTION
2	LIMITED CONSTRUCTION: AS NOTED
3	PRELIMINARY NOT FOR CONSTRUCTION
4	BIDDING PURPOSES

DATE	RELEASED FOR	ENGR.
	THE CLEVELAND ELECTRIC ILLUMINATING COMPANY	
PERRY NUCLEAR POWER PLANT		UNITS 1 & 2
ELECTRICAL		
CONDUIT LAYOUT		
EMERGENCY SERVICE WATER PUMP HOUSE - SECTIONS		
DESIGNED BY	GILBERT ASSOCIATES, INC.	
CHECKED BY	ENGINEERS AND CONSULTANTS	
DATE	1/8/51	04 4549 D-226-512 G
SCALE	1/8"=1'-0"	DRAWING NUMBER
PROJECT NO.	04549-000	REV

NO.	DESCRIPTION	DATE	BY	CHKD.
1	ISSUED FOR CONSTRUCTION	1/8/51	J. W. GILBERT	J. W. GILBERT
2	REVISIONS			
3				
4				
5				
6				
7				
8				
9				
10				
11				
12				
13				
14				
15				
16				
17				
18				
19				
20				

R:DS

8112040218

