


14 13 12 11 10 9 8 7 6 5 4 3 2 1

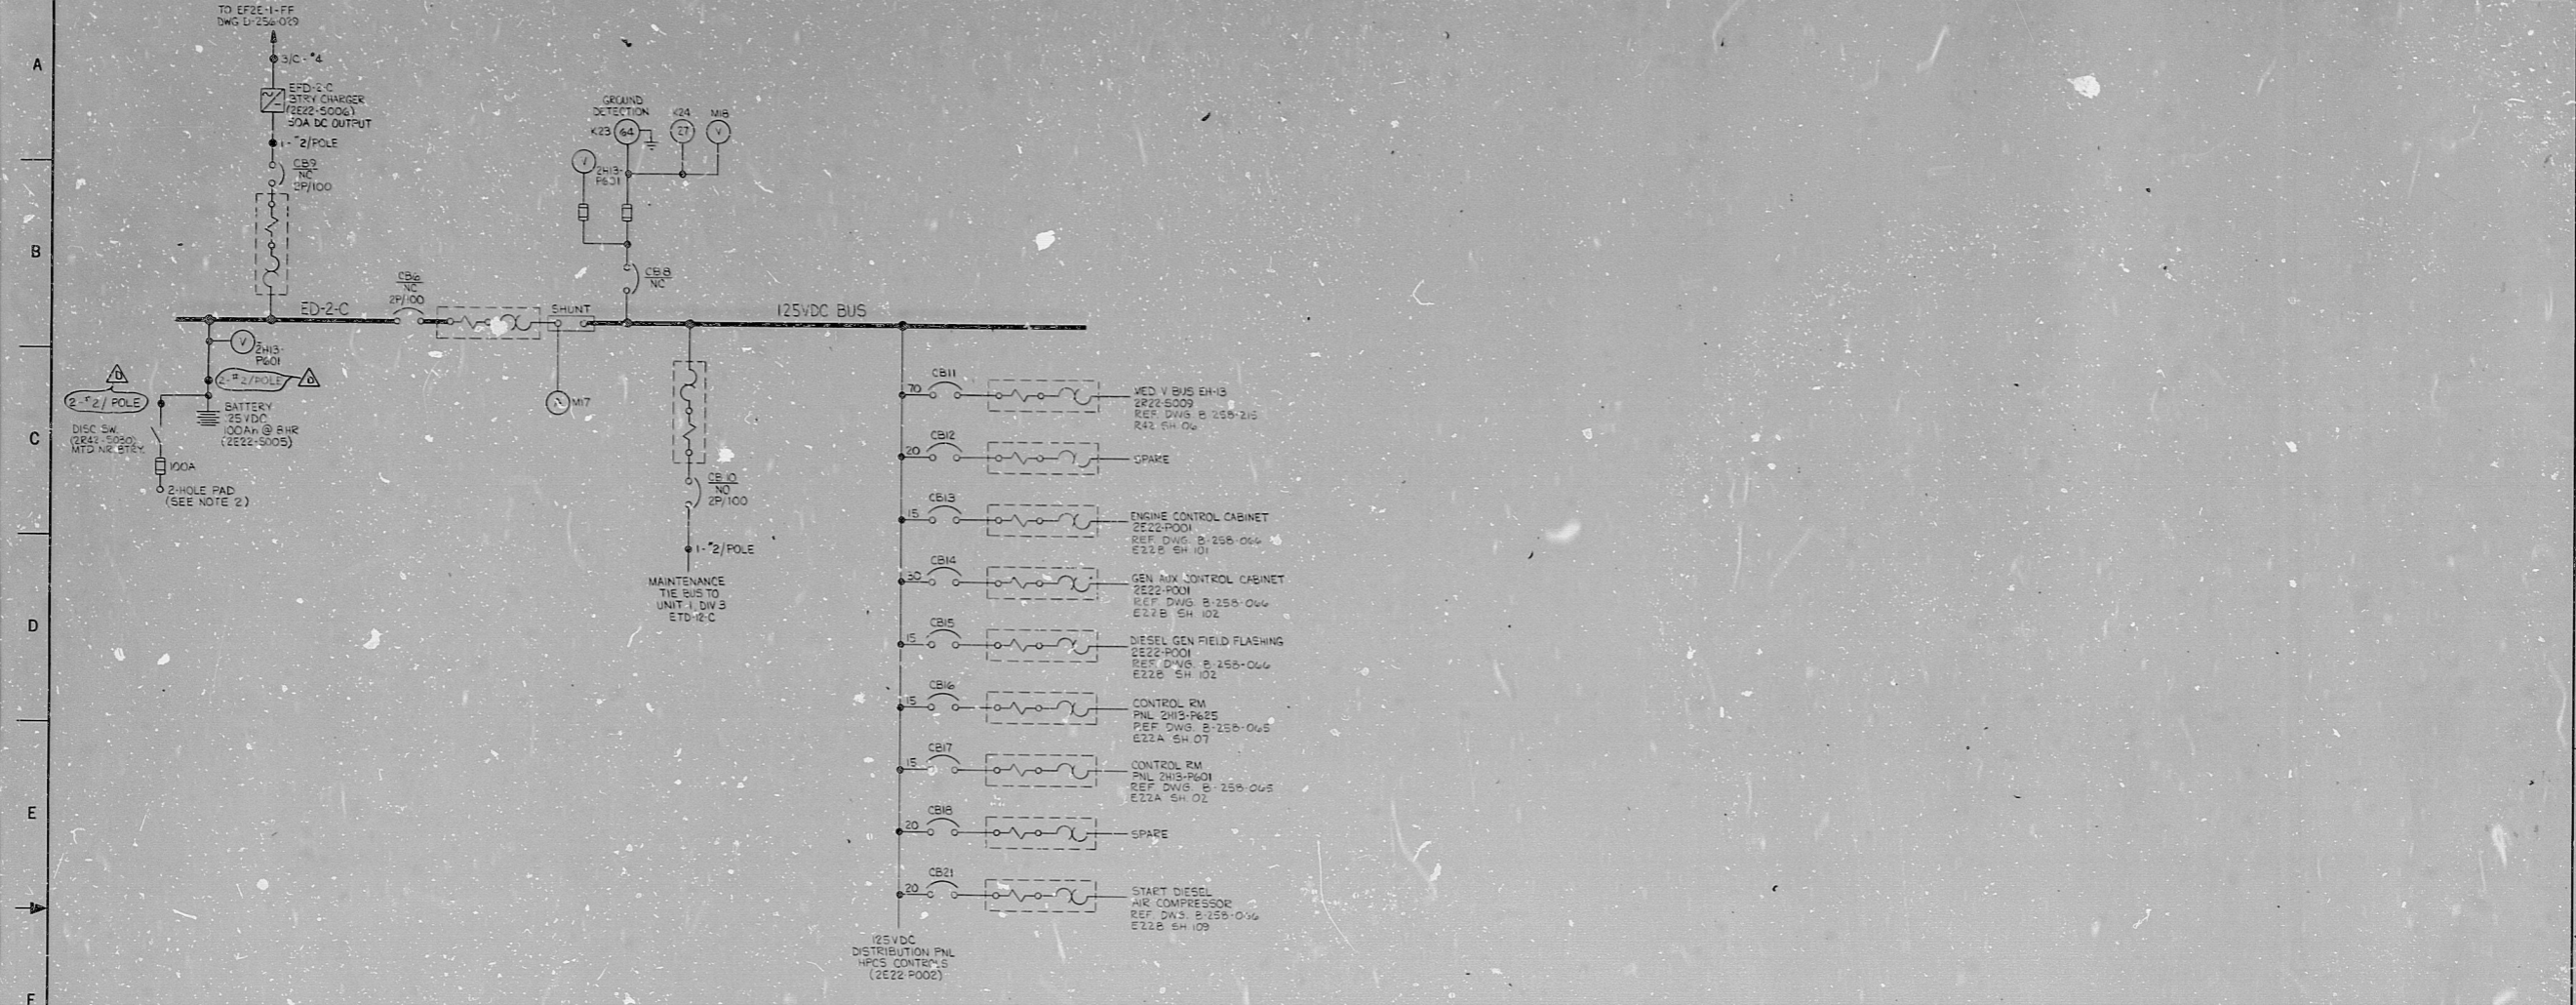

NOTES:
 1. FOR LEGEND AND ABBREVIATIONS, SEE DWG. D-256-012.
 2. REQUIRED FOR CONNECTION OF 500MCM CABLE FROM PORTABLE BATTERY CAPACITY TEST RIG.

TERA APERTURE CARD

NUCLEAR SAFETY RELATED


REFERENCES:
 D-BISB 2271KE STEWART STEVENSON SERVICES

REV. A	CLIENT APPROVAL	D.R. GREEN	8-9-78
REV. D	DESIGN REVIEW COMPLETE	J.D. AREVALO	3-9-81

REVISIONS	
NO.	DATE MADE CHNGD APPROVALS
1	CONSTRUCTION
2	LIMITED CONSTRUCTION: AS NOTED
3	PRELIMINARY NOT FOR CONSTRUCTION BIDDING PURPOSES
4	RELEASED FOR ENGR.

DATE: _____
 THE CLEVELAND ELECTRIC ILLUMINATING COMPANY
 PERRY NUCLEAR POWER PLANT - UNIT 2
 ELECTRICAL
 ONE LINE DIAGRAM
 CLASS 1E DC SYSTEM - DIV. 3
GILBERT ASSOCIATES, INC.
 ENGINEERS AND CONSULTANTS

REVISIONS	DATE	BY	APPROVED
1	8-9-78	D.R. GREEN	
2	3-9-81	J.D. AREVALO	

 

D N E L I N E D I A G R A M C L A S S 1 E D C S Y S T E M - D I V . 3
 04 4549 D-256-050
 044549-000 DRAWING NUMBER REV

RIDS

8/12040223

