

66

68

22

22

41

41

11

11

59

59

0.5"

0.5"

11"

11"

17"


17"

22"

22"

34"

34"

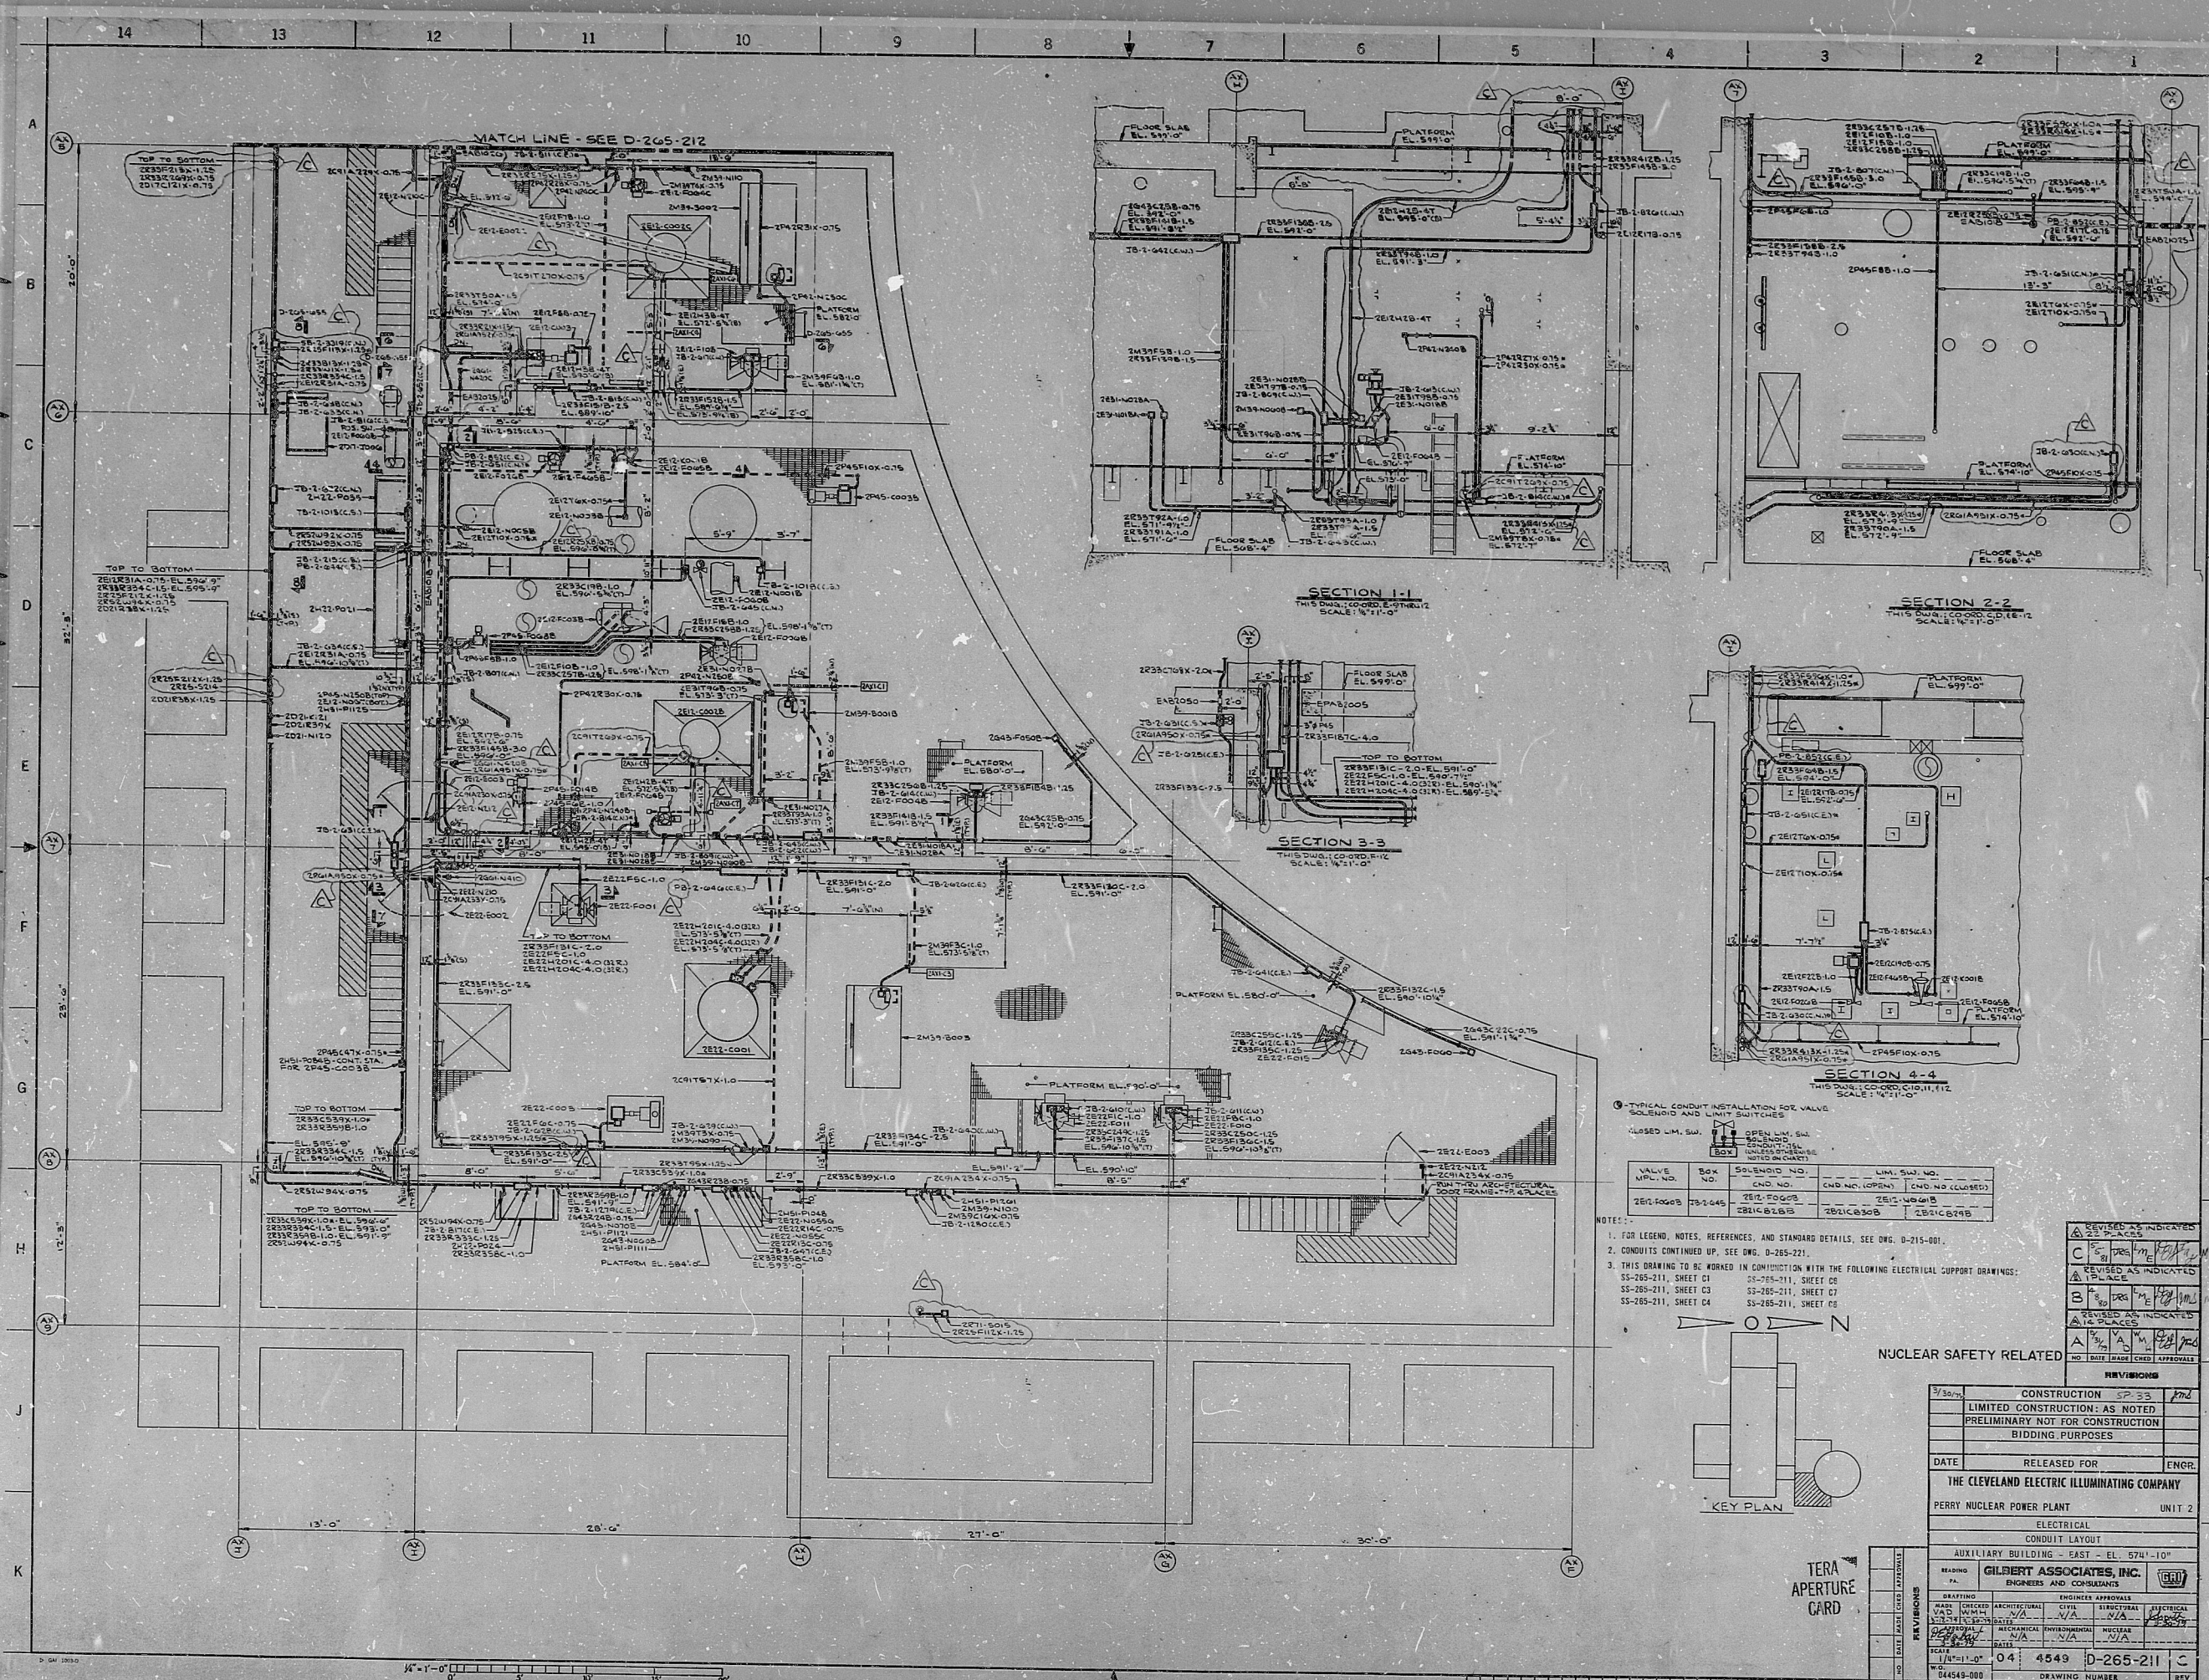

NOTES:

- FOR LEGEND, NOTES, REFERENCES, AND STANDARD DETAILS, SEE DWG. D-215-001.
- CONDUITS CONTINUED UP, SEE DWG. D-215-001.
- THIS DRAWING IS TO BE WORKED IN CONJUNCTION WITH THE FOLLOWING ELECTRICAL SUPPORT DRAWINGS:
SS-205-211, SHEET C1
SS-205-211, SHEET C2
SS-205-211, SHEET C3
SS-205-211, SHEET C4

REVISIONS

NO.	DATE	BY	CHKD.	DESCRIPTION
1				
2				
3				
100				

NUCLEAR SAFETY RELATED

REVISIONS

NO.	DATE	BY	CHKD.	DESCRIPTION
1				
2				
3				
100				

CONSTRUCTION

LIMITED CONSTRUCTION: AS NOTED

PRELIMINARY NOT FOR CONSTRUCTION

BIDDING PURPOSES

DATE

RELEASED FOR

ENGR.

THE CLEVELAND ELECTRIC ILLUMINATING COMPANY

PERRY NUCLEAR POWER PLANT

UNIT 2

ELECTRICAL

CONDUIT LAYOUT

AUXILIARY BUILDING - EAST - EL. 574'-10"

READING

GILBERT ASSOCIATES, INC.

ENGINEERS AND CONSULTANTS

REVISIONS

NO.	DATE	BY	CHKD.	DESCRIPTION
1				
2				
3				
100				

SCALE

1/8"=1'-0"

04 4549 D-265-211 C

DRAWING NUMBER

REV

RIDS

8112940267

