

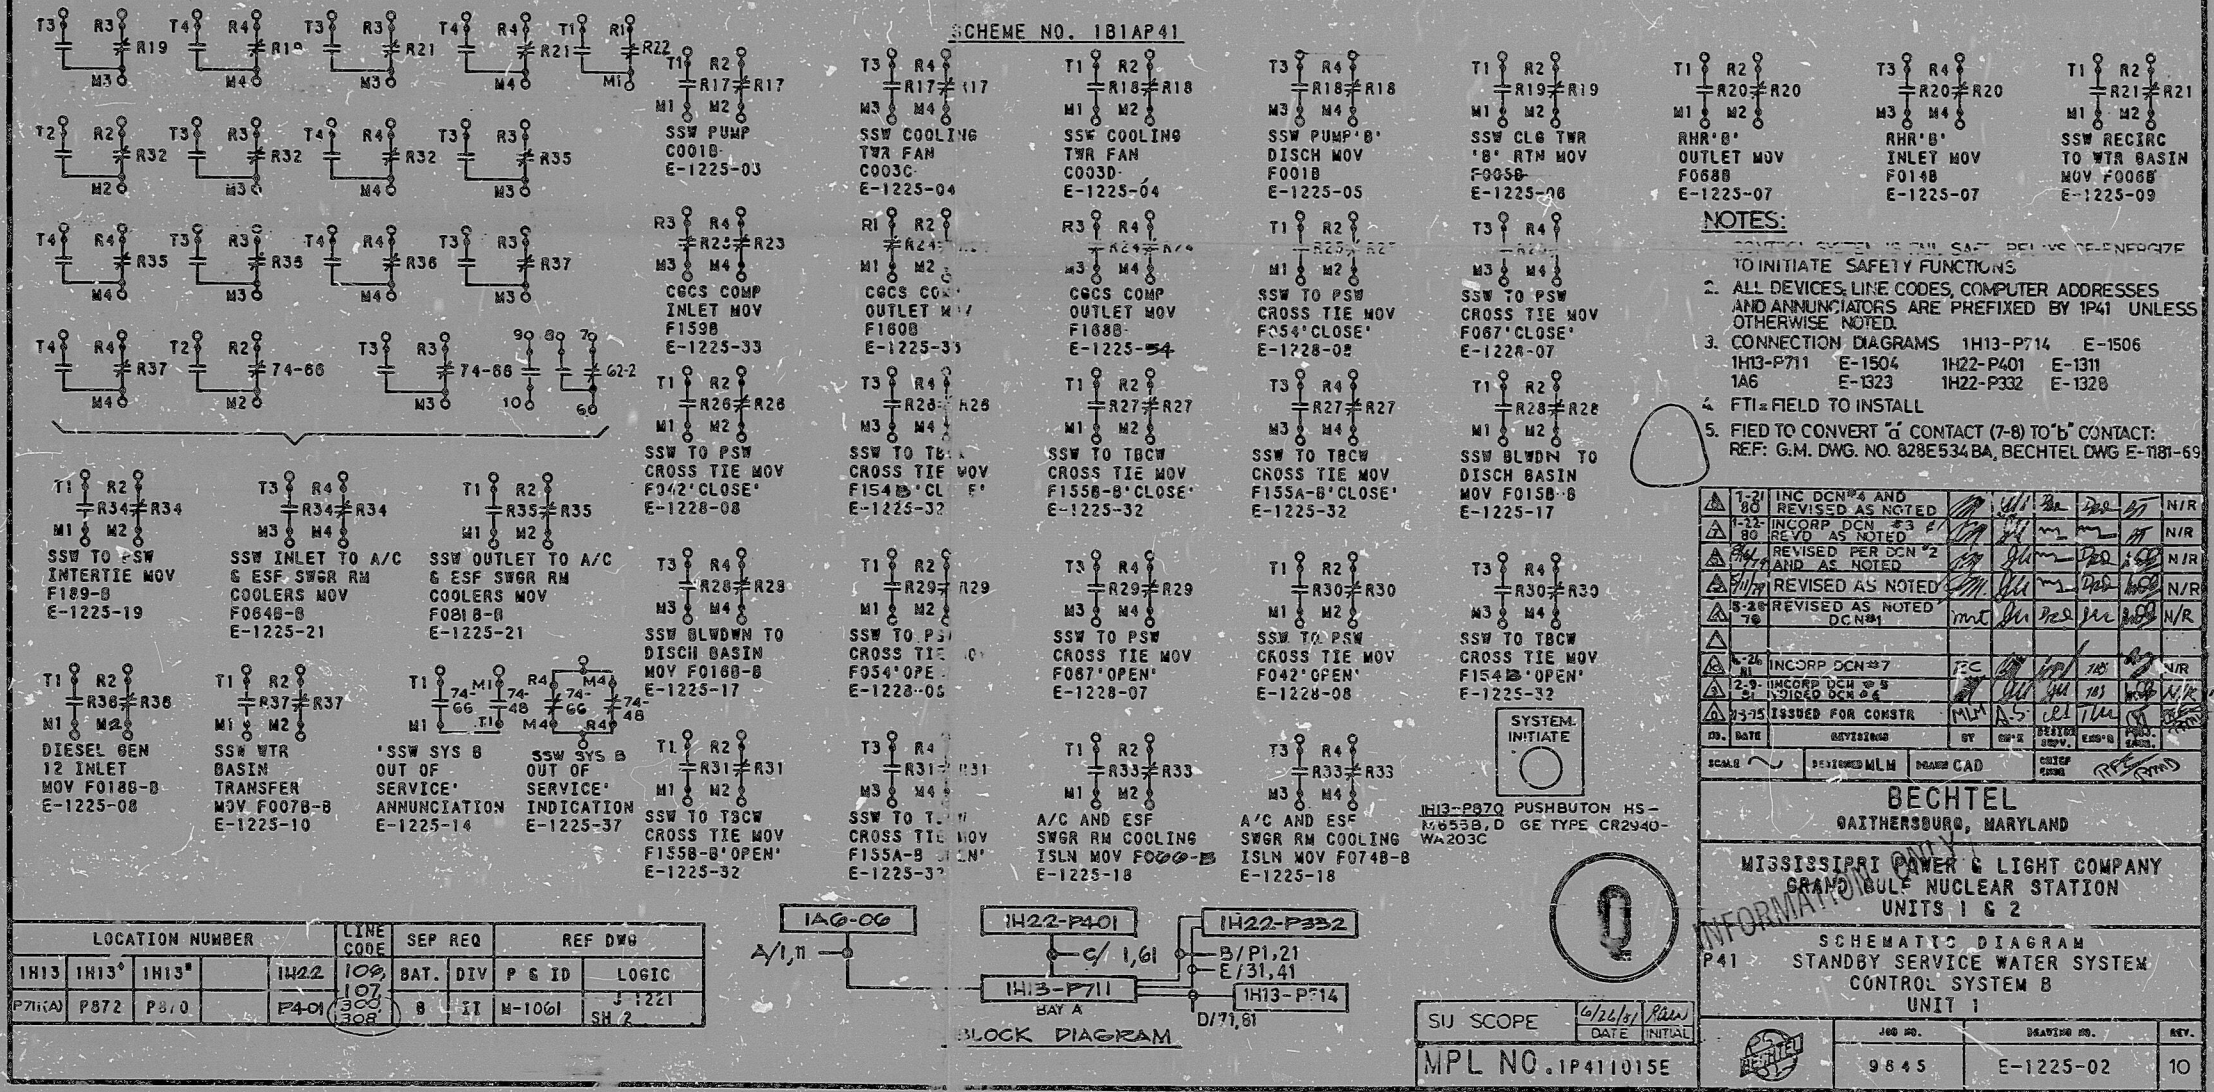


This drawing and the design it covers are the property of BECHTEL. They are hereby loaned and on the borrower's express agreement that they will not be reproduced, copied, loaned, exhibited, or used except in the limited way and private use permitted by the lender to the borrower.

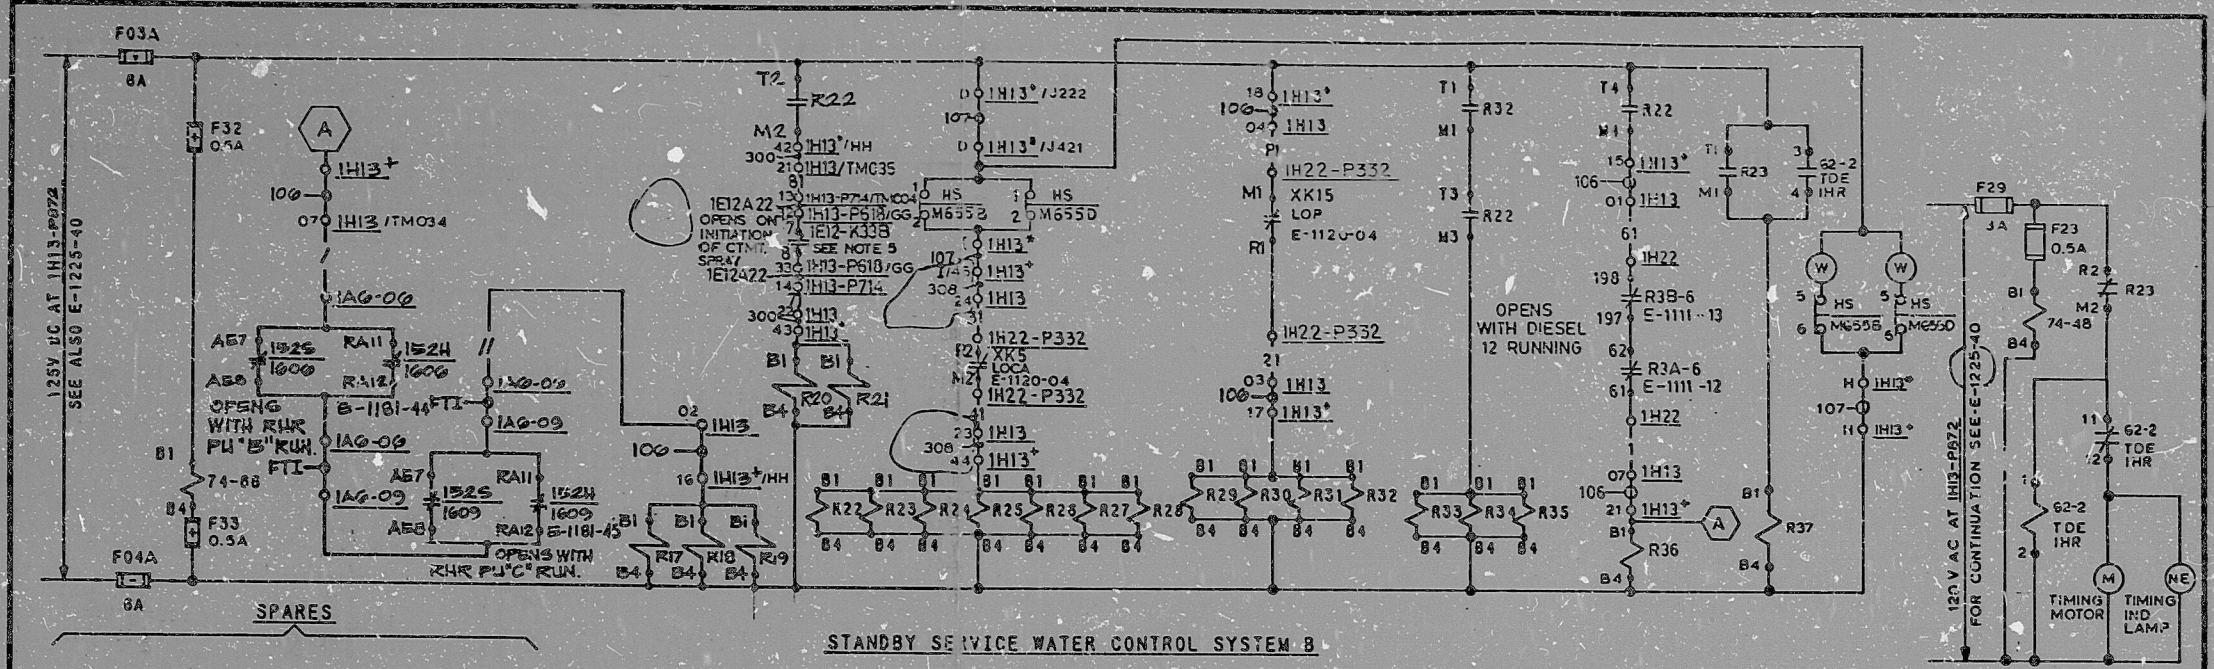

LOCATION NUMBER	LINE CODE	SEP REQ	REF DWG
IH13 IH13* IH13*	IH22	BAT. DIV	P & ID LOGIC
P714(A) P872 P810	P401	8 IT	M-1061 J-1221 SH 2

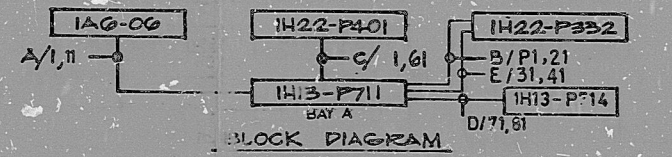

SU SCOPE
DATE 9/21/81
INITIAL

MPL NO. 1P411015E

JOB NO. 9845
DRAWING NO. E-1225-02
REV. 10

I certify that the image contained on this frame was made in the normal and regular course of business, on the date stated below and that it is an accurate reproduction of the document(s) submitted to Micrographics.
DATE 7-15-81 OPERATOR *Jelly Bueh* SUPERVISOR *[Signature]*

16X

8307180366

APERTURE CARD

11

11
9.9

8.5"

11"

17"

64

64

8.5

11

17

RIDS

8307180366

