


MPL No. 1121 9025C
C-1074D

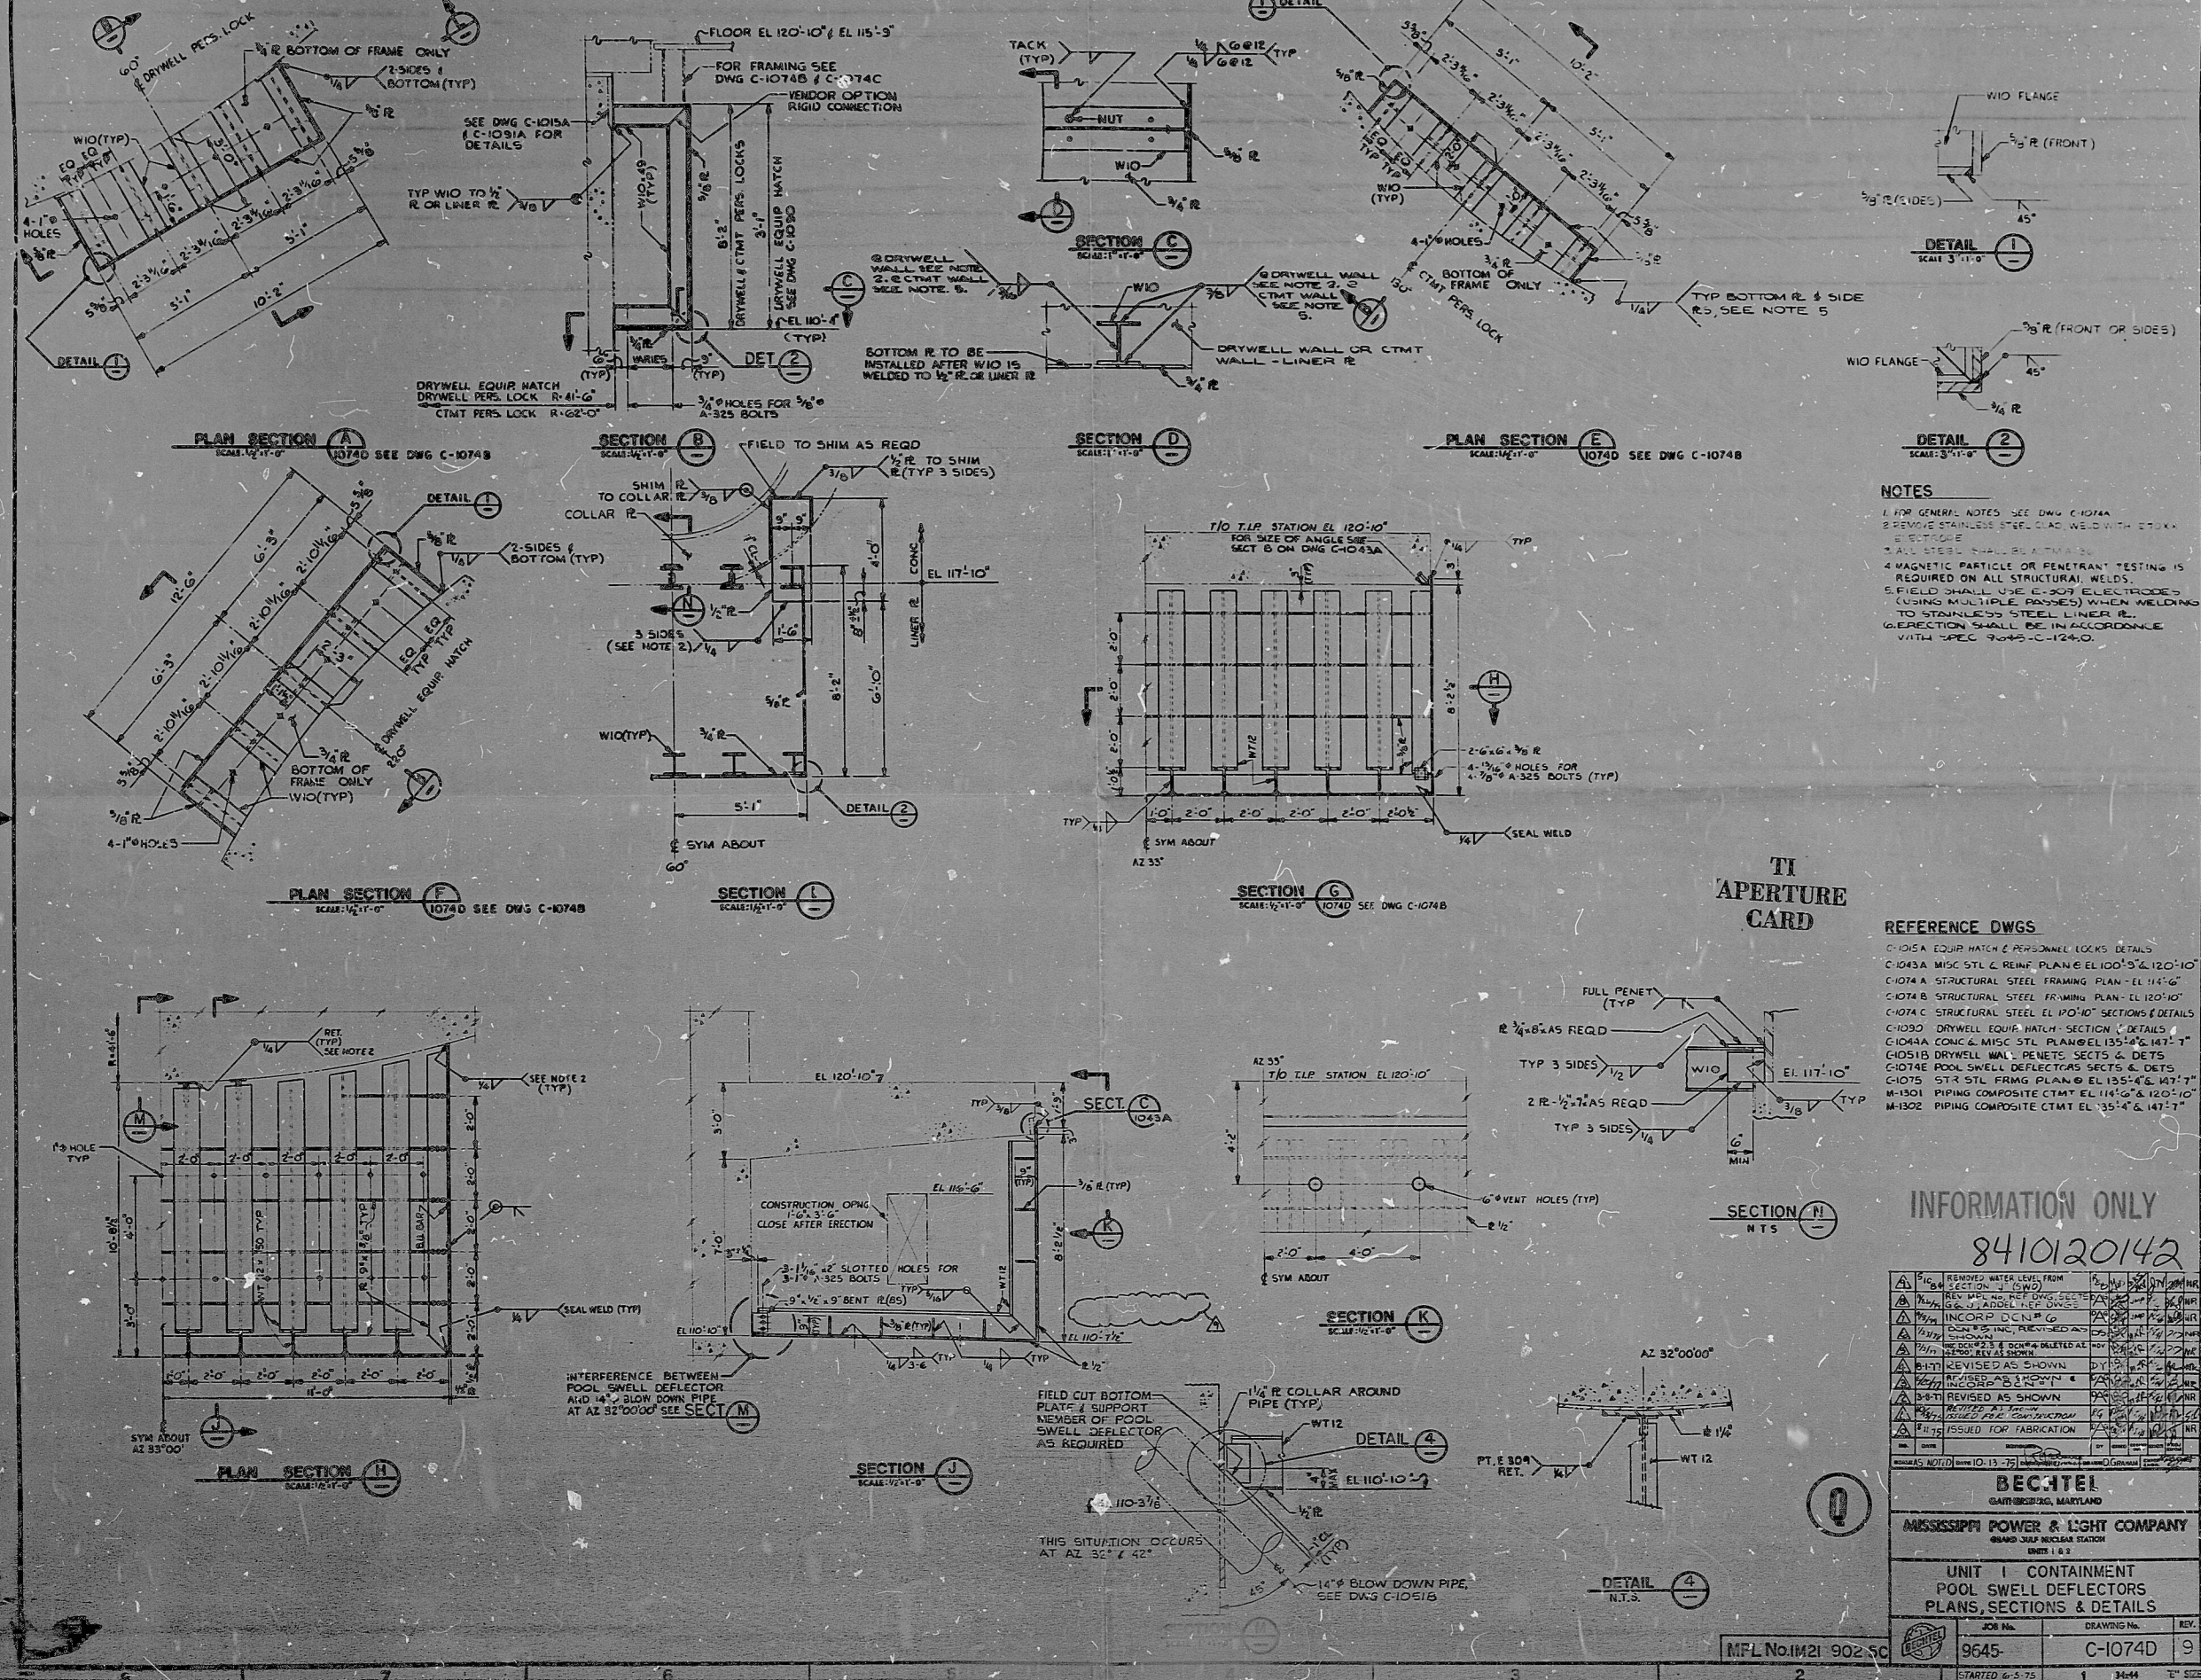

- NOTES**
- FOR GENERAL NOTES SEE DWG C-1074A
 - REMOVE STAINLESS STEEL WELD WITH STAINLESS STEEL
 - ALL STEEL SHALL BE A307
 - MAGNETIC PARTICLE OR PENETRANT TESTING IS REQUIRED ON ALL STRUCTURAL WELDS
 - FIELD SHALL USE E-307 ELECTRODES (USING MULTIPLE PASSES) WHEN WELDING TO STAINLESS STEEL LINER R.
 - SECTION SHALL BE IN ACCORDANCE WITH SPEC 9-4.5 C-124.0.

TI APERTURE CARD

- REFERENCE DWGS**
- C-1015A EQUIP HATCH & PERSONNEL LOCKS DETAILS
 - C-1043A MISC STL & REINF. PLAN @ EL 100'-5" & 120'-10"
 - C-1074A STRUCTURAL STEEL FRAMING PLAN - EL 114'-6"
 - C-1074B STRUCTURAL STEEL FRAMING PLAN - EL 120'-10"
 - C-1074C STRUCTURAL STEEL @ EL 100'-10" SECTIONS & DETAILS
 - C-1030 DRYWELL EQUIP HATCH - SECTION C, DETAILS
 - C-1044A CONC & MISC STL PLAN @ EL 135'-4" & 147'-7"
 - C-1015B DRYWELL WALL PENETS, SECTS & DETS
 - C-1074E POOL SWELL DEFLECTORS SECTS & DETS
 - C-1075 STR STL FRAMING PLAN @ EL 135'-4" & 147'-7"
 - M-1501 PIPING COMPOSITE CTMT @ EL 114'-6" & 120'-10"
 - M-1502 PIPING COMPOSITE CTMT @ EL 135'-4" & 147'-7"

INFORMATION ONLY

8410120142

NO.	DESCRIPTION	DATE	BY	CHKD
1	ISSUED FOR FABRICATION	10/15/75	J. J. [unclear]	[unclear]
2	REVISION AS SHOWN	10/15/75	[unclear]	[unclear]
3	REVISION AS SHOWN	10/15/75	[unclear]	[unclear]
4	REVISION AS SHOWN	10/15/75	[unclear]	[unclear]
5	REVISION AS SHOWN	10/15/75	[unclear]	[unclear]
6	REVISION AS SHOWN	10/15/75	[unclear]	[unclear]
7	REVISION AS SHOWN	10/15/75	[unclear]	[unclear]
8	REVISION AS SHOWN	10/15/75	[unclear]	[unclear]
9	REVISION AS SHOWN	10/15/75	[unclear]	[unclear]
10	REVISION AS SHOWN	10/15/75	[unclear]	[unclear]
11	REVISION AS SHOWN	10/15/75	[unclear]	[unclear]
12	REVISION AS SHOWN	10/15/75	[unclear]	[unclear]
13	REVISION AS SHOWN	10/15/75	[unclear]	[unclear]
14	REVISION AS SHOWN	10/15/75	[unclear]	[unclear]
15	REVISION AS SHOWN	10/15/75	[unclear]	[unclear]
16	REVISION AS SHOWN	10/15/75	[unclear]	[unclear]
17	REVISION AS SHOWN	10/15/75	[unclear]	[unclear]
18	REVISION AS SHOWN	10/15/75	[unclear]	[unclear]
19	REVISION AS SHOWN	10/15/75	[unclear]	[unclear]
20	REVISION AS SHOWN	10/15/75	[unclear]	[unclear]

BECHTEL
GAITHERSBURG, MARYLAND

MISSISSIPPI POWER & LIGHT COMPANY
GRAND JUMP NUCLEAR STATION
UNIT 1

UNIT 1 CONTAINMENT POOL SWELL DEFLECTORS PLANS, SECTIONS & DETAILS

JOB No. 9645 DRAWING No. C-1074D REV. 9

STARTED 6-5-75 1 3444 1" SIZE

All drawings and the design of any part of the structure are the property of BECHTEL. They are hereby loaned and are not to be reproduced, copied, loaned, exhibited, or used except in the limited way and for the limited purpose intended by the loaner. In the event of any unauthorized use, the loaner shall be held responsible for any and all consequences.

PDR RIDS

8410120142

