
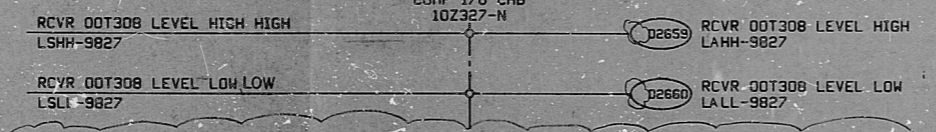
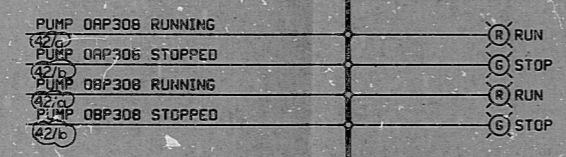
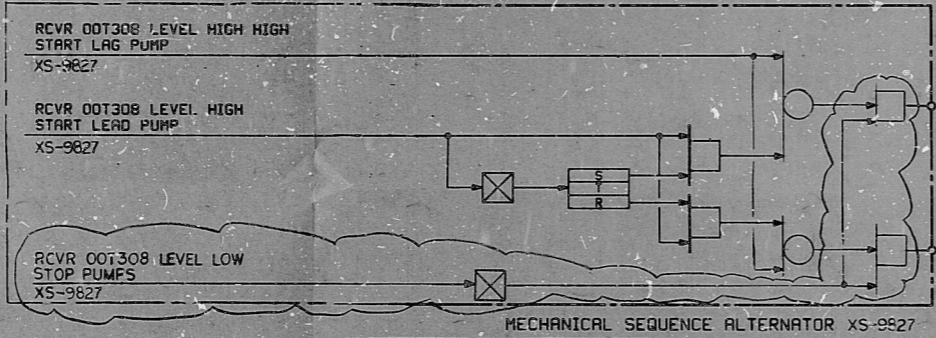


H-96-0

VENDOR FURNISHED PANEL AT UNIT RCP 00C387

REFERENCES

1	P & ID - PLANT HEATING	M-96-0
2	DITS - PLANT STEAM HEATING SYSTEM	03.55
3	LOGIC DIAGRAM STANDARD SYMBOLS	J-00-0
4	DELETED	
5	VENDOR WIRING DIAGRAM (M/R 10855)	M606-37

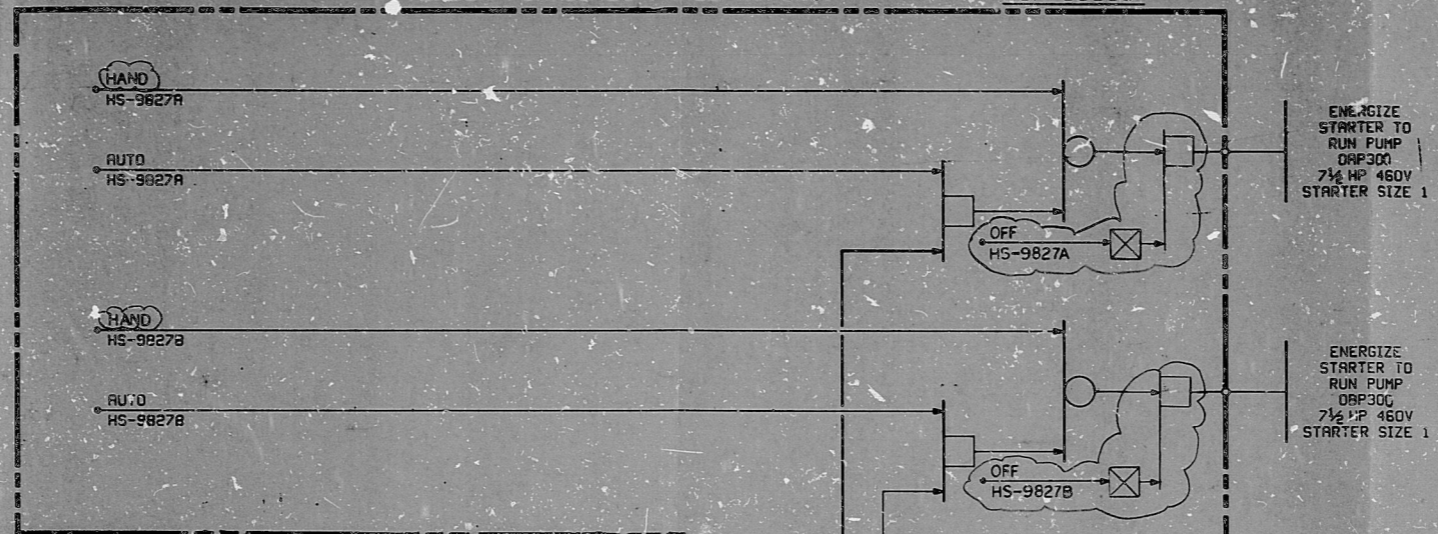


CONDENSATE RETURN UNIT 00T308

P.R.C. APERTURE CARD

NO.	DATE	REVISIONS	BY	CHKD	ISSUED	DRWN	APPD
1	11/12	REVISED AS NOTED, DELETE UMT 2, ISSUED FOR DESIGN FREEZE.					
2	11/11	REVISED AS NOTED					
3	11/11	DELETED DA/BP324 & 351					
4	11/11	ISSUED FOR CONSTRUCTION					

CROSS-REFERENCE TABLE

UNIT RECEIVER	PUMPS	HS-	LSHH-XS-LSLL	PUMP HP	PUMP PANEL	COMPUTER I/O CABINET	LEVEL HIGH COMP INPUT	LEVEL LOW COMP INPUT
00T308	OAP300	9827A	9827B	7 1/2	00C387	10Z327-N	D2659	D2660
00T301	OAP301	9828A	9828B	7 1/2	00C388	10Z327-N	D2661	D2662
10T114	1AP114	1-9825A	1-9825B	15	10C137	10Z327-N	D2657	D2658
10T186	1AP187	1-9803A	1-9803B	15	10C951	10Z327-N	D5740	D5741

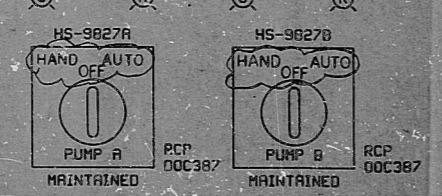

S/U-GA

BECHTEL
SAN FRANCISCO

PUBLIC SERVICE ELECTRIC AND GAS COMPANY
HOPE CREEK GENERATING STATION

LOGIC DIAGRAM
PLANT HEATING
CONDENSATE RETURN PUMPS

JOB No.	DRAWING No.	REV.
10855	H-96-0	3

This drawing and the design it covers are the property of BECHTEL. They are hereby loaned and used on the borrower's premises, expressed that they will not be reproduced, copied, loaned, exhibited, or used except in the limited way and under the conditions permitted by the borrower to the borrower.

RIDS

8307250277

