
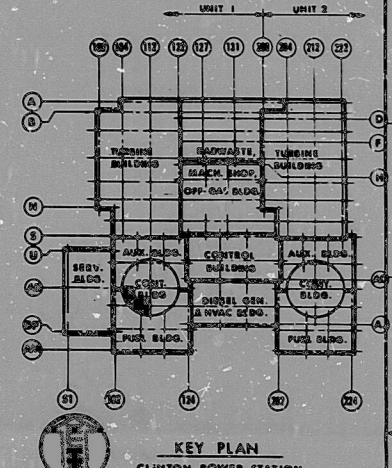


A27-1003-02A

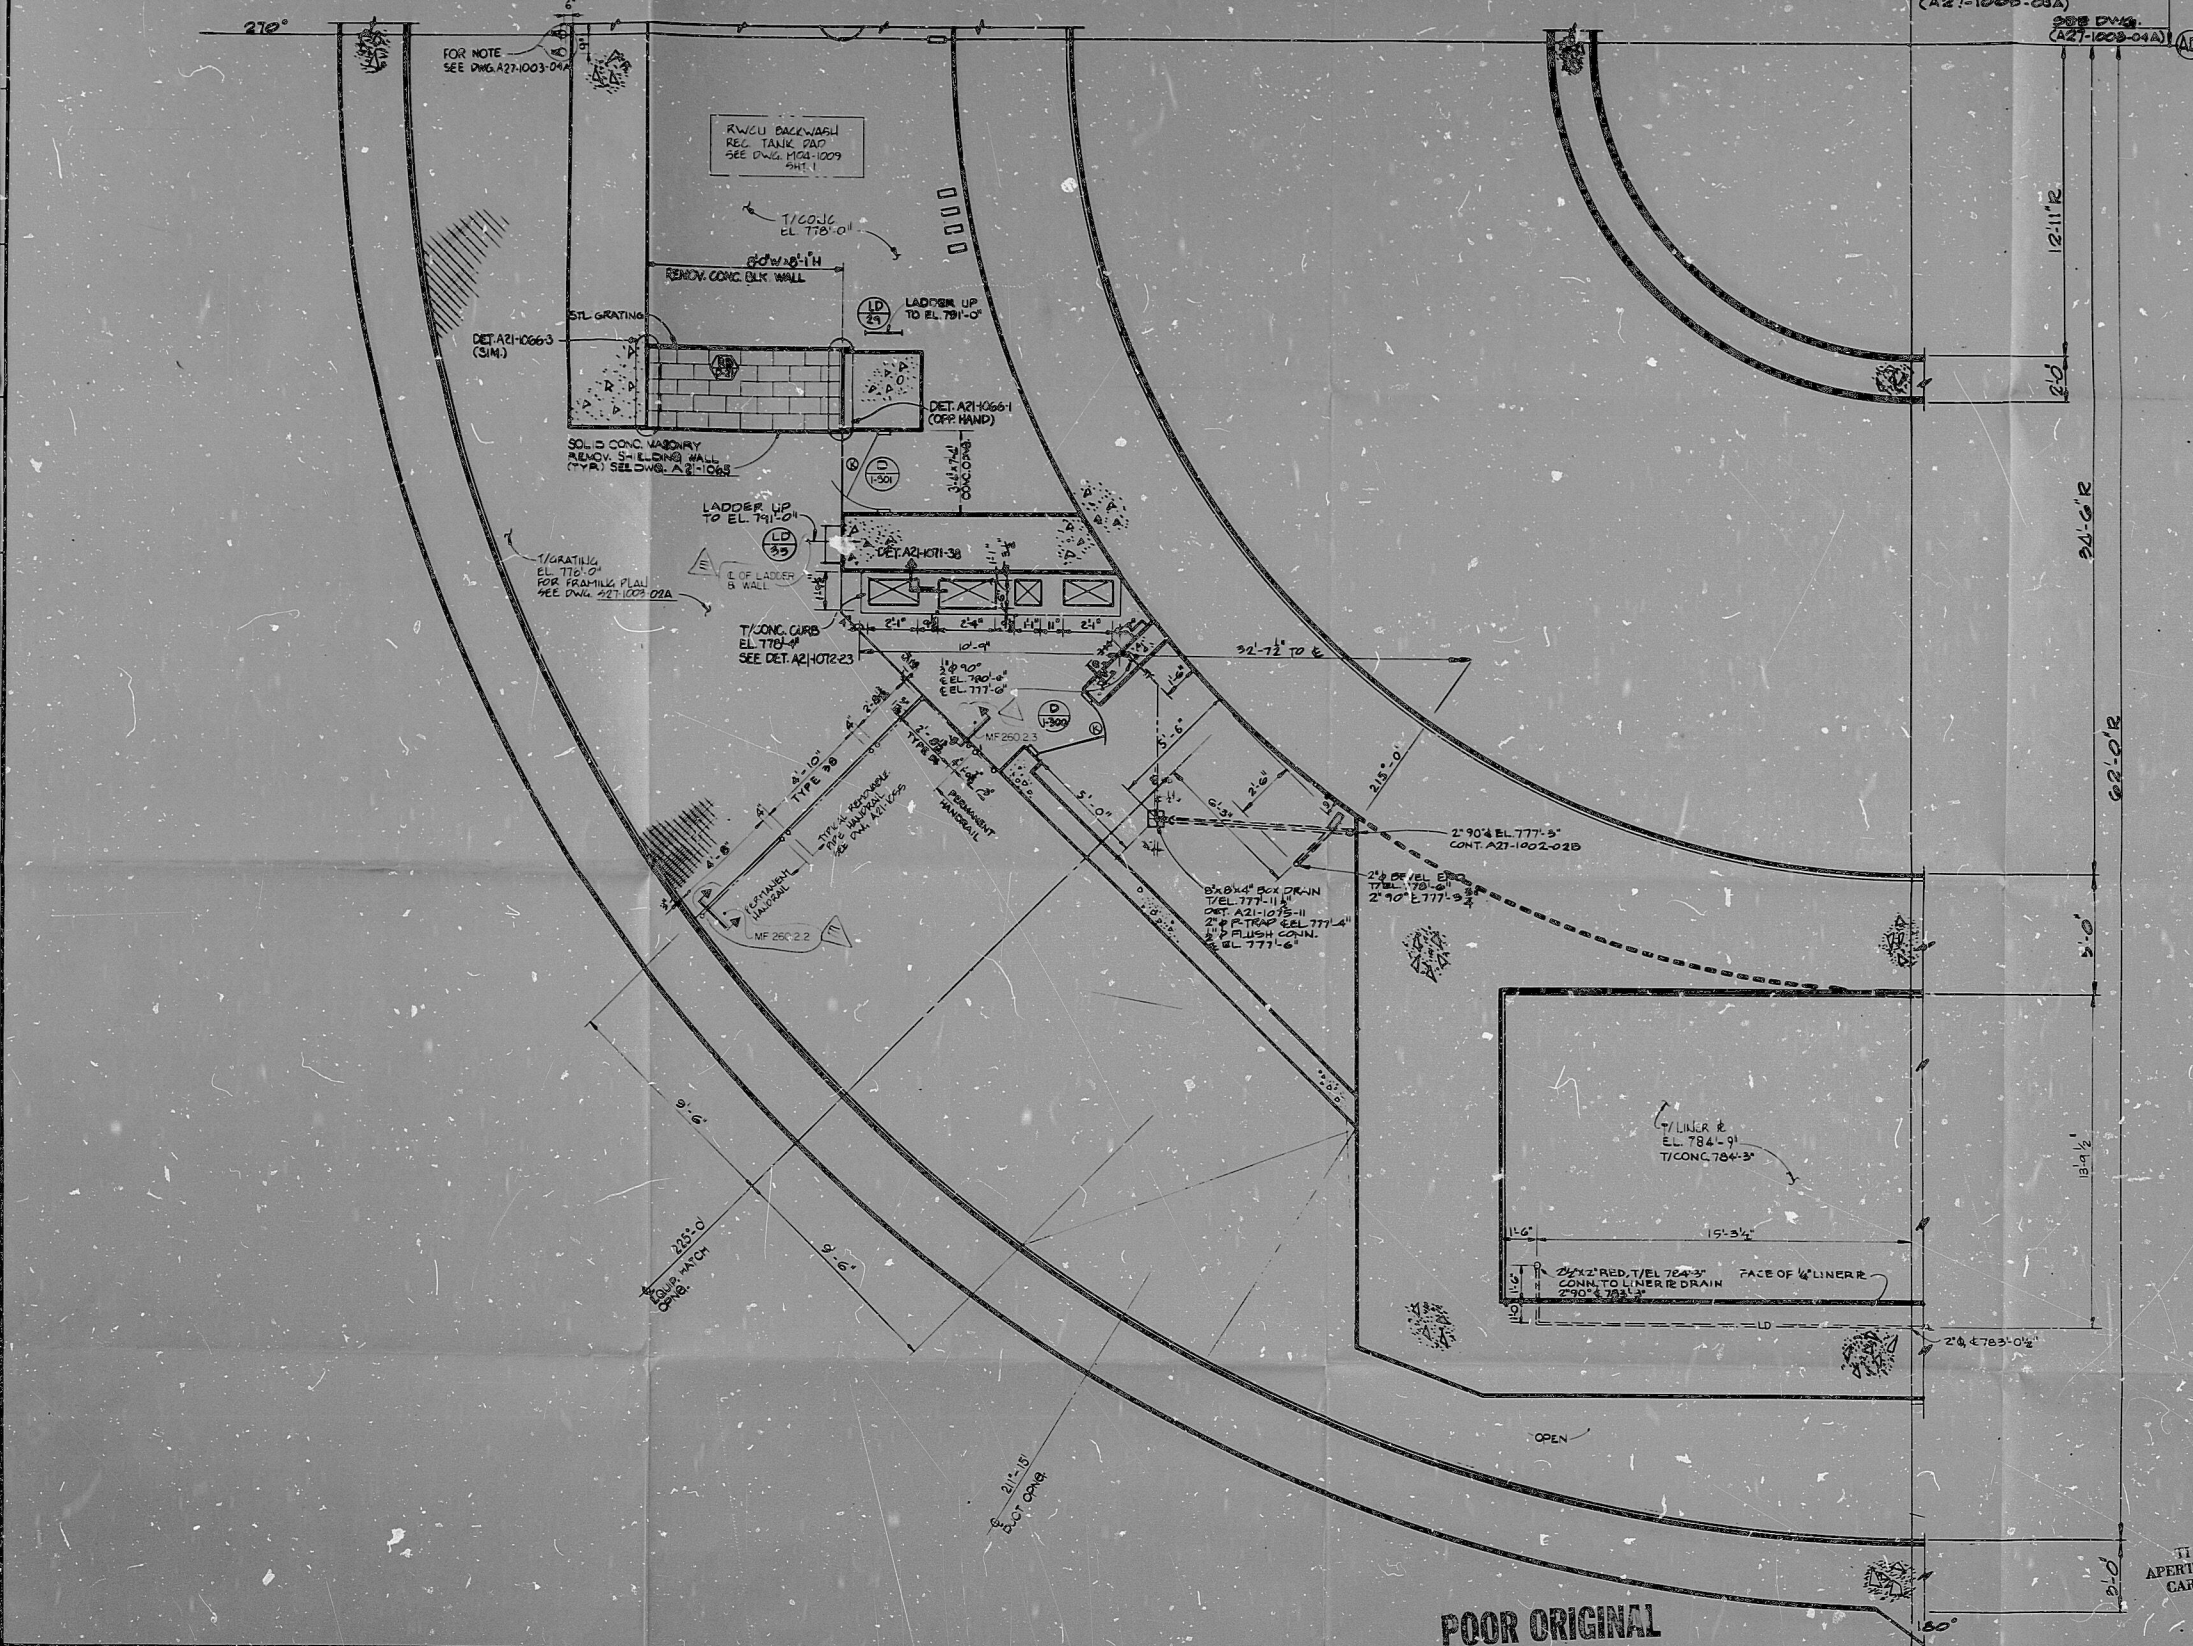

CATEGORY I AS NOTED

NOTES  
 1 FOR ARCHITECTURAL GENERAL NOTES SEE DWG. A21-1001  
 2 FOR LOCATION AND DIMENSIONS OF EQUIPMENT SEE DWG. 104-1004

REFERENCE DRAWINGS

A27-1003-02A	22-1003-02A	22-1003-02A
--------------	-------------	-------------

CHANGE DOCUMENTS

FOR	FOR	ECN	NCR	FECH

DRAWING RELEASE RECORD					DRAWING RELEASE RECORD										
REV.	SYSC. NO.	DATE	DRAWN	CHECKED	ENGINEER APPROVAL	DESCRIPTION	FILM	REV.	SYSC. NO.	DATE	DRAWN	CHECKED	ENGINEER APPROVAL	DESCRIPTION	FILM
A		4-27-79	A. Marshall	[Signature]	[Signature]	FOR CONSTR. SPEC. E-2000, R-2000, K-2000 & C-2000		B		5-23-79	A. Marshall	[Signature]	[Signature]	ADDED LADDER	
B		5-23-79	A. Marshall	[Signature]	[Signature]	ADDED LADDER		C		5-23-79	A. Marshall	[Signature]	[Signature]	REV. DIMENSION	
C		5-23-79	A. Marshall	[Signature]	[Signature]	ADDED LADDER		D		5-23-79	A. Marshall	[Signature]	[Signature]	ADDED LADDER	
D		5-23-79	A. Marshall	[Signature]	[Signature]	ADDED LADDER		E		5-23-79	A. Marshall	[Signature]	[Signature]	ADDED LADDER	
E		5-23-79	A. Marshall	[Signature]	[Signature]	ADDED LADDER									

PROJECT NUMBER: 8410310484  
 SCALE: 1/8" = 1'-0"  
 DATE: 4-20-79  
 DRAWN: [Signature]  
 CHECKED: [Signature]  
 APPROVED: [Signature]

8410310484  
 CONTAINMENT BUILDING  
 FLOOR PLAN EL. 778'-0" AREA 2  
 CLINTON POWER STATION UNIT 1  
 ILLINOIS POWER COMPANY  
 CLINTON, ILLINOIS

**CARGENT & LUNDY**  
 ENGINEERS  
 CHICAGO, ILL.

DRAWING NO. A27-1003-02A  
 SHEET OF 1

POOR ORIGINAL

PDR

8410310484

