
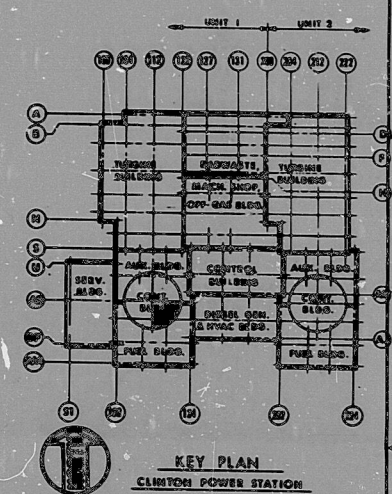


A27-1003-03A
 (27-1003-03A)

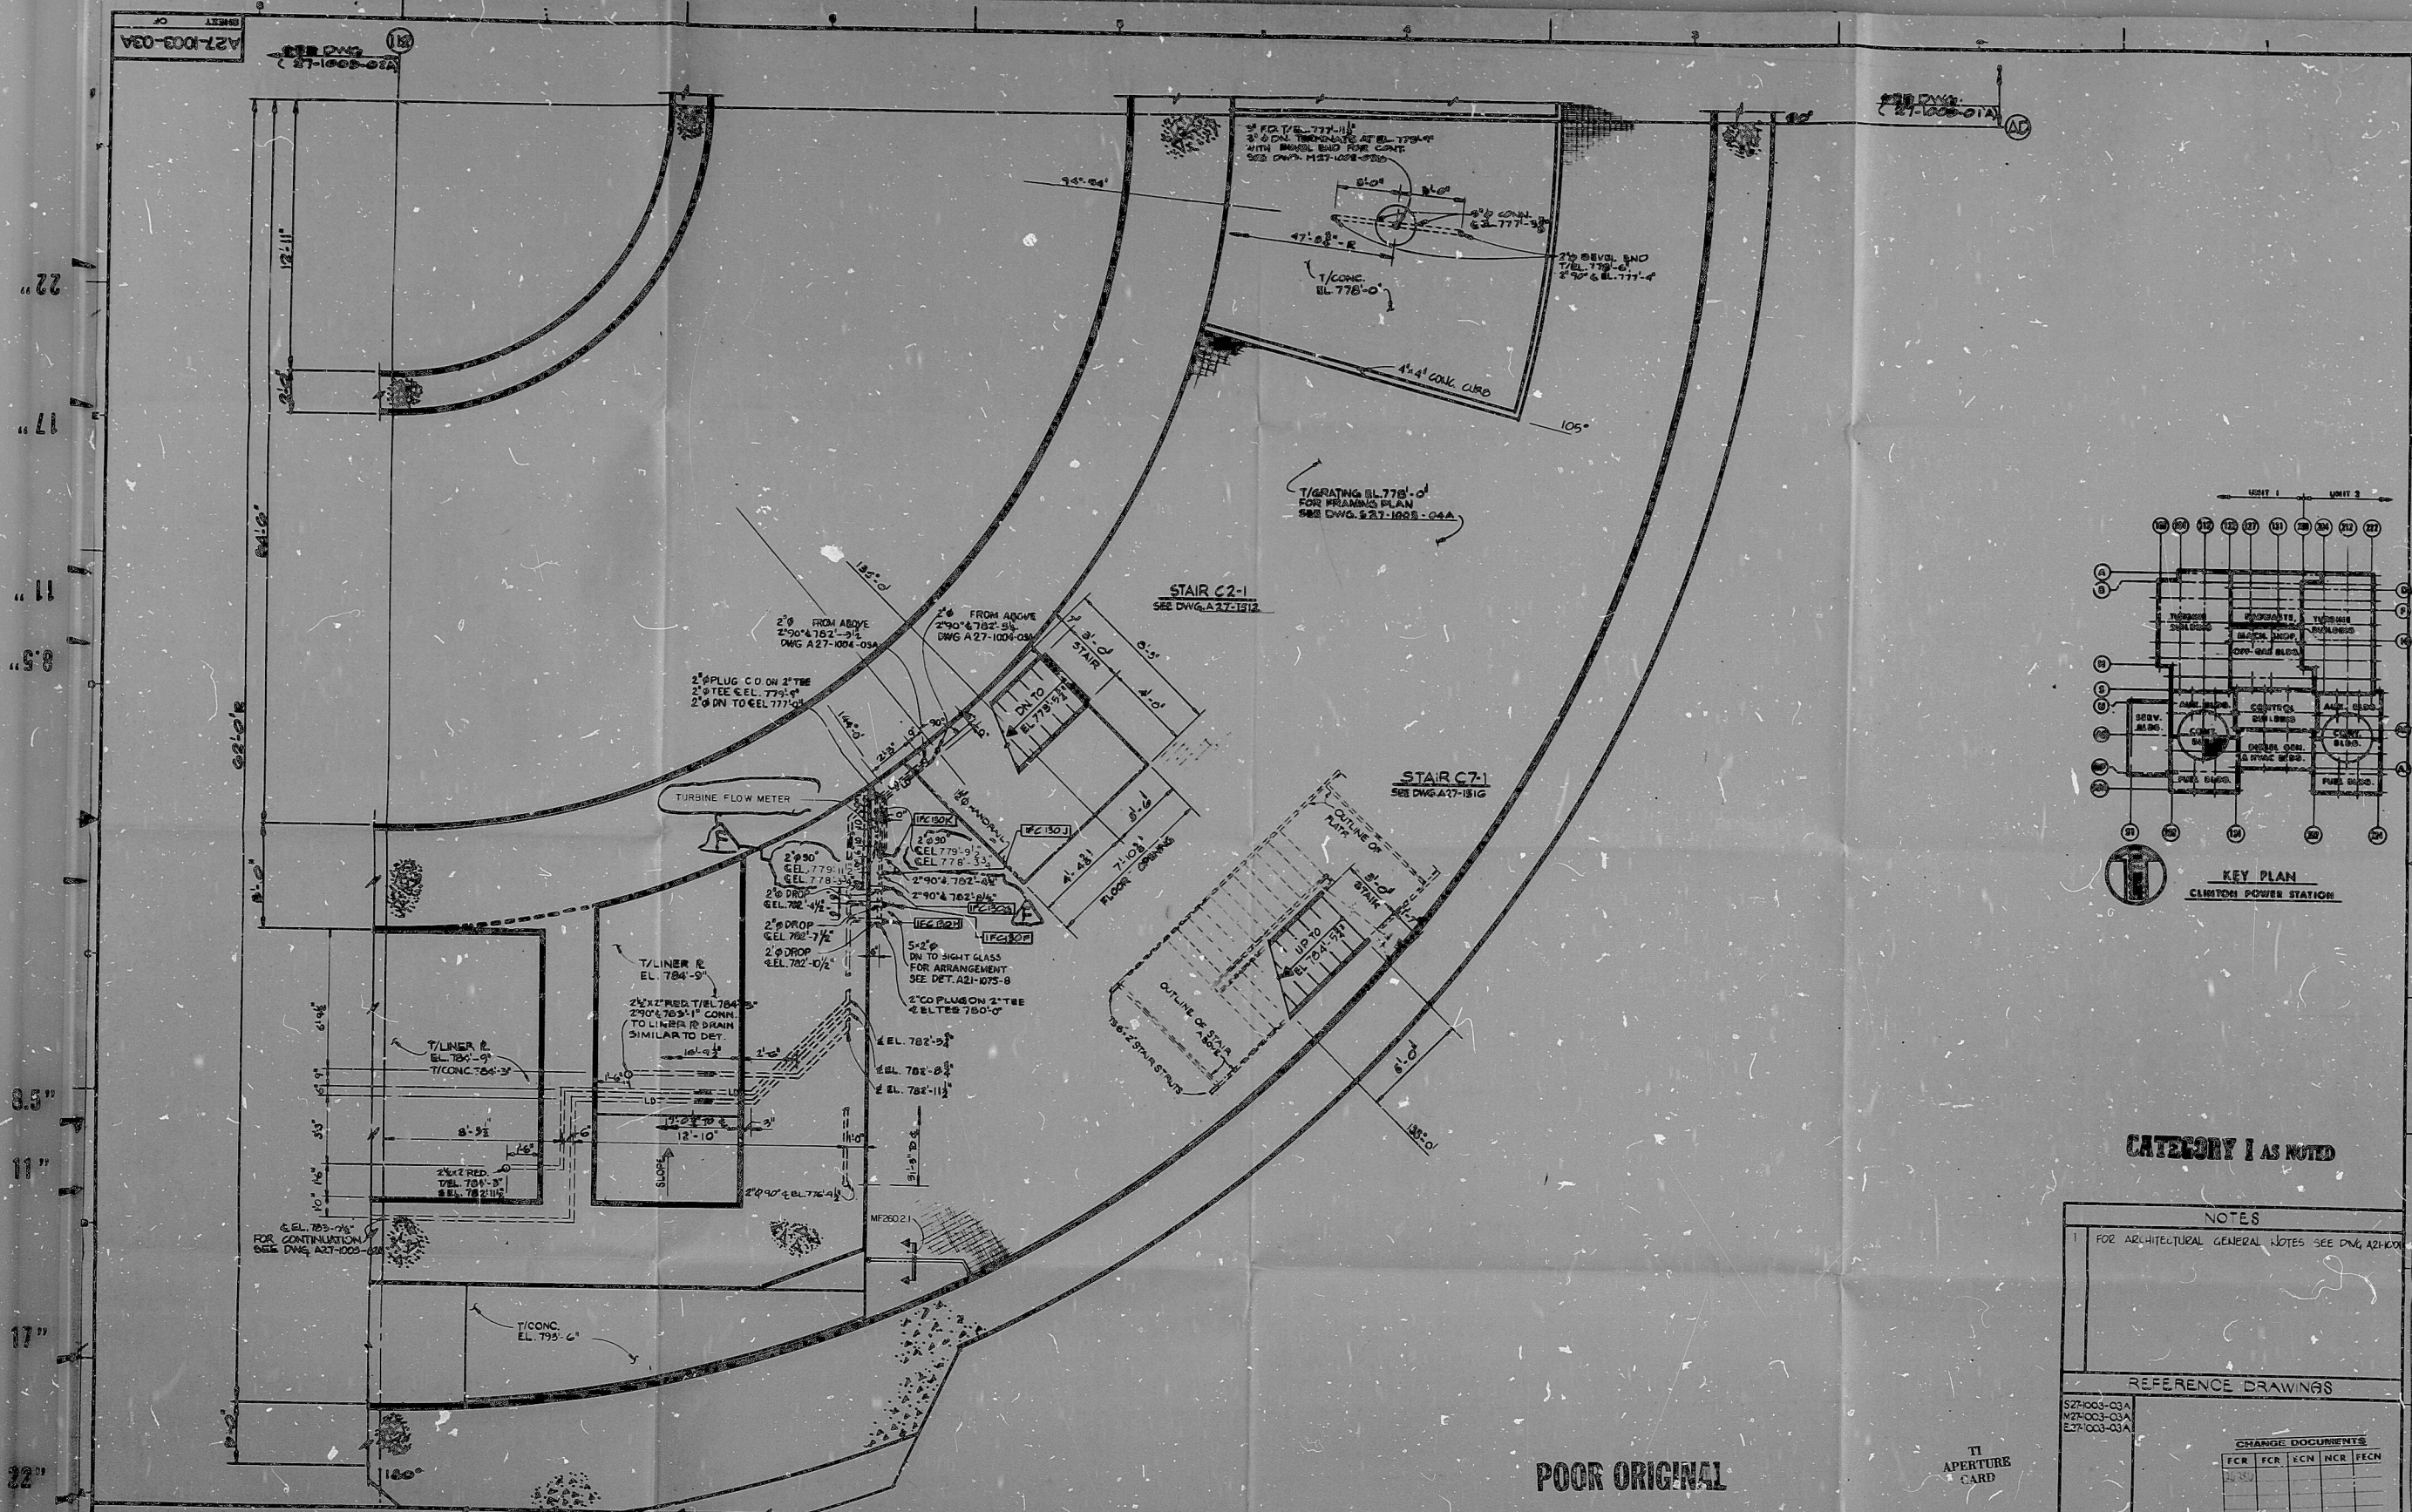

CATEGORY I AS NOTED

NOTES

FOR ARCHITECTURAL GENERAL NOTES SEE DWG. A27-1003-03A

REFERENCE DRAWINGS

| | |
|--------------|--|
| A27-1003-03A | |
| A27-1003-03A | |
| A27-1003-03A | |

CHANGE DOCUMENTS

| | | | |
|-----|------|----|-------------|
| NO. | DATE | BY | DESCRIPTION |
| | | | |
| | | | |

POOR ORIGINAL

| REV. | BY | DATE | DESCRIPTION |
|------|----|------|-------------|
| | | | |
| | | | |
| | | | |
| | | | |
| | | | |
| | | | |

PROJECT NUMBER: 8410310495
 CONTAINMENT BUILDING
 FLOOR PLAN EL. 778'-0" AREA 3
 CLINTON POWER STATION UNIT 1
 ILLINOIS POWER COMPANY
 CLINTON, ILLINOIS

DATE: 4-20-77
 DRAWING NO.: A27-1003-03A
 SHEET OF

2291

PDR

8410310493

