


22"
17"
11"
8.5"
8.5"
11"
17"
22"

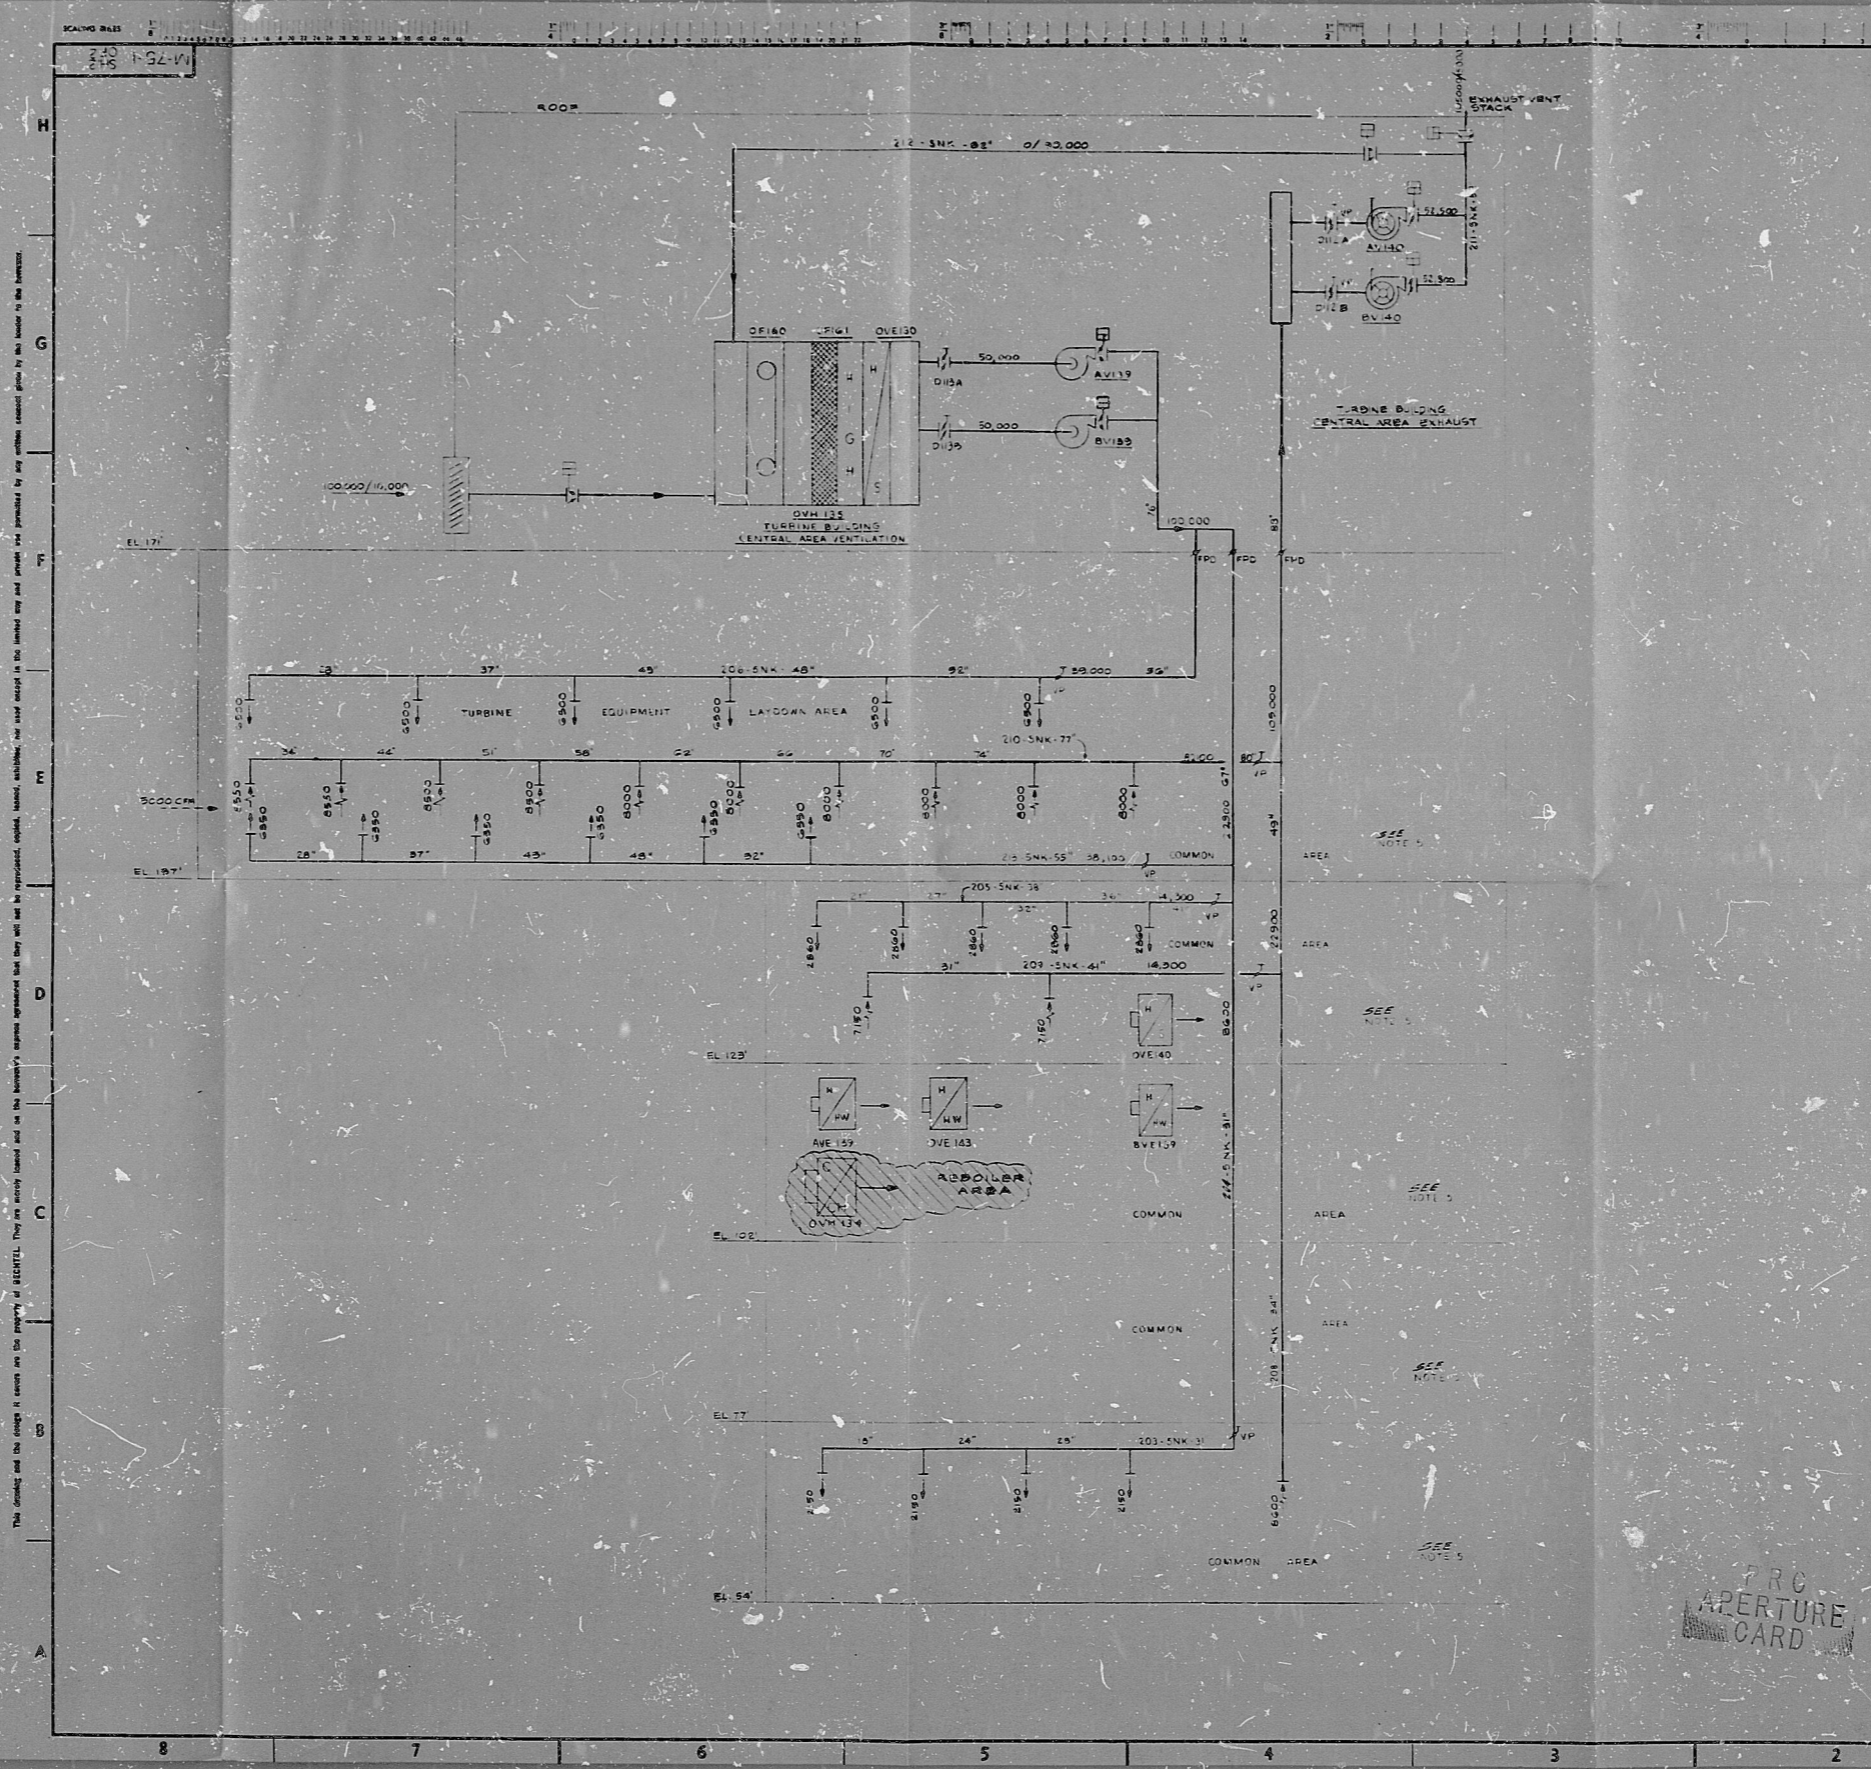

SIZE E

SYSTEM GE	
REF. REFERENCE DRAWING	BECHTEL NUMBER
1 TURBINE BLDG CONTROL DIAG	M-8142
2 TURBINE BLDG AIR FLOW DIAG	M-75121

- THIS PAGE CONTAINS PORTIONS OF SYSTEMS:
- GE - TURBINE BUILDING HVAC
 - 1. NO EQUIPMENT OR DUCTS ON THIS DRAWING ARE SEISMIC CATEGORY 1 OR 2 LISTED.
 - 2. INDEX NUMBER FOR AUTOMATICALLY PLACED DAMPERS ARE SHOWN ON THESE SHEETS.
 - 3. FOR COMPLETE LISTING AND RATING OF FIRE DAMPERS, SEE HVAC AREA DRAWINGS.
 - 4. THESE AREAS ARE SERVED BY THE TSS SYSTEM (SHOWN ON M-75121, INT. 1).

PRO APERTURE CARD

DATE	BY	CHKD	APP'D

BECHTEL
SAN FRANCISCO

PUBLIC SERVICE ELECTRIC AND GAS COMPANY
HOPE CREEK GENERATING STATION

P&ID
TURBINE BUILDING
AIR FLOW DIAGRAM

JOB NO.	DRAWING NO.	REV.
10855	M-75-1062	1

22"
17"
11"
8.5"
8.5"
11"
17"
22"

RIDS

8307270098

