

NOTES


1. THIS DRAWING IS INTENDED FOR USE IN COORDINATION OF THE MAIN TRANSFORMERS, UNIT AUXILIARY TRANSFORMER, AND ASSOCIATED EQUIPMENT GENERAL ARRANGEMENT ONLY. FOR EXACT EQUIPMENT INSTALLATION AND TERMINATION DETAILS, SEE THE CERTIFIED VENDOR DRAWINGS LISTED BELOW UNDER REFERENCE DRAWINGS.

2. LOCATION AND METHOD OF SUPPORT DETERMINED BY STRUCTURAL DEPARTMENT EXCEPT FIELD SHALL INSTALL INSULATORS ON SUPPORTS TO MATCH BUS ALIGNMENT.

INFORMATION
 THIS DOCUMENT IS SUBJECT TO REVISION WITHOUT NOTIFICATION TO THE USER OF THIS COPY

REFERENCE DWGS.

D-E-2001	ELECTRICAL G.A. - STATION
I-E-2201	PLOT PLAN - SOUTH AREA
O-E-001	MAIN TRANSFORMER YARD UNDERGROUND CONDUIT PLAN
E-E-1936	GROUNDING NOTES & DETAILS
	MAIN TRANSFORMER YARD GROUNDING PLAN
I-C-6001	CONCRETE MAIN AND UNIT AUXILIARY TRANSFORMERS' FOUNDATION
I-C-6004	LOCATION PLANS, SECTIONS & DETAILS
WESTHOUSE Pkg. 356/CT3	GROUNDING RESISTOR-OUTLINE B.R. FILE # 1502X003 B.R.
WESTHOUSE Pkg. 356/CT3	MAIN TRANSFORMER OUTLINE B.R. FILE # 1394X003 B.R.
WESTHOUSE Pkg. 356/CT3	UNIT AUXILIARY TRANSFORMER OUTLINE B.R. FILE # 1394X003 B.R.

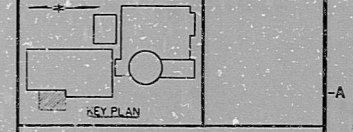

TERA APERTURE CARD

NO.	DATE	DESCRIPTION	BY	CHKD	APP'D	DATE	NO.	DATE	DESCRIPTION	BY	CHKD	APP'D	DATE
2	10-24-78	REVISED REF DWGS, ADDED TPNs N#3 & NEUTRAL BUS	UNJ	AKS	AKS	10/24/78							
1	7-13-78	ADD VENDOR REFERENCE DRAWINGS AND REVISED NEUTRAL GROUNDING RESISTOR LOCATION	K.R.	AKS	AKS	7/13/78							
0	4-24-78	ISSUED FOR CONSTRUCTION	K.R.	AKS	AKS	4/24/78							
C	3-25-78	ISSUED FOR REVIEW & COMMENTS	AKS	AKS	AKS	3/25/78							
B	4-1-77	RE-DRAWN PRELIMINARY ISSUE	AKS	AKS	AKS	4/1/77							

Brown & Root, Inc.
 ENGINEERS - CONTRACTORS
 HOUSTON, TEXAS

SOUTH TEXAS PROJECT
 ELECTRICAL
 UNIT #1 MAIN TRANSFORMER YARD
 GENERAL ARRANGEMENT

CONTRACT NO. CR-0241
 SCALE 1/8"=1'-0"
 DRAWING NO. 7-E-02
 I-E-2200-2

INFORMATION PRELIMINARY REVIEW USE CONSTRUCTION

BROWN & ROOT INC.
 MICROFILM SERVICES

 


FIG. 2 REPRODUCED FOR UNIT 2

8.5"
 11"
 17"

8.5"
 11"
 17"

R108

8112210089

