


- NOTES**
- RIGID STL. CND. SHALL BE UTILIZED IN DUCTS BETWEEN DYC & ELECT AUX BLDG.
 - ALL CONDUITS WILL BE INSTALLED ACCORDING TO CONDUIT NOTES & DETAILS DWG. 0-E-004.
 - FOR CONDUIT IDENTIFICATION SEE DWG. 1-E-218.
 - ALL ELBOWS TO BE 45° RADIUS.


INFORMATION
THIS DOCUMENT IS SUBJECT TO REVISION WITHOUT NOTIFICATION TO THE USER OF THIS COPY

- REFERENCE DWGS:**
- 0-E-2100 GEN. ARRANGEMENT STA. UNDERGROUND DUCT BANKS
 - 1-C-4004 CONC. MECH. & ELECT. AUX. BLDG. PLAN
 - 1-C-4007 CONC. MECH. & ELECT. AUX. BLDG. PLAN
 - 1-C-5001 CONC. DYC BLDG. PLAN EL. 25'-0"
 - 1-C-5002 CONC. DYC BLDG. PLAN EL. 25'-0"
 - 1-E-2756 P4C ELECT. AUX. BLDG. PLAN EL. 10'-0"
 - 1-E-2757 P4C ELECT. AUX. BLDG. PLAN EL. 10'-0"
 - 1-E-2817 CABLE TRAY ELECT. AUX. BLDG. PLAN EL. 10'-0"
 - 1-E-2818 CABLE TRAY ELECT. AUX. BLDG. PLAN EL. 10'-0"
 - 1-E-2941 FLOOR & WALL SLEEVE PLAN EL. 10'-0"
 - 1-E-1549 DYC BLDG. GROUNDING PLAN

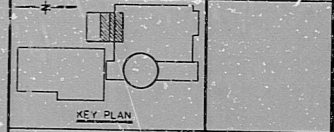

NO.	DATE	DESCRIPTION	BY	CHKD.	APP.
4	2-11-84	MADE DIMENSIONAL CHGS. TO STUD UPS PER AREA 1-E-0355 & AREA 1-E-0359. BACKGROUND CHGS. ADDED. DETAIL.	J.D.	W.S.	RR
3	3-1-78	REVISED COLUMN IDENTIFICATION.	J.P.	W.S.	RR
2	1-25-78	REVISED AS INDICATED & ISSUED FOR CONSTRUCTION.	J.P.	W.S.	RR
1	1-25-77	REDRAWN AND RELEASED HOLD - ISSUED FOR CONSTRUCTION.	J.P.	W.S.	RR

 Brown & Root, Inc.
SOUTH TEXAS PROJECT
ELECTRICAL
CLASS 1E UNDERGROUND DUCT BANK
DIESEL GEN. BLDG. TO ELECT. AUX. BLDG.
PLAN AND SECTIONS
CONTRACT NO. CR-0241
SCALE 1/4"=1'-0"
DRAWING NO. 5-E-10
I-E-2110-4



INFORMATION PRELIMINARY REVIEW USE CONSTRUCTION

RIDS

8112210993

