


2 JO 7
13245 O-26-W

SIZE E
SYSTEM - GH

REF NO.	REFERENCE DRAWINGS	BECHTEL YEAR
1	RADWASTE AIR-FLOW DIAGRAM	M-91-0
2	RADWASTE LOGIC DIAGRAM	M-91-0
3	CHILLED WATER SYSTEM	M-91-1
4	PLANT HEATING	M-96-0
5	RADWASTE LOOP DIAGRAM	J-409-0

NOTES:
 1 THIS P&ID CONTAINS STARTUP SYSTEM
 2 GH-AUXILIARY BULBINE (RADWASTE AREA)
 3 W/VAC

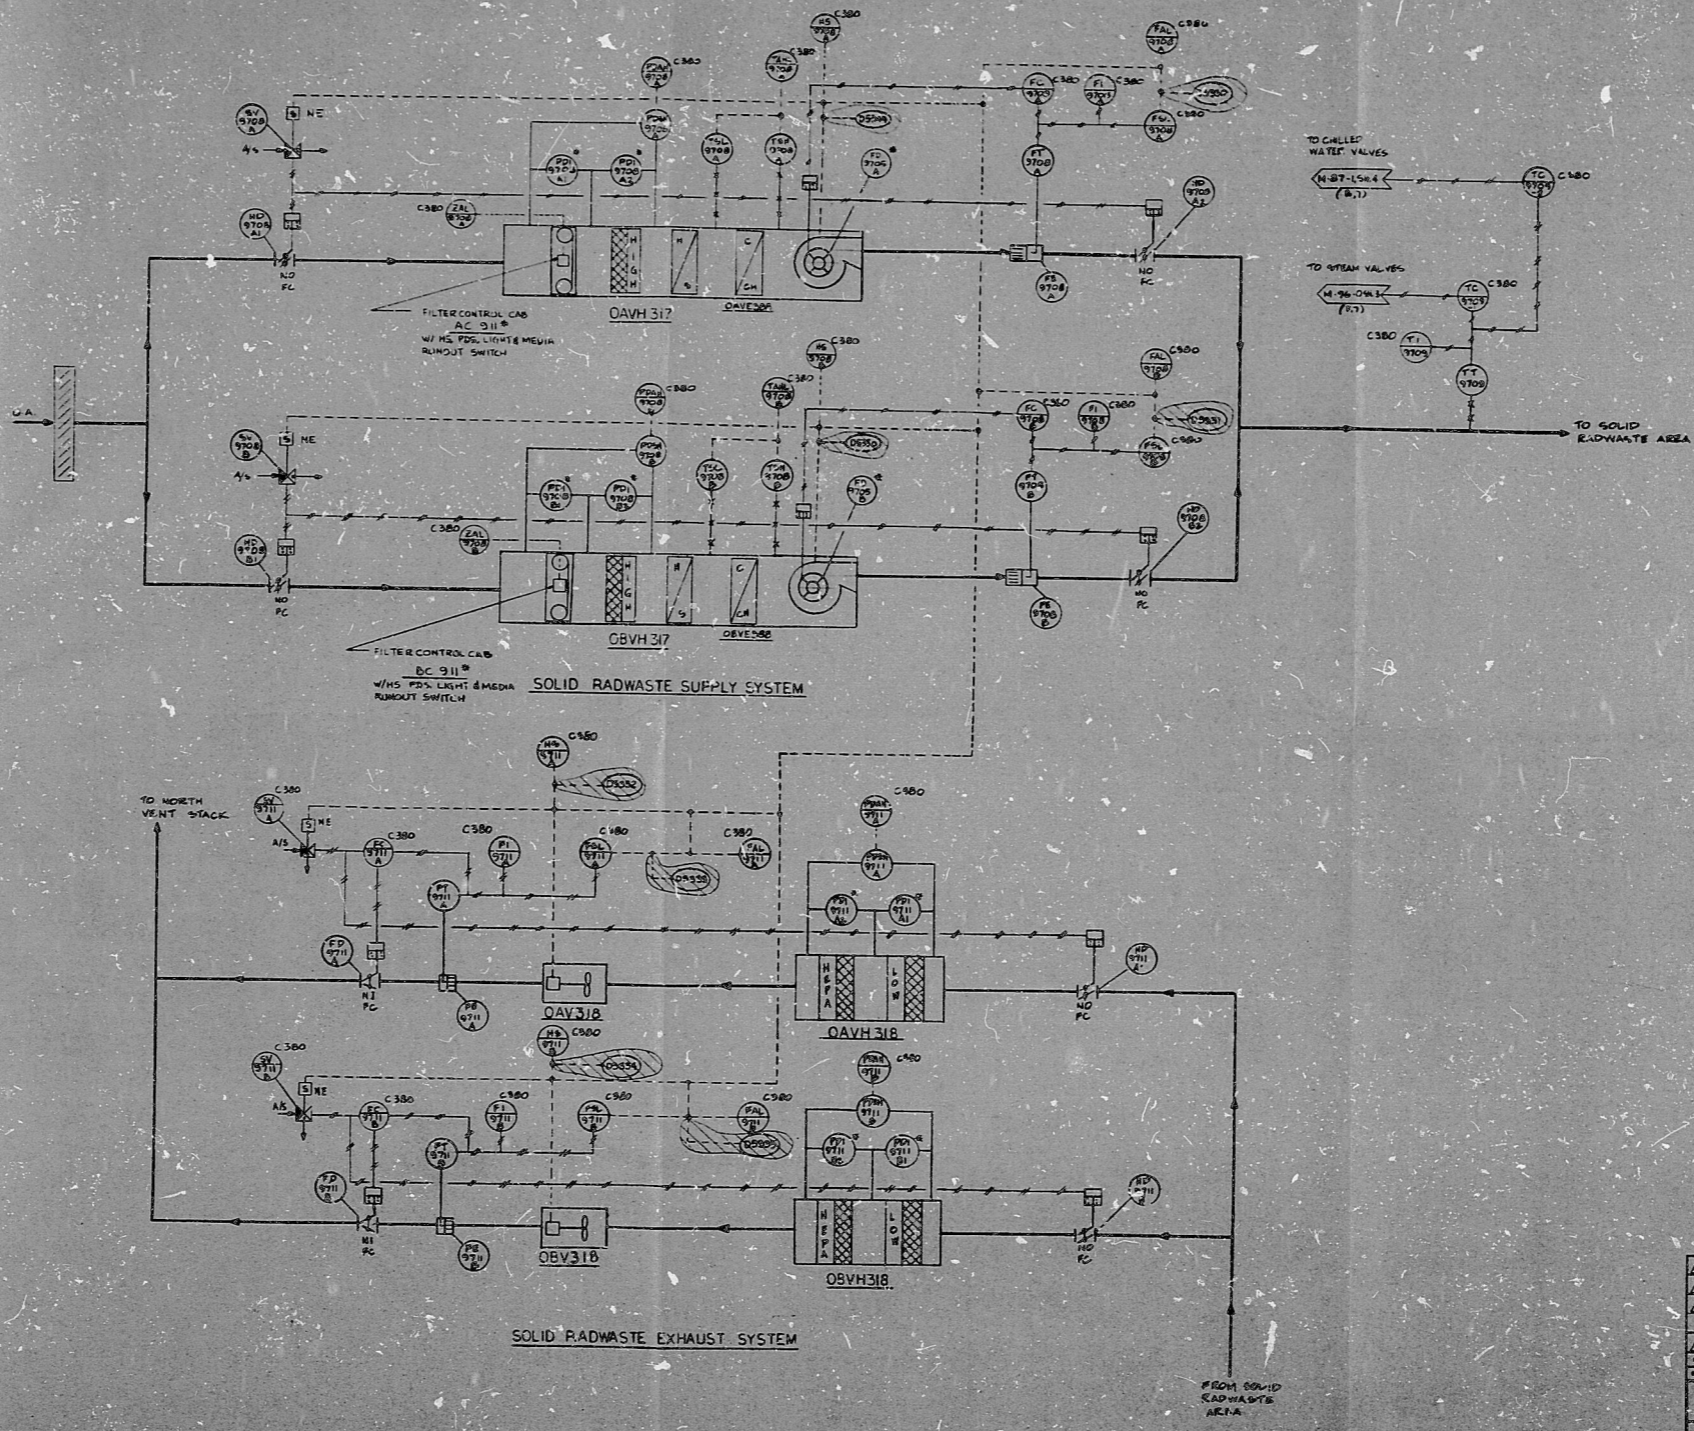

The drawing and the design it contains are the property of BECHTEL. They are made based on the drawings and specifications of the customer and are not to be used for any other purpose without the written consent of BECHTEL.

PRO-
APERTURE
CARD

DATE	BY	CHKD BY	APP'D BY
BECHTEL SAN FRANCISCO PUBLIC SERVICE ELECTRIC AND GAS COMPANY MOORE CREEK GENERATING STATION P&ID AUX. BLDG. RADWASTE AREA CONTROL DIAGRAM SHEET NO. M-92-0, SHEET 4			

RIDS

8307270/71

