



E-587SH2OF2

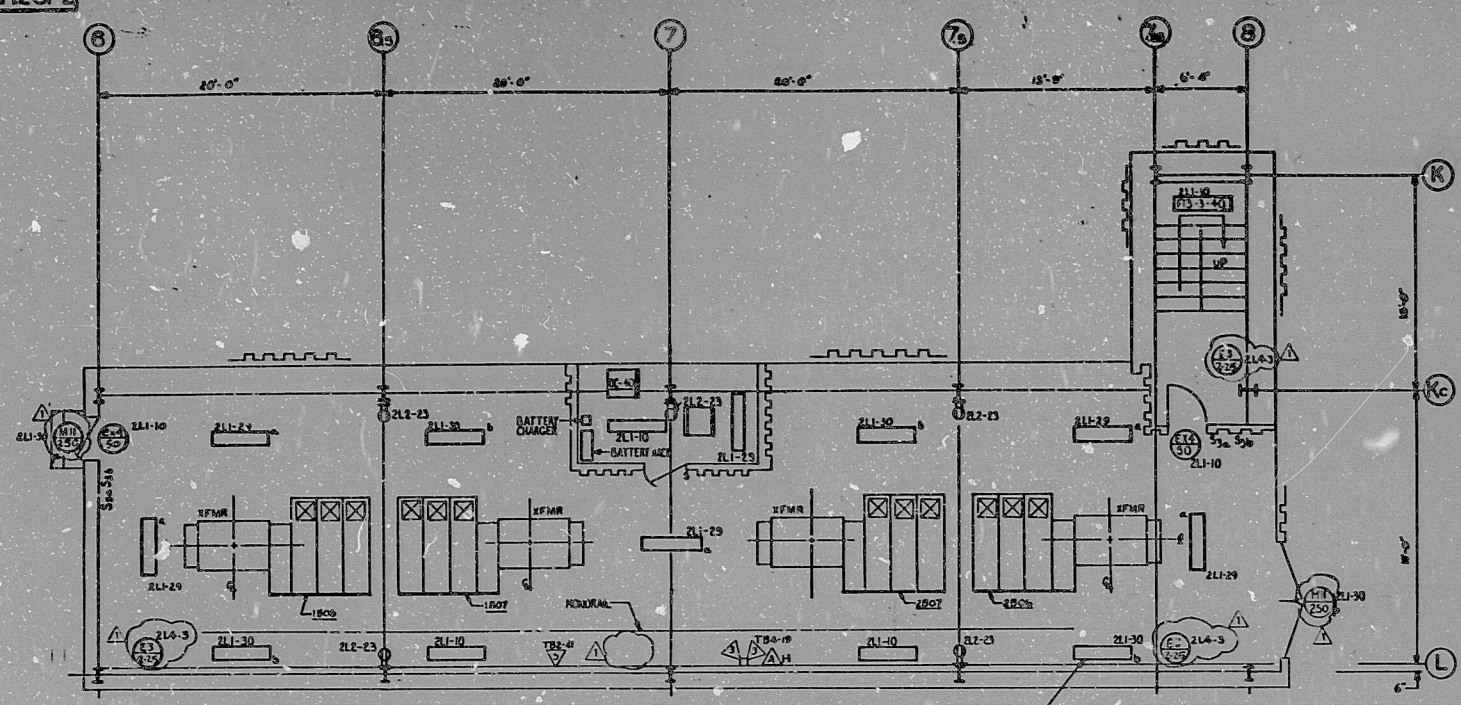

LIGHTING & COMMUNICATIONS PLAN FL EL 715'-7"
SCALE: 1/4"=1'-0"


FIG. 3-40 LTR FOR 13 FIXTURES
MOUNTING HEIGHT 13'-10" ABOVE
FINISH FLOOR. FOR MOUNTING DETAIL
SEE E-44.34.46.

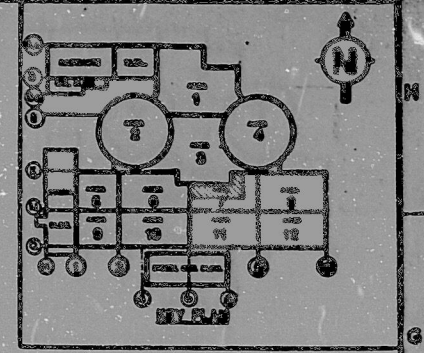

POOR ORIGINAL

TERA
APERTURE
CARD

REFERENCE DRAWINGS
E-41 GROUNDING NOTES, SYMBOLS, AND DETAILS.
E-43 REV. 7 COMMUNICATIONS NOTES, SYMBOLS, AND DETAILS.
E-44 REV. 7 LIGHTING NOTES, SYMBOLS, AND DETAILS.
E-45 REV. 7 LIGHTING PANEL SCHEDULE.

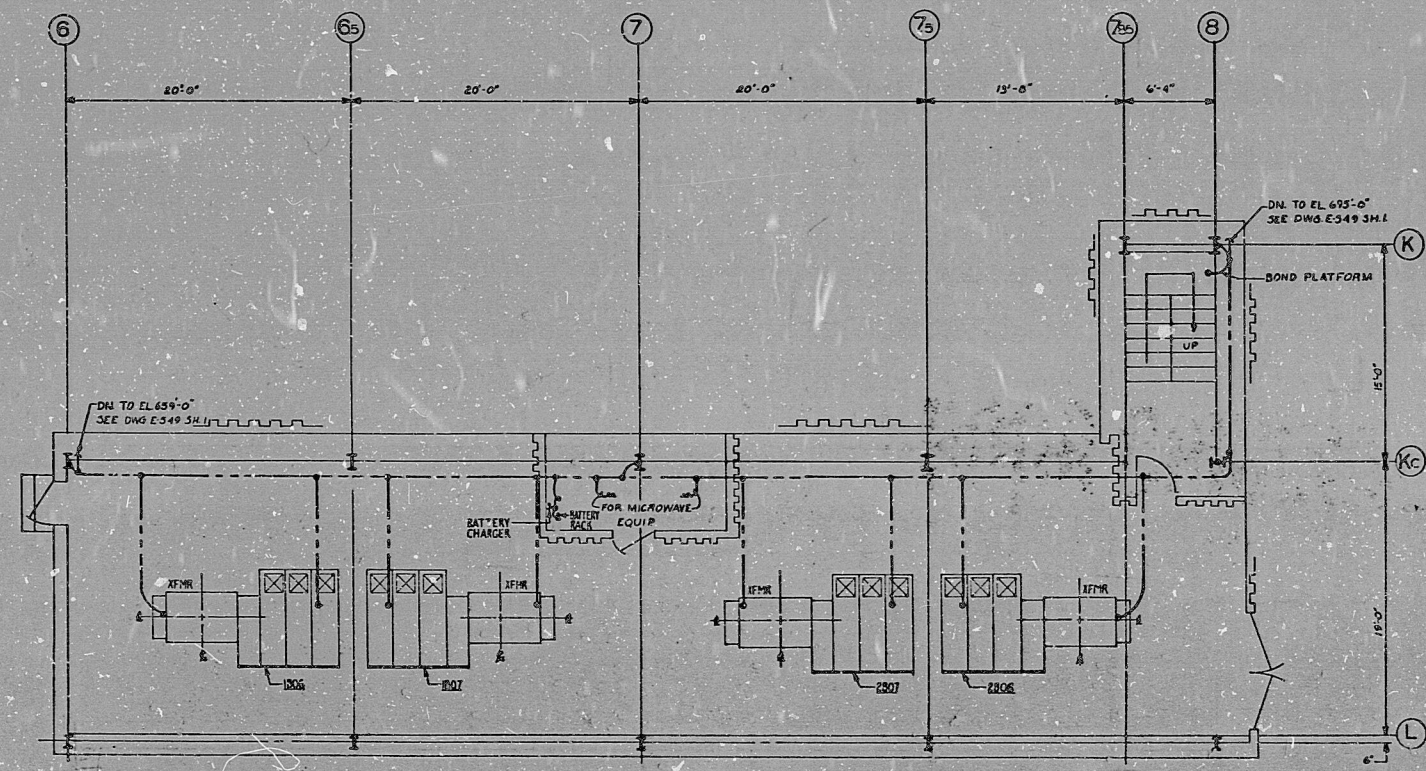

GROUNDING LAYOUT FL EL 715'-7"
SCALE: 1/4"=1'-0"

30X

I certify that the design contained on this drawing was made in the normal and regular course of business, on the date stated below and that it is submitted for reproduction.

RECHTEL	DATE	BY	CHECKED	DATE	BY
MIDLAND PLANT UNITS 1 & 2					
CONSUMERS POWER COMPANY					
LIGHTING, COMMUNICATIONS & GROUNDING					
TURBINE BUILDING UNIT 2					
EL 715'-7" & EXISTING ROOF					
JOB NO.	7220	REVISION NO.	2	DATE	
7220	E-587SH2OF2	1			

THIS DRAWING IS THE PROPERTY OF CONSUMERS POWER COMPANY. IT IS TO BE USED FOR THE PROJECT AND SITE SPECIFICALLY IDENTIFIED HEREON. IT IS NOT TO BE REPRODUCED, COPIED, OR IN ANY MANNER USED FOR ANY OTHER PROJECT WITHOUT THE WRITTEN PERMISSION OF CONSUMERS POWER COMPANY.

RIDS

820150149

