
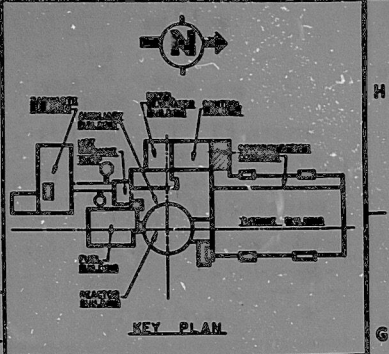
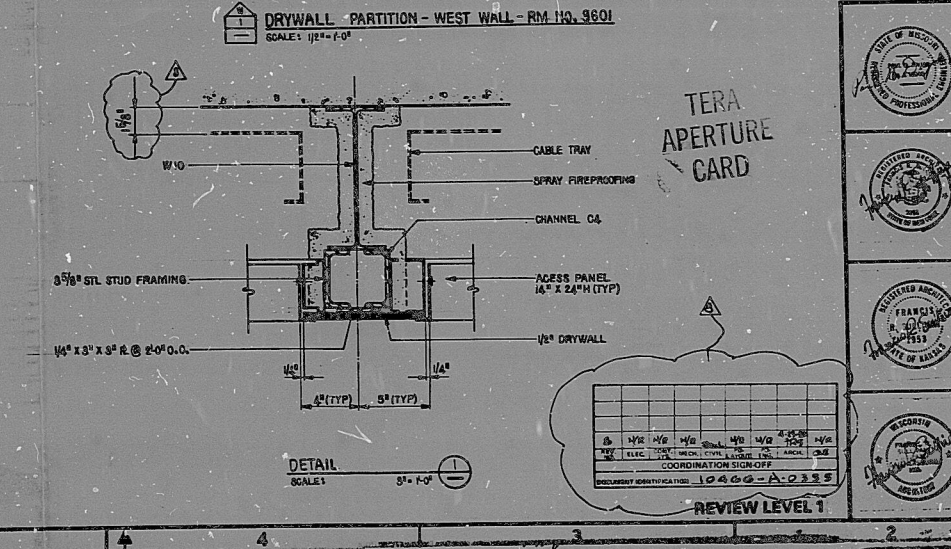
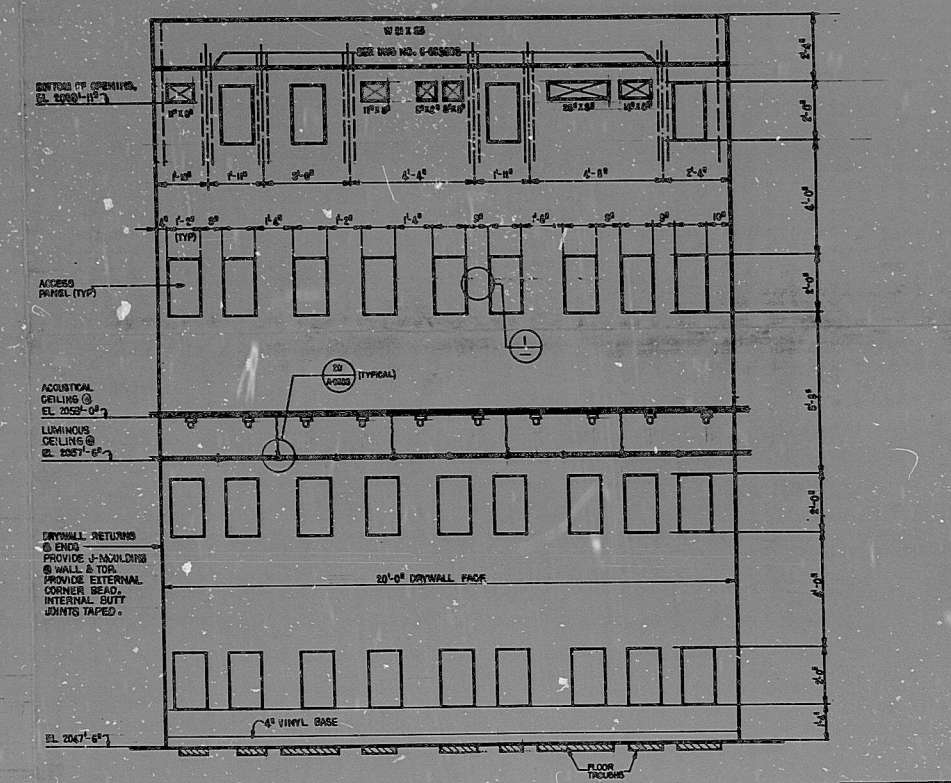
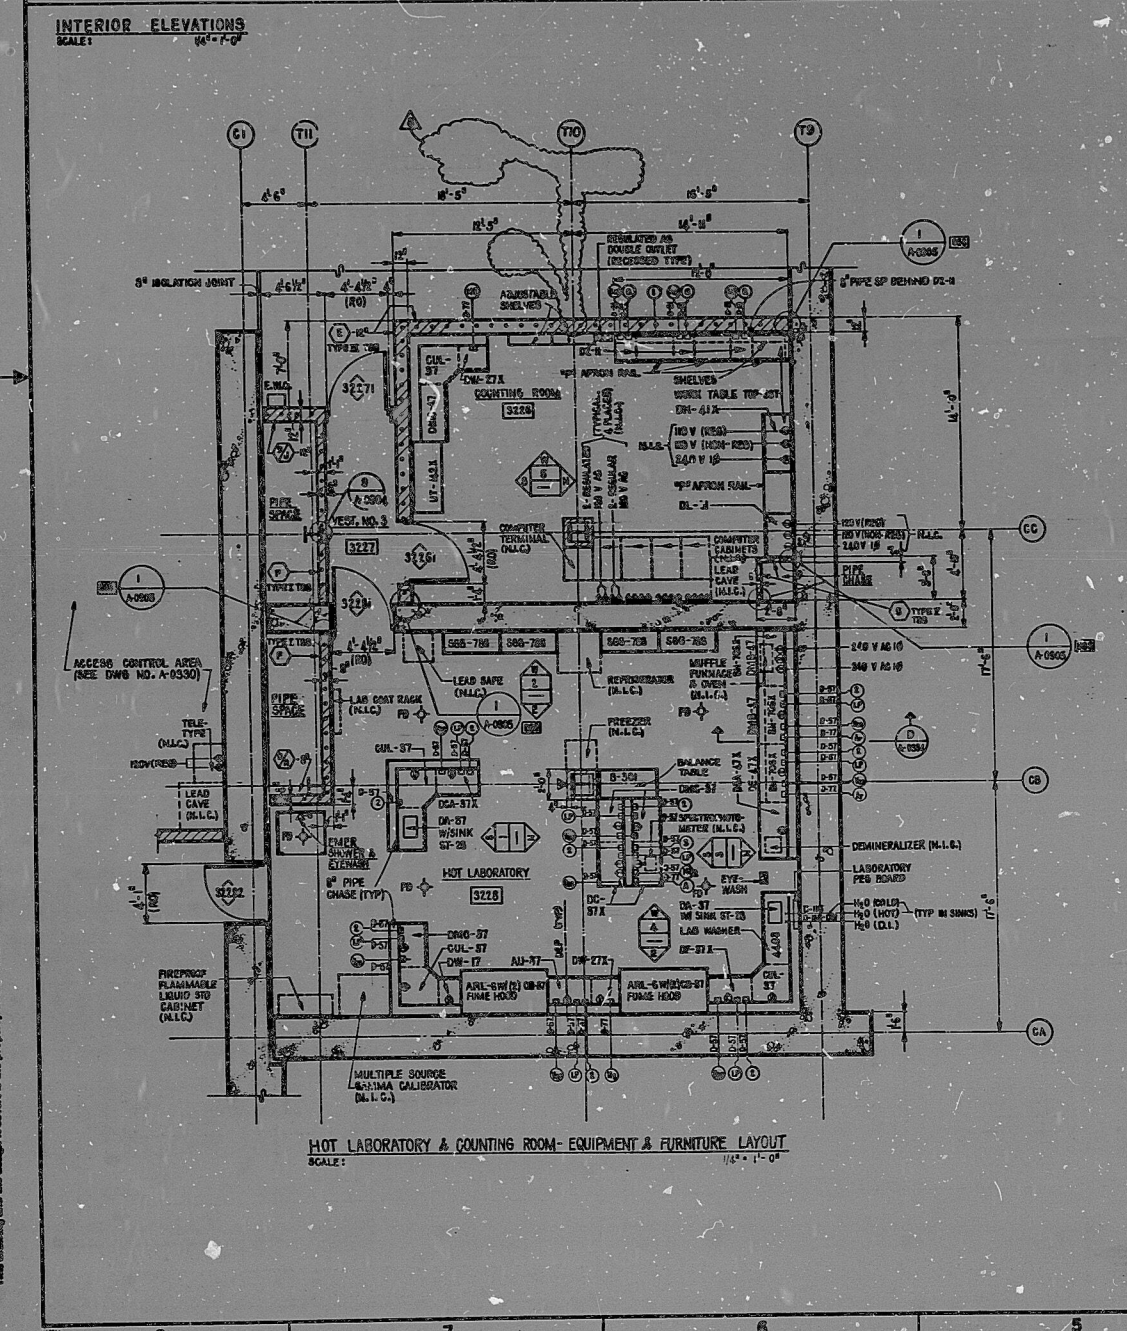


This drawing and the design it contains is the property of the University of Maryland and shall remain the property of the University of Maryland. It is loaned to the contractor for his use only and shall not be reproduced, copied, or used in any way without the written consent of the University of Maryland. The contractor shall be responsible for the protection of this drawing and shall not be held liable for any loss or damage to it.

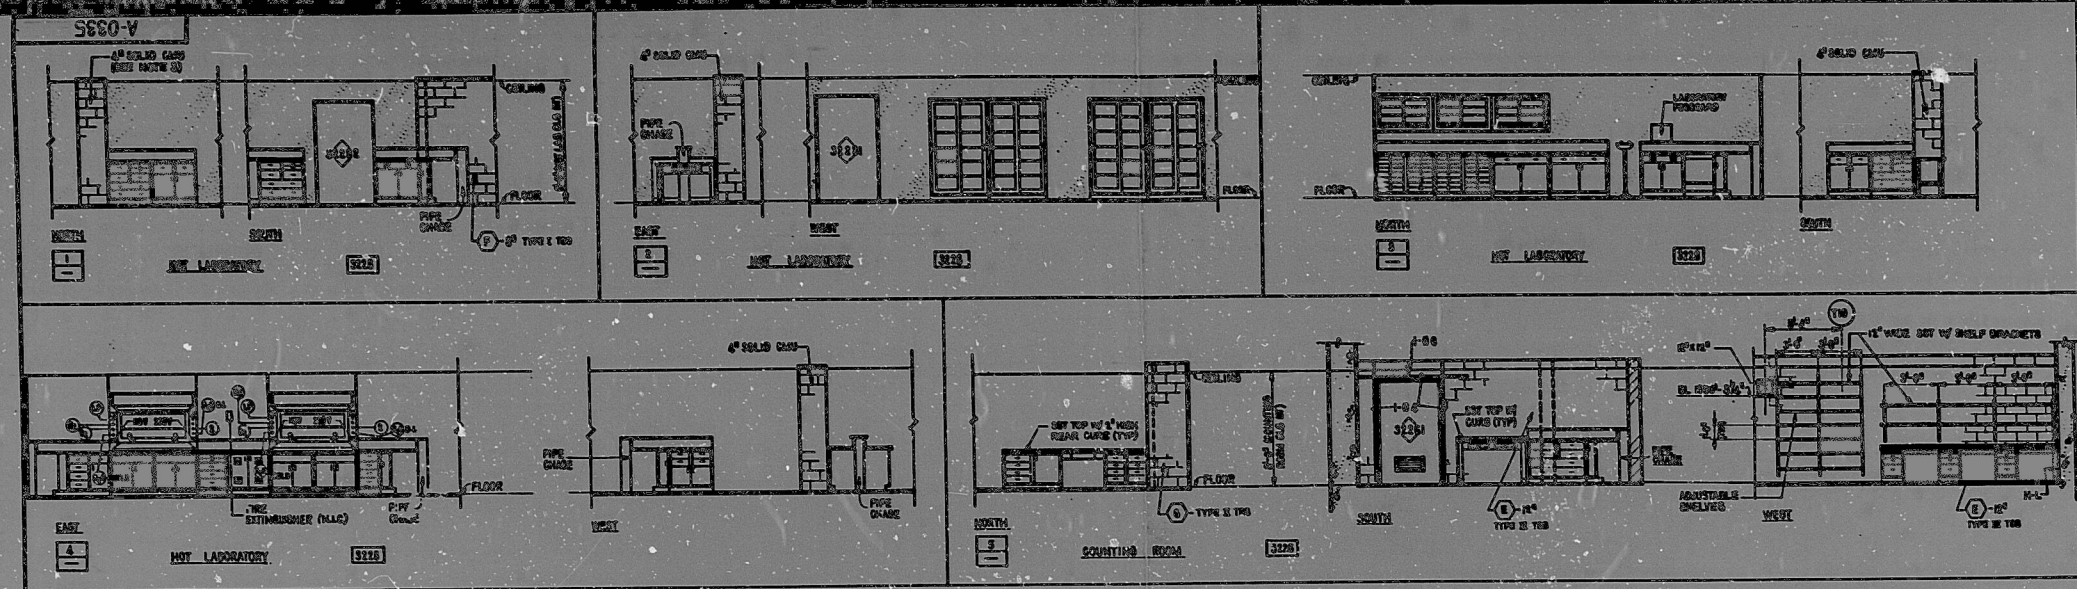

**NOTES**

- FOR GENERAL NOTES, SEE DRAWING NO. A-0331.
- ALL EQUIPMENT NUMBERS SHOWN ARE BASED ON GENERAL EQUIPMENT COORDINATION, PROVISIONAL NEW YORK.
- ALL CURB WALLS SHOULD BE 8\"/>
- SEE SCHEDULE A-0335 FOR FINISH SCHEDULE.
- FOR GENERAL LABORATORY, COUNTING ROOM SCHEDULES, SEE DRAWING NO. A-0335.

**LEGEND**

- ① - ACCESS (NOT ON LAZE IS SHOWN REARER)
- ② - METRIC GAUGE
- ③ - WINDOW
- ④ - DOOR
- ⑤ - PARTITION
- ⑥ - CEILING CAS
- ⑦ - ELECTRICAL OUTLET (LIMITED W/AL OUTLETS SUPPLY (W/AL OUT)
- ⑧ - ELECTRICAL OUTLET (120 V AS W/AL) NO DEP
- ⑨ - TELEPHONE OUTLET
- ⑩ - COMPRESSED AIR
- ⑪ - ACETYLENE
- ⑫ - WITTHOUSE
- HL-C - NOT IN CONTRACT, ORDER FURNISHED
- TR - TOP BRUSH (SEE SECTION), SEE SCHEDULE
- DB - END WALL SUPPORT, SEE DETAILS

**REFERENCE DRAWINGS**

- A-0331 - GENERAL BUILDING & COMMUNICATIONS FLOOR PLAN @ EL. 100'-0\"/>
- A-0332 - GENERAL CEILING DETAILS
- A-0333 - DOOR SCHEDULE
- A-0334 - DOOR SCHEDULE
- A-0335 - FINISH SCHEDULE
- A-0336 - FINISH SCHEDULE
- A-0337 - ACCESS ON GEN. AREA, CENTRAL A COMPUTER ROOM, REFLECTOR CEILING PLANS
- C-0339 - CONCRETE HEAT LINE, COMMUNICATIONS CENTER

**NOTES (CONTINUED)**

7. SYMBOL SHOWING AS DUAL X IS VERTICAL REF. Y IS HORIZONTAL REF. SEE SCHEDULE DWS A-0325.

NOTICE: ALTERATION OF THIS DOCUMENT BY ANY PERSON OTHER THAN THE LICENSED ARCHITECT OR ANY PERSON ACTING UNDER THEIR DIRECTION IS ILLEGAL.

**BECHTEL**  
ARCHITECTURAL  
HOT LABORATORY EQUIPMENT & FURNITURE LAYOUT, ELEVATIONS AND DETAILS-EL 100'-0\"/>

NO.	DATE	REVISIONS	BY	CHK	APP
1		REVISED AS NOTED, COORDINATED			
2		APPROVED FOR CONSTRUCTION			
3		REVISED AS NOTED			
4		REVISED AS NOTED			
5		REVISED AS NOTED			
6		REVISED AS NOTED			
7		REVISED AS NOTED			
8		REVISED AS NOTED			
9		REVISED AS NOTED			
10		REVISED AS NOTED			

**SCALE:** AS SHOWN DATE: 10-20-66 (DESIGNED: 10-20-66) DRAWN: 10-20-66

NO.	DATE	REVISIONS	BY	CHK	APP
1		REVISED AS NOTED, COORDINATED			
2		APPROVED FOR CONSTRUCTION			
3		REVISED AS NOTED			
4		REVISED AS NOTED			
5		REVISED AS NOTED			
6		REVISED AS NOTED			
7		REVISED AS NOTED			
8		REVISED AS NOTED			
9		REVISED AS NOTED			
10		REVISED AS NOTED			

**SCALE:** AS SHOWN DATE: 10-20-66 (DESIGNED: 10-20-66) DRAWN: 10-20-66

NO.	DATE	REVISIONS	BY	CHK	APP
1		REVISED AS NOTED, COORDINATED			
2		APPROVED FOR CONSTRUCTION			
3		REVISED AS NOTED			
4		REVISED AS NOTED			
5		REVISED AS NOTED			
6		REVISED AS NOTED			
7		REVISED AS NOTED			
8		REVISED AS NOTED			
9		REVISED AS NOTED			
10		REVISED AS NOTED			

**SCALE:** AS SHOWN DATE: 10-20-66 (DESIGNED: 10-20-66) DRAWN: 10-20-66

NO.	DATE	REVISIONS	BY	CHK	APP
1		REVISED AS NOTED, COORDINATED			
2		APPROVED FOR CONSTRUCTION			
3		REVISED AS NOTED			
4		REVISED AS NOTED			
5		REVISED AS NOTED			
6		REVISED AS NOTED			
7		REVISED AS NOTED			
8		REVISED AS NOTED			
9		REVISED AS NOTED			
10		REVISED AS NOTED			

**SCALE:** AS SHOWN DATE: 10-20-66 (DESIGNED: 10-20-66) DRAWN: 10-20-66

I certify that the image contained on this frame was made in the normal and proper course of business, on the date listed below and that it is an accurate reproduction of the document(s) submitted to micrographic.

DATE: 10-20-66 OPERATOR: [Signature] SUPERVISOR: [Signature]

30X

800200 562



PDR

8007300562

