



E-587 SH2 OF 2

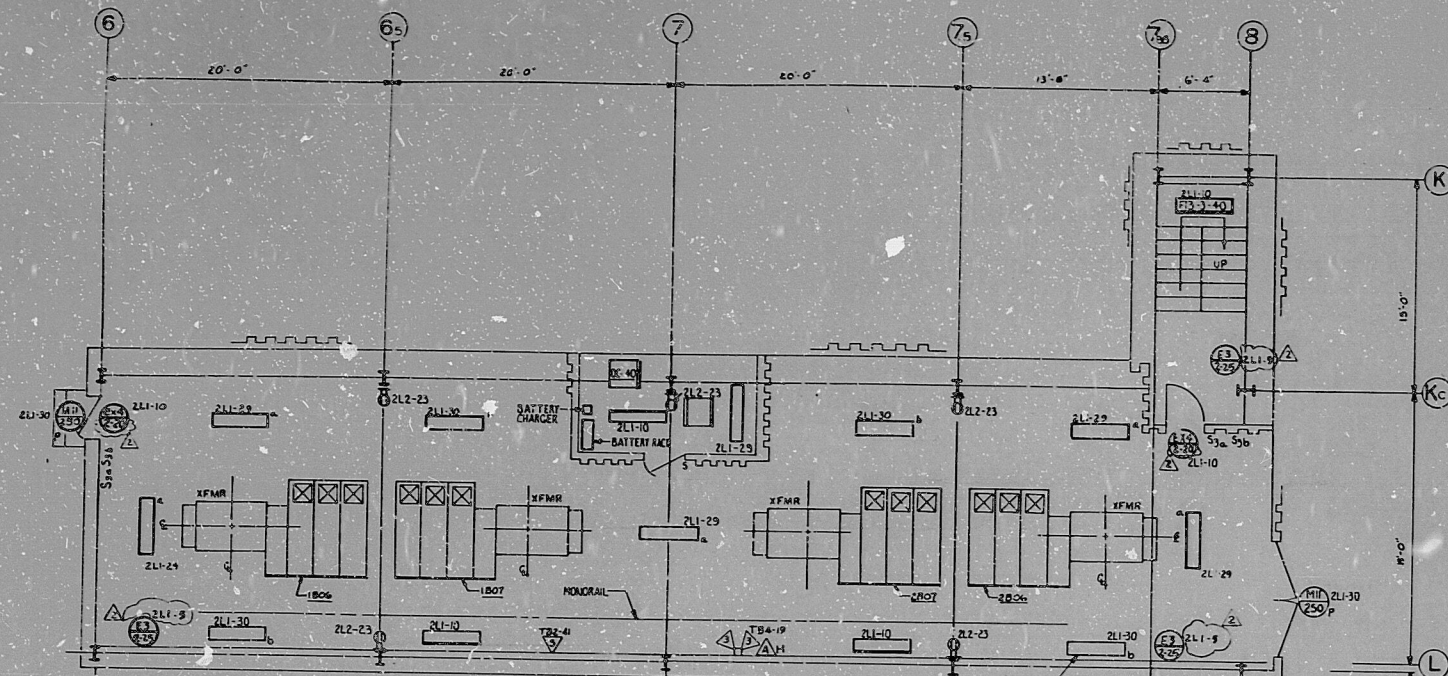

LIGHTING & COMMUNICATIONS PLAN FL EL 715'-7"
SCALE: (N.T.S.)

FIG. 1-40 (TYP FOR 13 FIXTURES)
MOUNTING HEIGHT IS 10'-0" ABOVE
FINISH FLOOR. FOR MOUNTING DETAIL
SEE E-44, SH 46.

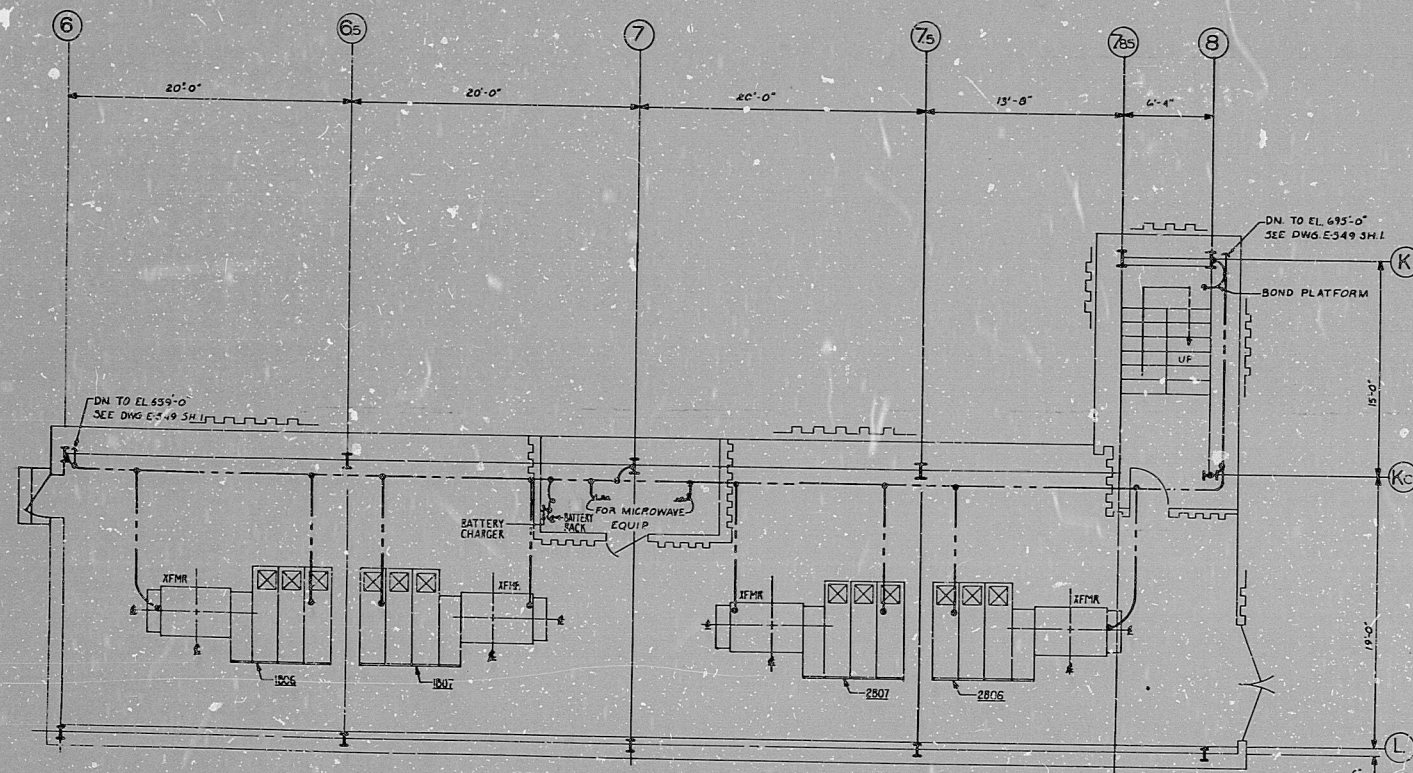

GROUNDING LAYOUT FL EL 715'-7"
SCALE: 1/4"=1'-0"

REFERENCE DRAWINGS

- E-41 GROUNDING NOTES, SYMBOLS, AND DETAILS
- E-42 COMMUNICATIONS NOTES, SYMBOLS, AND DETAILS
- E-43 LIGHTING NOTES, SYMBOLS, AND DETAILS
- E-44 LIGHTING PANEL SCHEDULE

30X

1. LAYOUTS FOR THE WORK SHOWN ON THIS DRAWING
AND SHOWN ON THE OTHER DRAWINGS OF THIS SET
SHALL BE THE RESPONSIBILITY OF THE CONTRACTOR.
2. THE CONTRACTOR SHALL BE RESPONSIBLE FOR THE
CORRECTNESS OF THE LAYOUTS AND THE WORK
SHOWN ON THIS DRAWING.

DATE: 10/10/70 BY: C. STONE

APERTURE
CARD

Rev. E-110925
DRAWING NO. E-587 SH2 OF 2
STARTUP AND SHUTDOWN OF
EQUIPMENT OR AFTER TURNING
OFF BY THE CONTRACTOR
System No. 7220
Date 11/10/70

NO.	DATE	REVISION	BY	CHECKED
1	10/10/70	ISSUED FOR CONSTRUCTION	C. STONE	
BECHTEL ARCH. ARCH. ARCH. ARCH. ARCH.				
MIDLAND PLANT UNITS 1 & 2 CONSUMERS POWER COMPANY				
LIGHTING COMMUNICATIONS & GROUNDING TURBINE BUILDING UNIT 2 EL 715'-7" & EXISTING ROOF				
7220	E-587 SH2 OF 2	2		

USE THIS DRAWING FOR
ELECTRICAL WORK ONLY
FOR ALL OTHER DATA REFER
TO APPLICABLE DRAWINGS

RIDS

8203090488

